


- NOTES:
1. NUMBER OF HOPPERS TO BE CONFIRMED DURING DETAILED DESIGN.
  2. SIZE AND QUANTITY OF ADDITIONAL EQUIPMENT REQUIRED TO BE DETERMINED DURING DETAILED DESIGN.

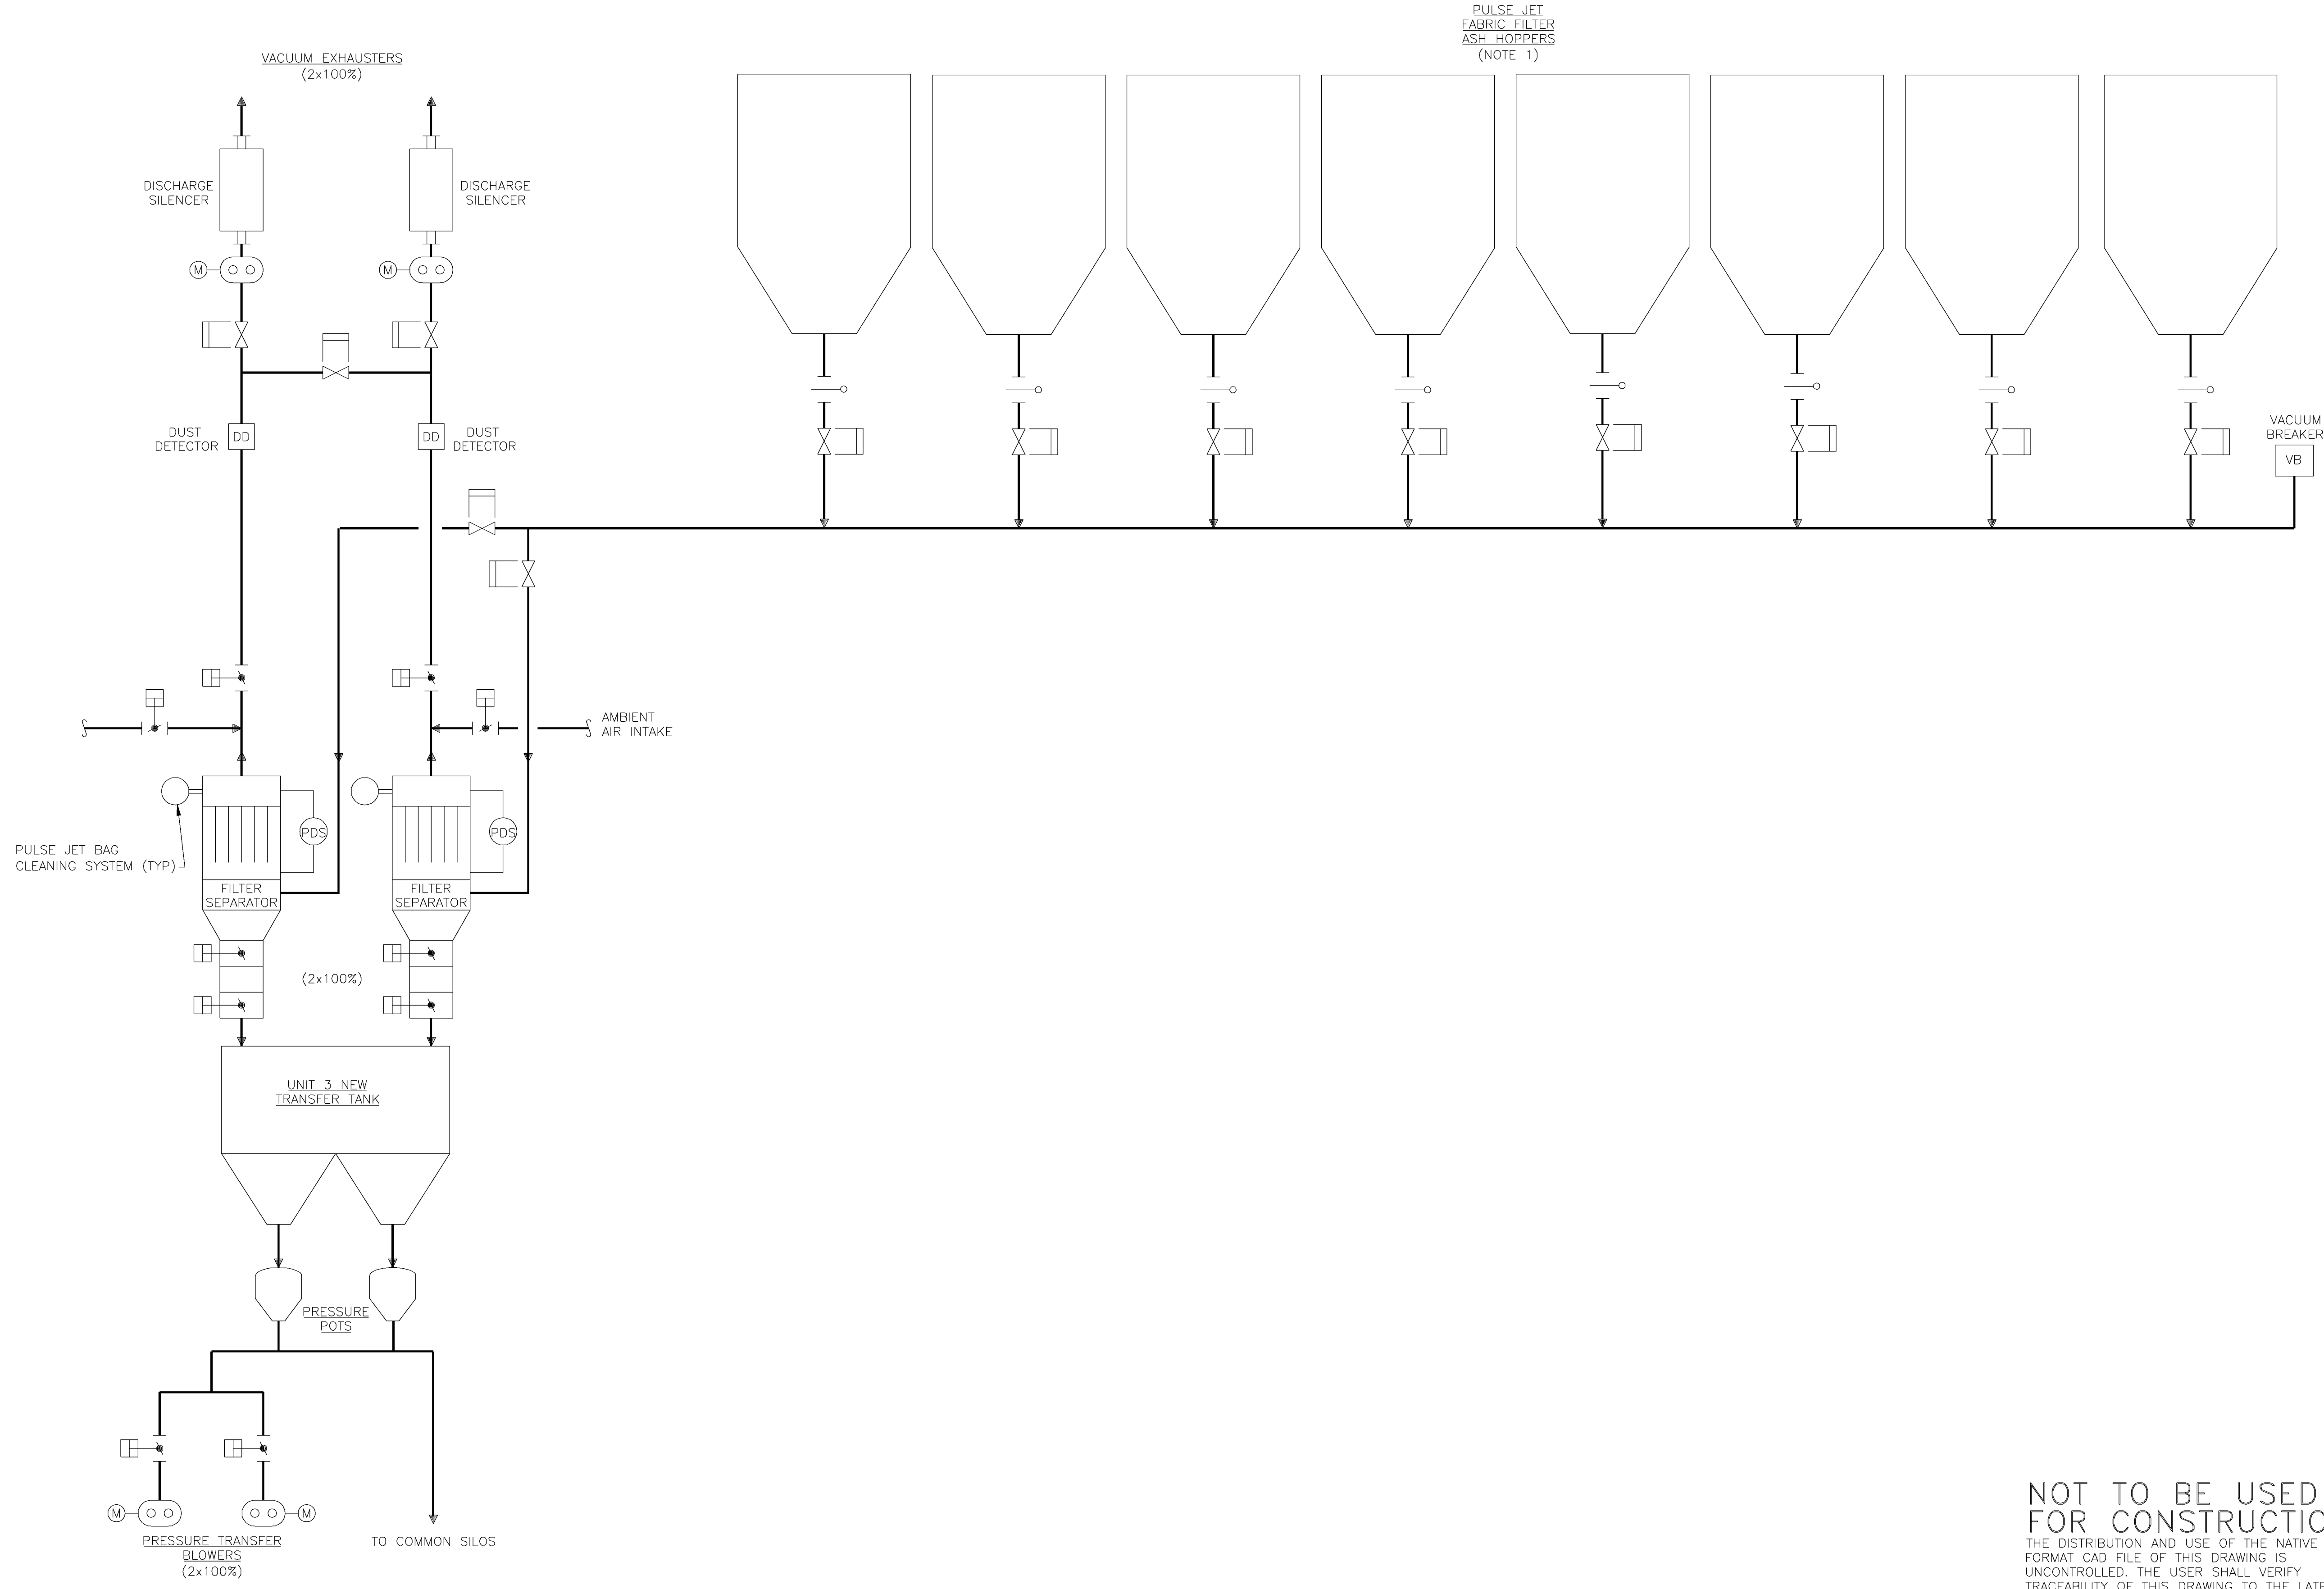

**NOT TO BE USED FOR CONSTRUCTION**  
 THE DISTRIBUTION AND USE OF THE NATIVE FORMAT CAD FILE OF THIS DRAWING IS UNCONTROLLED. THE USER SHALL VERIFY TRACEABILITY OF THIS DRAWING TO THE LATEST CONTROLLED VERSION.

WLS1161 ACAD 16.1s (LMS Tech) 1=1 04/06/11 13:19:04

NO	DATE	REVISIONS AND RECORD OF ISSUE	DRN	DES	CHK	PDE	APP
B	6/APR/11	ISSUED FOR CLIENT REVIEW	PMW	SAT	MRW		
A	16/MAR/11	ISSUED FOR IN HOUSE REVIEW	PRP	SAT	MRW		

**BLACK & VEATCH CORPORATION**

CHECKED: \_\_\_\_\_ DATE: \_\_\_\_\_


DRAWN: PRP

**LG&E/KU - E.W. BROWN STATION**  
 PHASE II: AIR QUALITY CONTROL STUDY

**UNIT 3 PROCESS FLOW DIAGRAM**  
 FLY ASH HANDLING

PROJECT	DRAWING NUMBER	REV
168908-B3ASB-M2022		B
CODE		
AREA		

NOTES:  
 1. SORBENT INJECTION TO BE INSTALLED BY OTHERS PRIOR TO THE START OF THIS PROJECT.

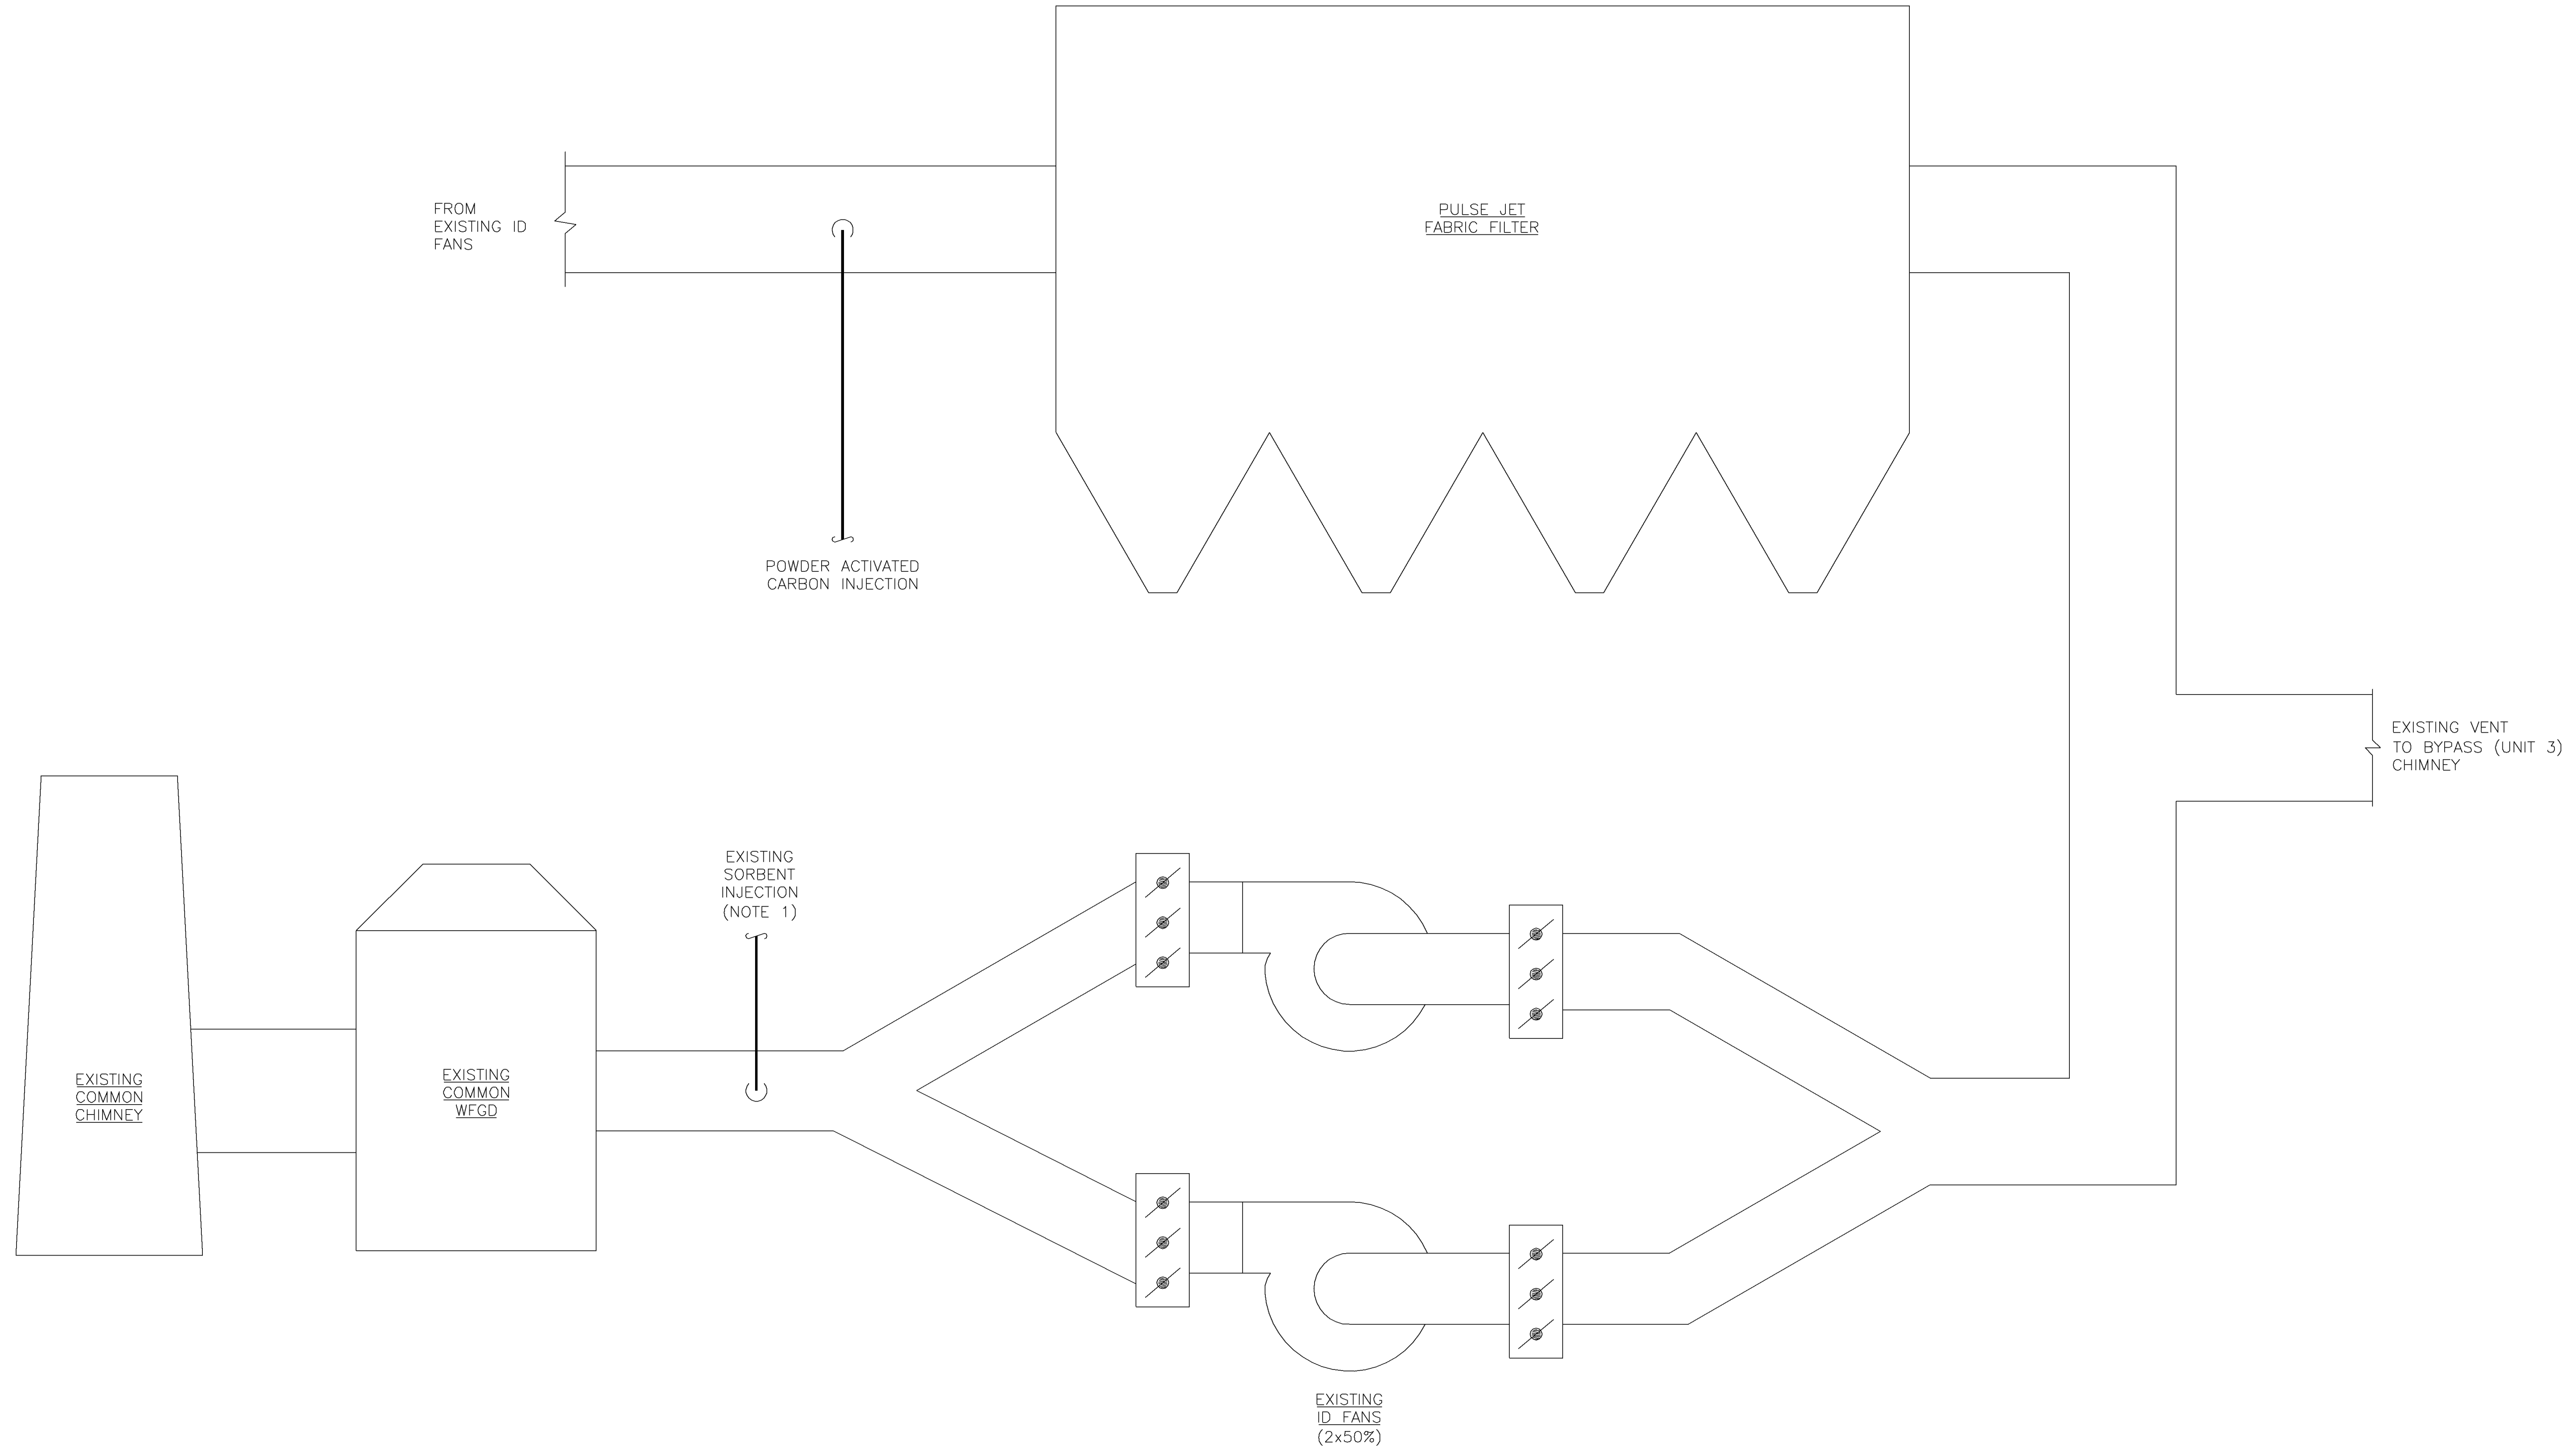

NOT TO BE USED FOR CONSTRUCTION  
 THE DISTRIBUTION AND USE OF THE NATIVE FORMAT CAD FILE OF THIS DRAWING IS UNCONTROLLED. THE USER SHALL VERIFY TRACEABILITY OF THIS DRAWING TO THE LATEST CONTROLLED VERSION.

WLS1161 ACAD 16.1s (LMS Tech) 04/27/11 11:50:27

NO	DATE	REVISIONS AND RECORD OF ISSUE	DRN	DES	CHK	PDE	APP
B	6/APR/11	ISSUED FOR CLIENT REVIEW	PMW	SAT	MRW		
A	16/MAR/11	ISSUED FOR IN HOUSE REVIEW	PRP	SAT	MRW		

**BLACK & VEATCH CORPORATION**

CHECKED: \_\_\_\_\_ DATE: \_\_\_\_\_


DRAWN: PRP

LG&E/KU – E.W. BROWN STATION  
 PHASE II: AIR QUALITY CONTROL STUDY

UNIT 3 PROCESS FLOW DIAGRAM  
 INDUCED DRAFT

PROJECT	DRAWING NUMBER	REV
168908-B3CCE-M2145		B
CODE	AREA	

- NOTES:**
1. EACH COMPARTMENT WILL HAVE MORE THAN ONE PULSE HEADER AND MULTIPLE PULSE VALVES AND PULSE PIPES. ONE SET IS SHOWN FOR CLARITY.
  2. NUMBER OF COMPARTMENTS TO BE CONFIRMED DURING DETAILED DESIGN.

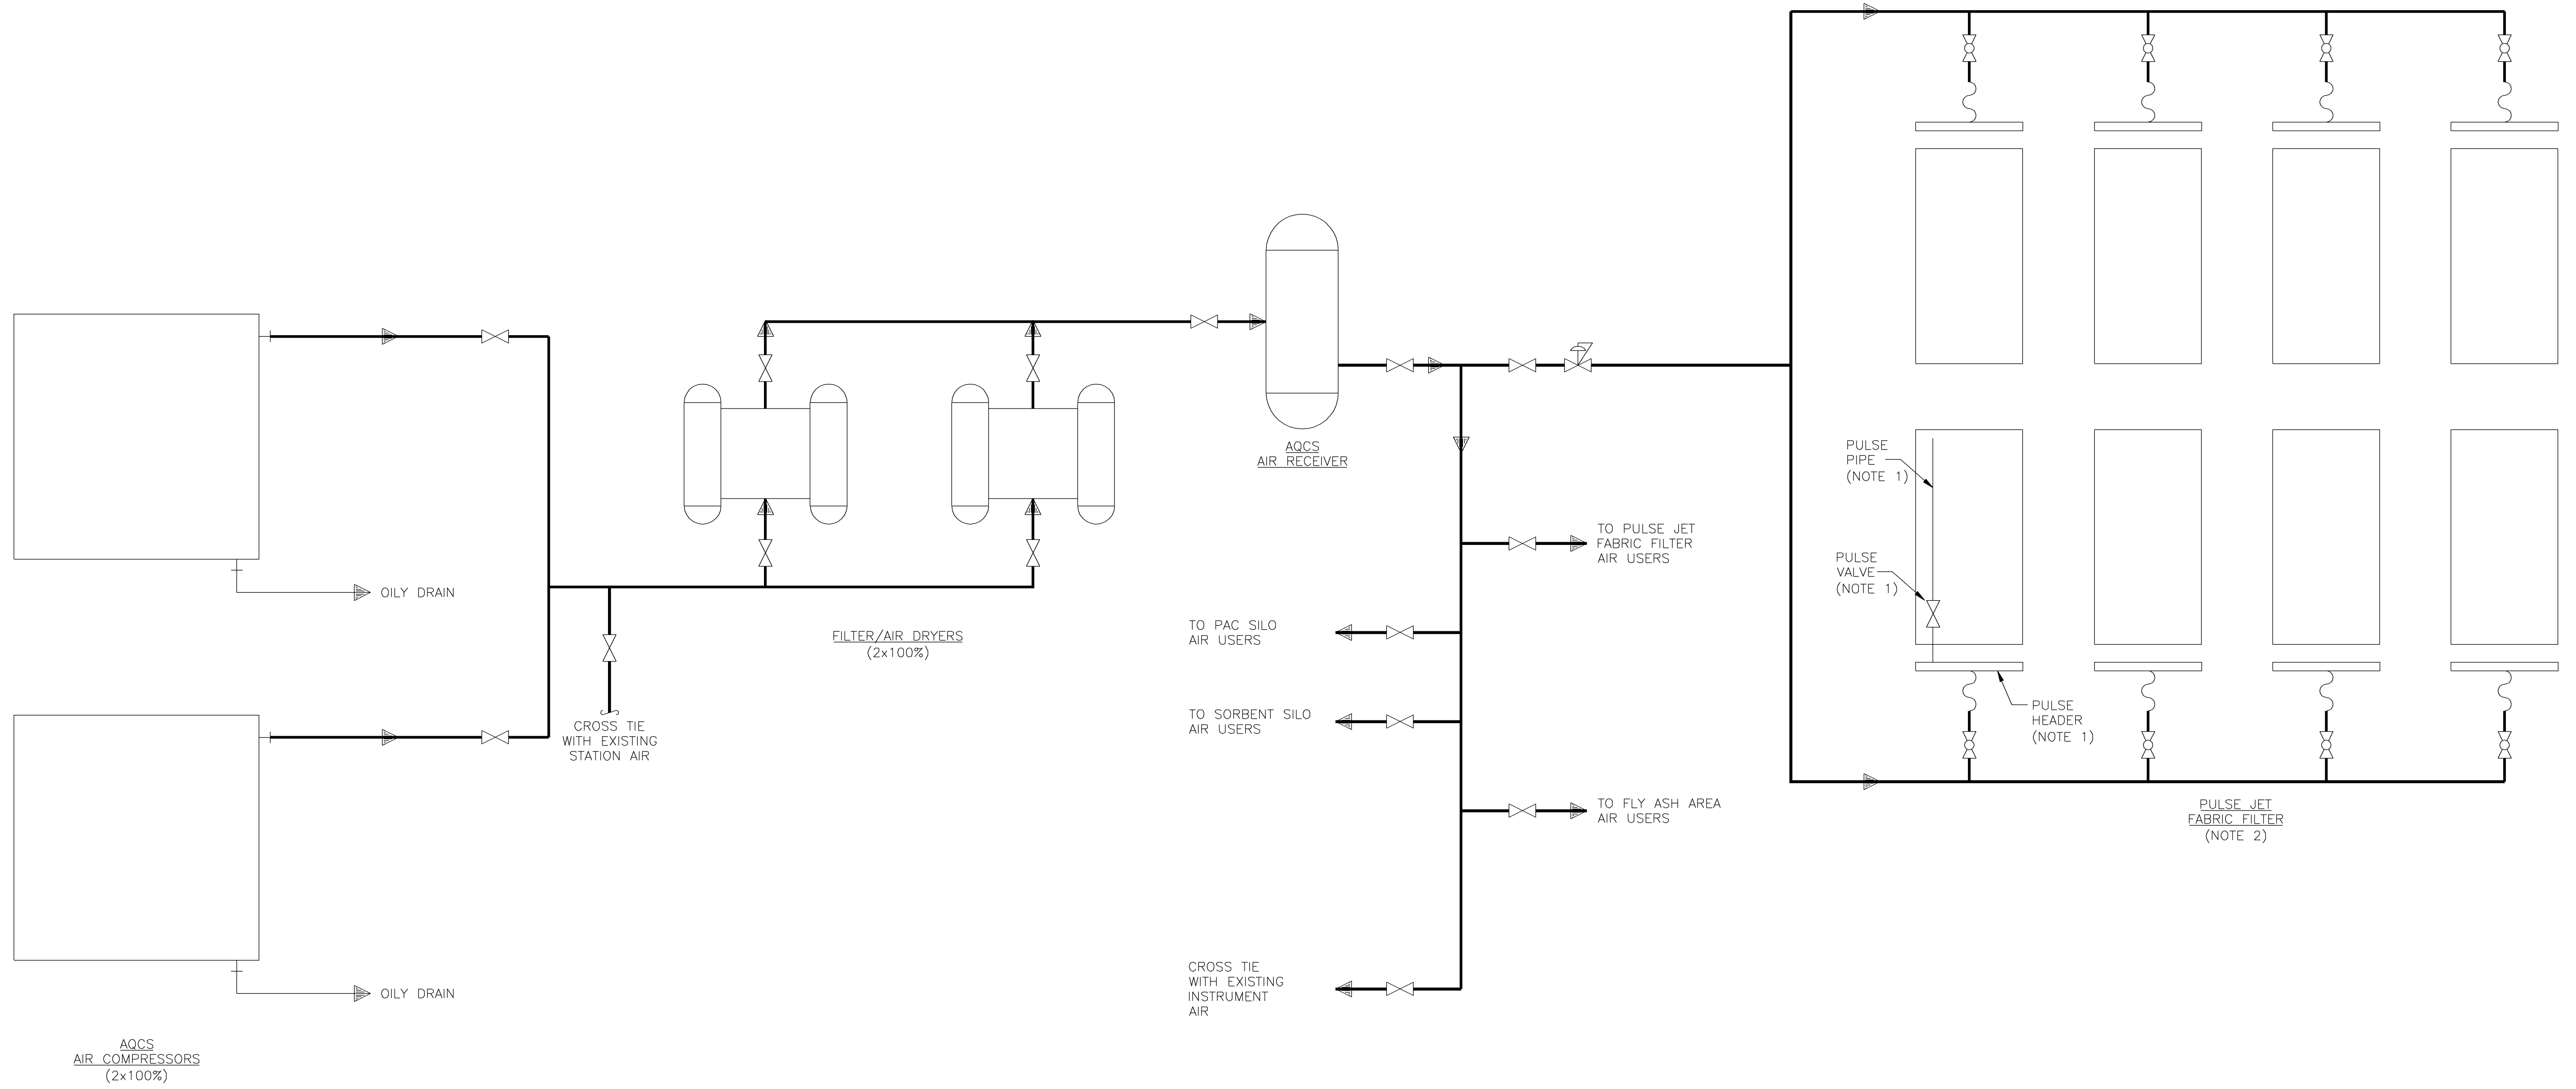

**NOT TO BE USED FOR CONSTRUCTION**  
 THE DISTRIBUTION AND USE OF THE NATIVE FORMAT CAD FILE OF THIS DRAWING IS UNCONTROLLED. THE USER SHALL VERIFY TRACEABILITY OF THIS DRAWING TO THE LATEST CONTROLLED VERSION.

WIL51161 D1 ACAD 16.1s (LMS Tech)  
 AVSLO015 I=1  
 04/06/11 13:32:54

NO	DATE	REVISIONS AND RECORD OF ISSUE	DRN	DES	CHK	PDE	APP
B	6/APR/11	ISSUED FOR CLIENT REVIEW	PMW	SAT			MRW
A	16/MAR/11	ISSUED FOR IN HOUSE REVIEW	PRP	SAT			MRW

**BLACK & VEATCH CORPORATION**

CHECKED: \_\_\_\_\_ DATE: \_\_\_\_\_


DRAWN: PRP

**LG&E/KU - E.W. BROWN STATION**  
**PHASE II: AIR QUALITY CONTROL STUDY**

UNIT 3 PROCESS FLOW DIAGRAM  
 AQCS COMPRESSED AIR

PROJECT	DRAWING NUMBER	REV
168908-B3CAB-M2182		B
CODE	AREA	

A  
B  
C  
D  
E  
F

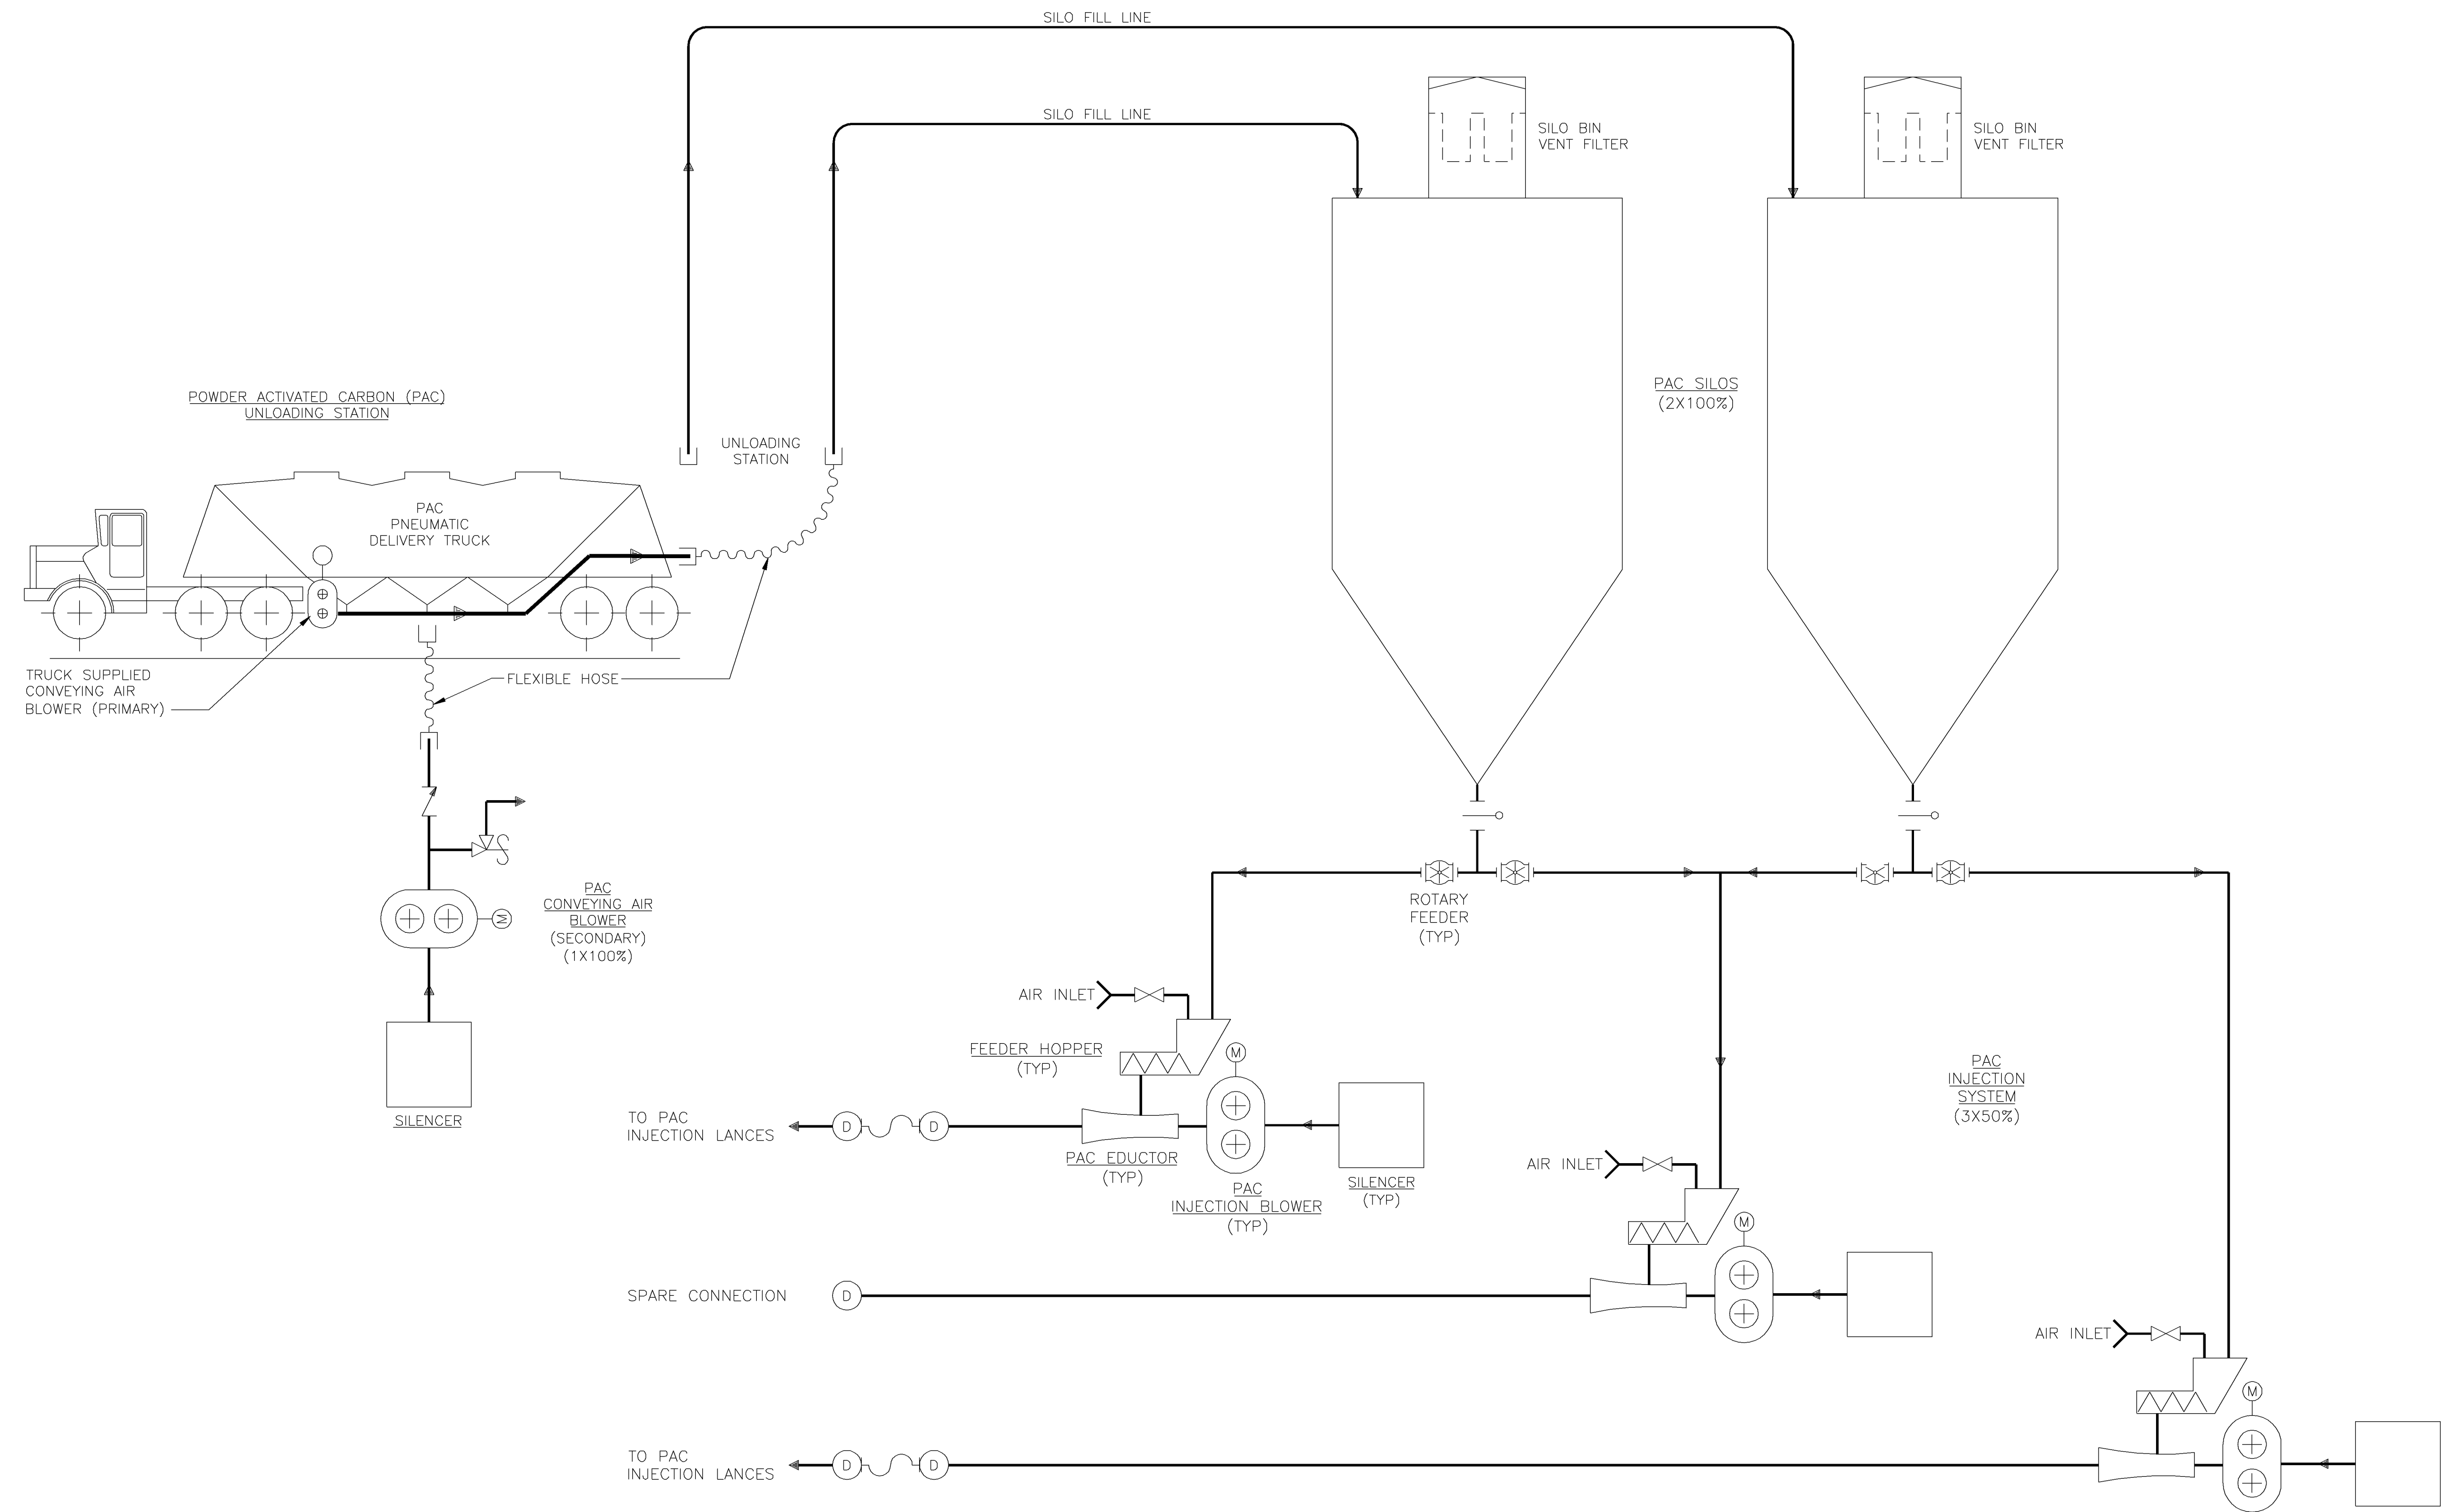

**NOT TO BE USED FOR CONSTRUCTION**  
 THE DISTRIBUTION AND USE OF THE NATIVE FORMAT CAD FILE OF THIS DRAWING IS UNCONTROLLED. THE USER SHALL VERIFY TRACEABILITY OF THIS DRAWING TO THE LATEST CONTROLLED VERSION.

WIL51161 ACAD 16.1s (LMS Tech)  
 04/06/11 13:31:21

NO	DATE	REVISIONS AND RECORD OF ISSUE	DRN	DES	CHK	PDE	APP
B	6/APR/11	ISSUED FOR CLIENT REVIEW	PMW	SAT	MRW		
A	16/MAR/11	ISSUED FOR IN HOUSE REVIEW	PRP	SAT	MRW		

**BLACK & VEATCH CORPORATION**

DRAWN: HWB  
 CHECKED: \_\_\_\_\_  
 DATE: \_\_\_\_\_

**LG&E/KU - E.W. BROWN STATION**  
 PHASE II: AIR QUALITY CONTROL STUDY

**UNIT 3 PROCESS FLOW DIAGRAM**  
 POWDER ACTIVATED CARBON INJECTION

PROJECT	DRAWING NUMBER	REV
168908-B3CCH-M2148A		B
CODE	AREA	