


REVISIONS

Project: MC_SETUP
Scanned Drawing and
set in DWG database
and picked up field
revisions.
Date: 04/11/20
Drawn: Steve Wilcox
App'd: Charles Jacobs

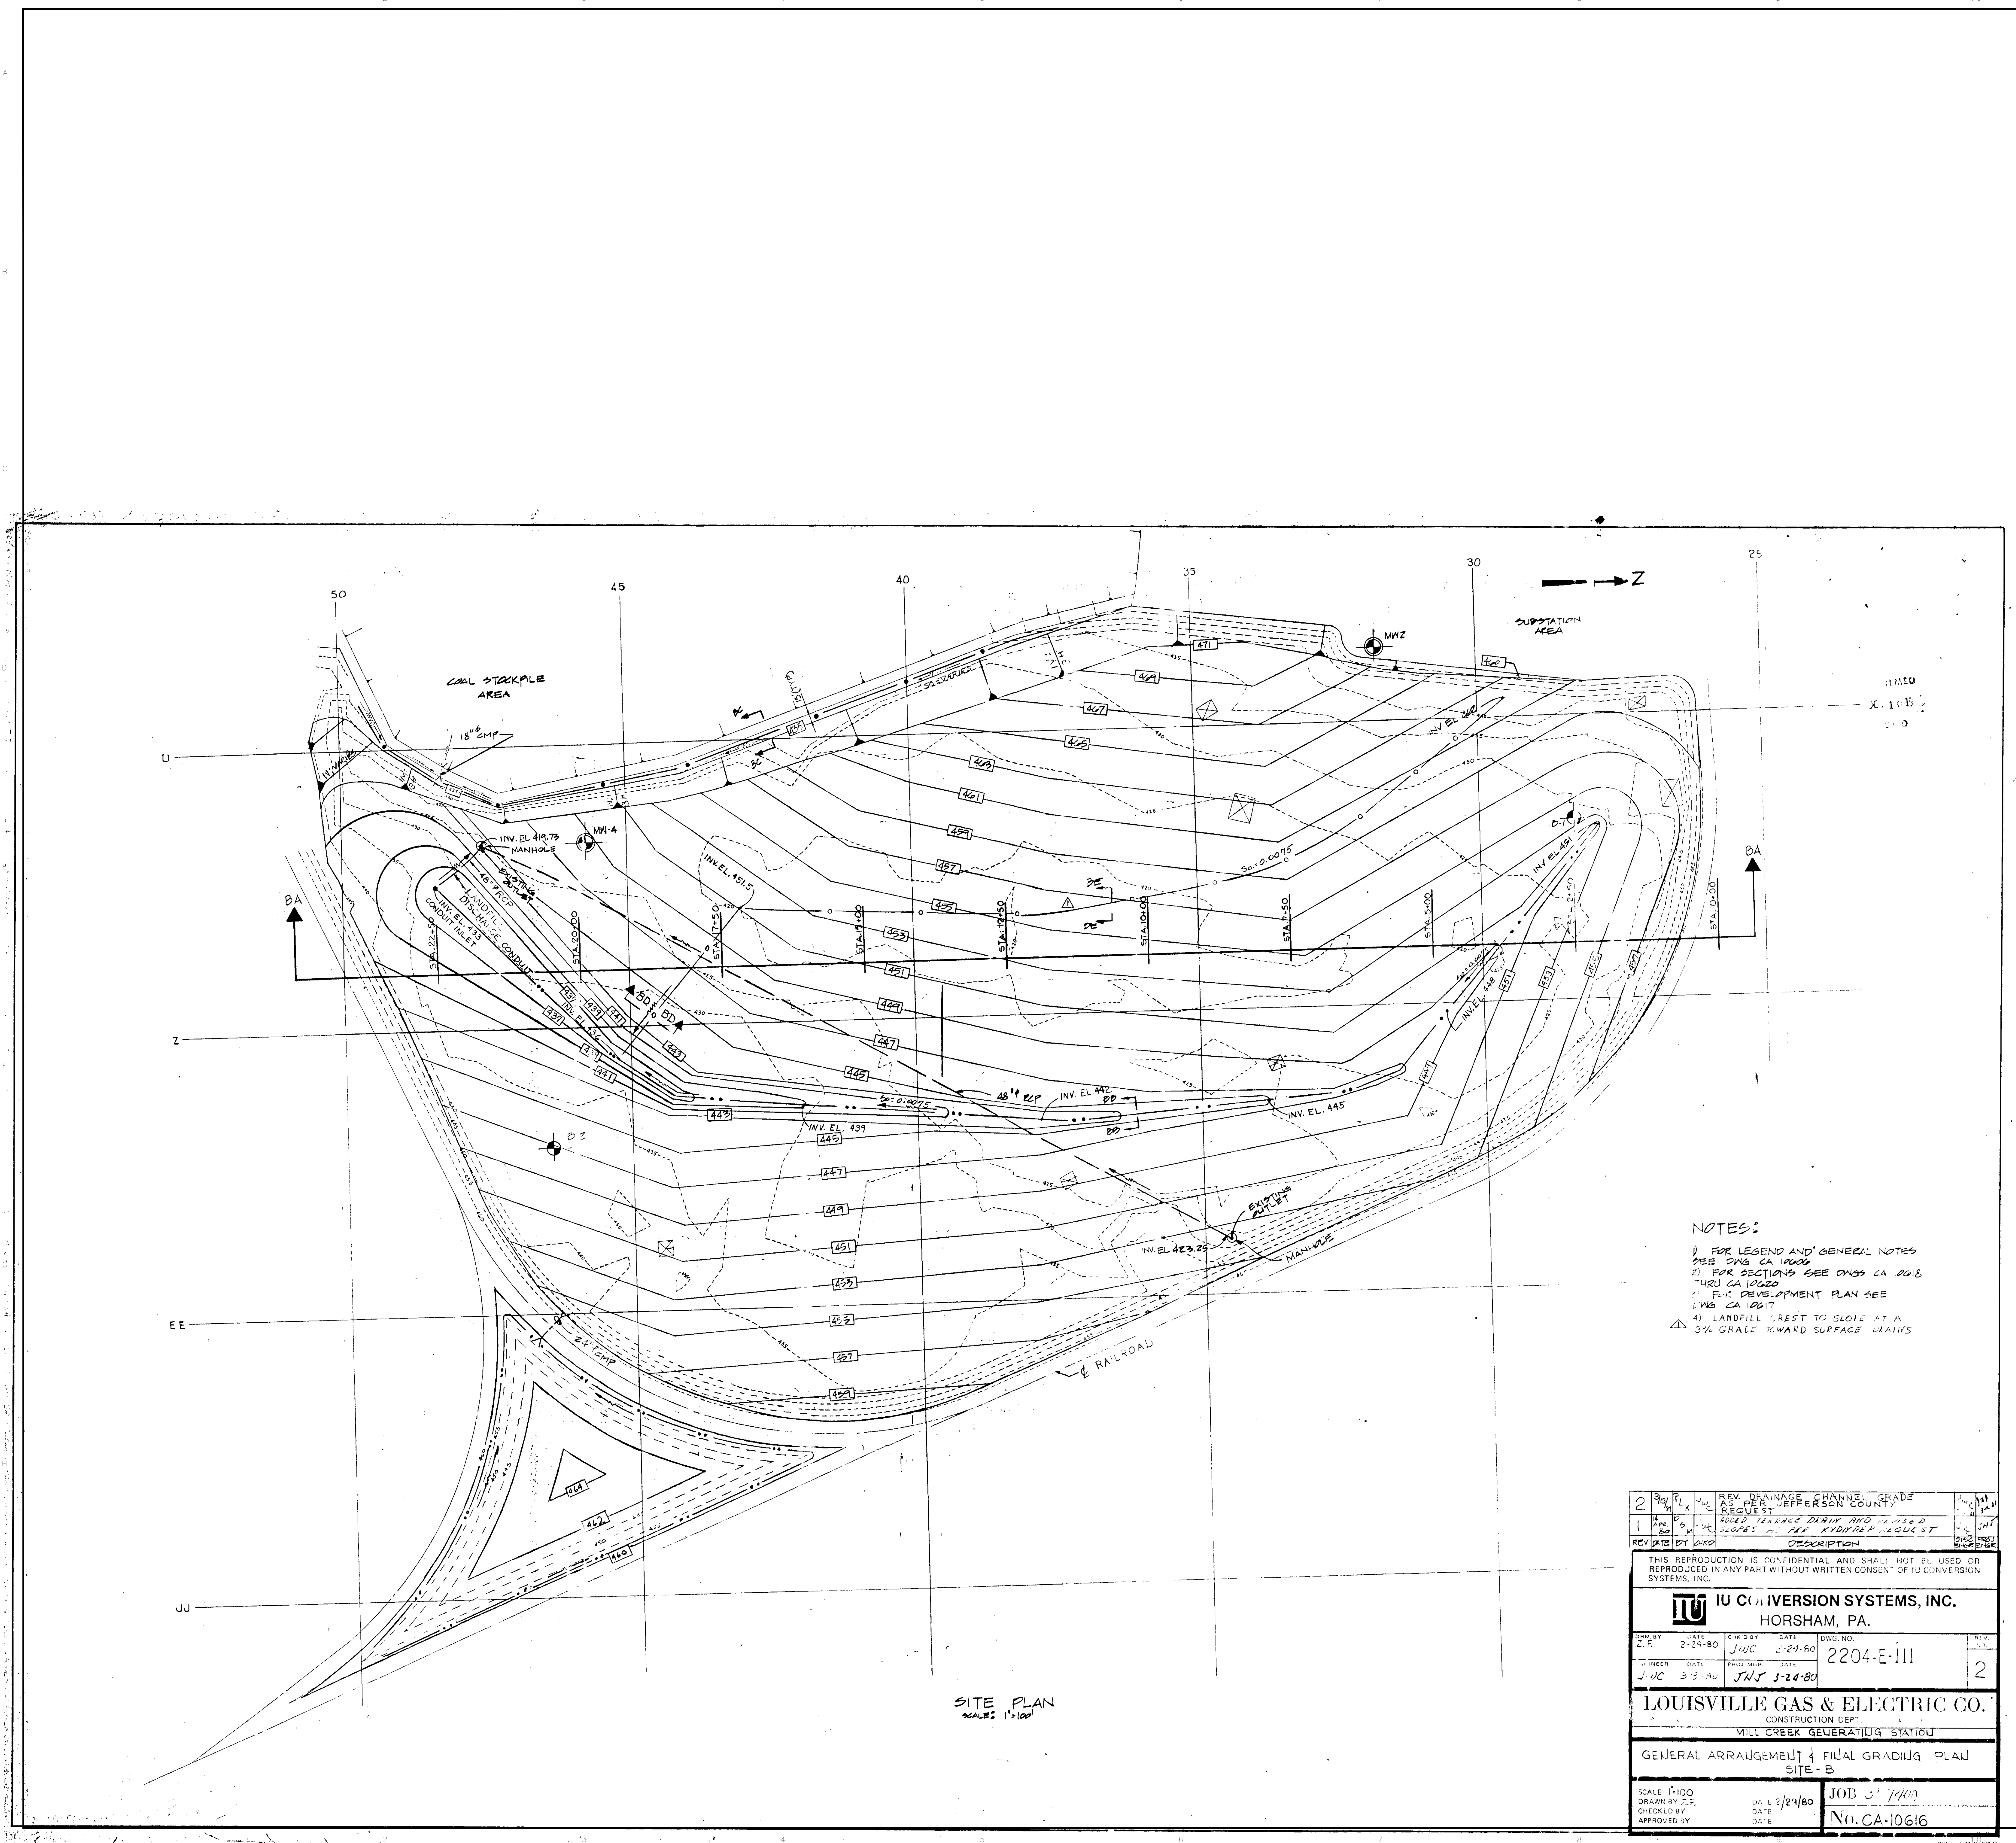

NOTES:
1) FOR LEGEND AND GENERAL NOTES
SEE DWG CA 1000
2) FOR SECTIONS SEE DWG CA 1008
THRU CA 1020
3) T.M. DEVELOPMENT PLAN SEE
DWG CA 1007
4) LANDFILL CREST TO SLOPE AT A
3% GRADE TOWARD SURFACE DRAINS

SITE PLAN
SCALE: 1"=100'

NO.	DATE	BY	DESCRIPTION
2	3/1/20	JWC	REV. DRAINAGE CHANNEL GRADE AS PER JEFFERSON COUNTY REQUEST
1	2/24/20	JWC	FIELD VISUAL DATA AND REVISED SLOPES AS PER KYDRAH REQUEST

THIS REPRODUCTION IS CONFIDENTIAL AND SHALL NOT BE USED OR REPRODUCED IN ANY PART WITHOUT WRITTEN CONSENT OF IU CONVERSION SYSTEMS, INC.

IU CONVERSION SYSTEMS, INC.
HORSHAM, PA.

DATE: 2-24-20
DRAWN BY: JWC
CHECKED BY: JWC

DATE: 2-24-20
DATE: 3-24-20

DWG. NO.: 2204-E-111

2

LOUISVILLE GAS & ELECTRIC CO.
CONSTRUCTION DEPT.
MILL CREEK GENERATING STATION


GENERAL ARRANGEMENT & FINAL GRADING PLAN - SITE B

SCALE: 1"=100'
DATE: 2/24/20
JOB NO.: 31-7400
NO. CA-10616

Mill Creek Common	Central Engineering & Construction Management Department	Floor Engineers Inc.
Scale: 1"=100'	Project: MILL CREEK GENERATING STATION	Project: MILL CREEK GENERATING STATION
Civil	Site Imp.	Site Imp.
GENERAL ARRANGEMENT & FINAL GRADING PLAN - SITE B		
IU CONVERSION	31-7400	CA-10616 B

REVISIONS

Project: MC_SETUP
Scanned Drawing and
set in DWG database
and picked up field
revisions.
Dwn: Roy Miller
Dwd: Dave Wilson
App: Charles Jacobs

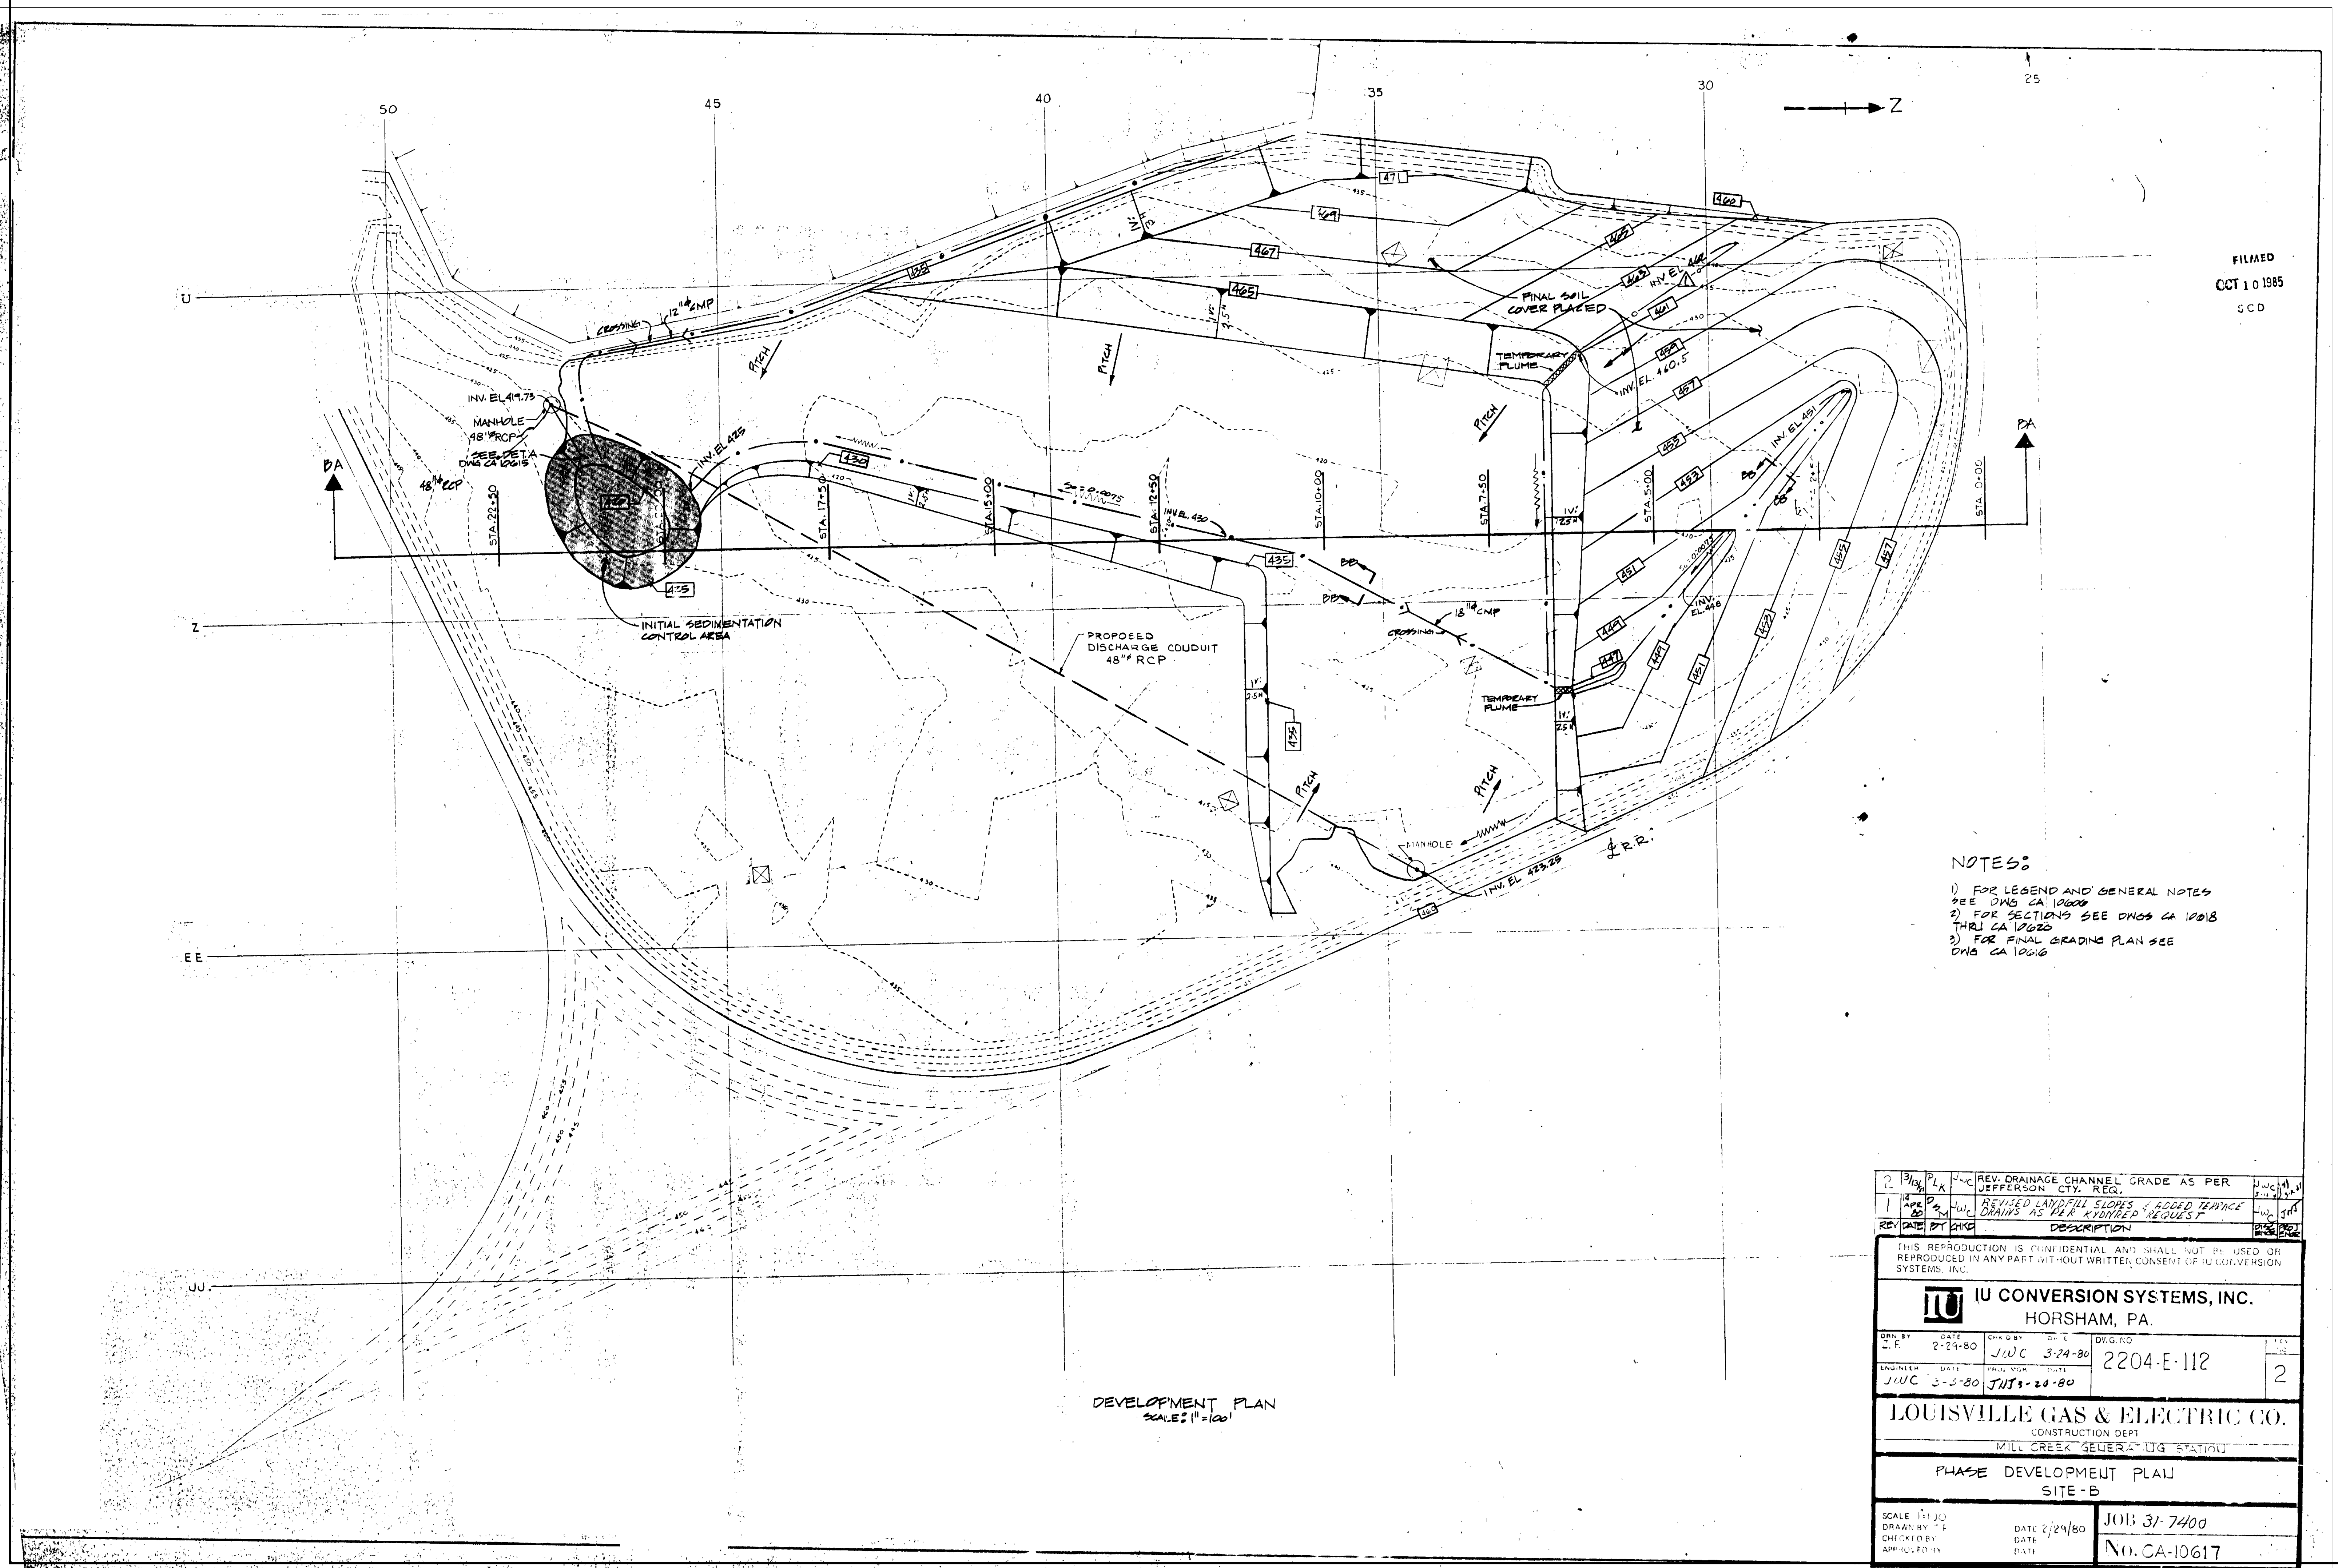

FILED
CCT 10 1985
SCD

- NOTES:
- 1) FOR LEGEND AND GENERAL NOTES SEE DMS CA 10000
 - 2) FOR SECTIONS SEE DMS CA 10018 THRU CA 10020
 - 3) FOR FINAL GRADING PLAN SEE DMS CA 10016

DEVELOPMENT PLAN
SCALE: 1"=100'

REV	DATE	BY	DESCRIPTION
1	2-24-80	JWC	REVISED DRAINAGE CHANNEL GRADE AS PER DEFFERSON CTRY. REG.
2	3-24-80	JWC	REVISED LANDFILL SLOPES & ADDED TRENCH DRAINS AS PER FIDELER REQUEST

THIS REPRODUCTION IS CONFIDENTIAL AND SHALL NOT BE USED OR REPRODUCED IN ANY PART WITHOUT WRITTEN CONSENT OF IU CONVERSION SYSTEMS, INC.

IU CONVERSION SYSTEMS, INC. HORSHAM, PA.	
DATE: 2-24-80	DATE: 3-24-80
ENGINEER: JWC	DATE: 3-24-80
PROJECT NO: 2204-E-112	SHEET NO: 2
LOUISVILLE GAS & ELECTRIC CO. CONSTRUCTION DEPT. MILL CREEK SEWER TREATMENT PLANT	
PHASE DEVELOPMENT PLAN SITE-B	
SCALE: 1"=100'	DATE: 2/24/80
DRAWN BY: JWC	DATE: 2/24/80
CHECKED BY: JWC	DATE: 2/24/80
PROJECT NO: 2204-E-112	JOB NO: 31-7400
DRAWING NO: CA-10617	

Project No: 31-7400	Contract No: 2204-E-112	Sheet No: 2
LOUISVILLE GAS & ELECTRIC COMPANY A DIVISION OF SPAN ENERGY		
PHASE DEVELOPMENT PLAN SITE B		
Company: IU CONVERSION	Project No: 31-7400	Drawing No: CA-10617

B CA-10618 00400 31-7400



REVISIONS

Project: MC_SETUP
Scanned Drawing and
set in DWG database
and picked up field
revisions.
Dwn: Ray Miller
Dwd: Dave Wilms
App: Charles Jacobs


DWG. NO.	TITLE

REV.	DATE	BY	CHKD	DESCRIPTION
1	1/15/80	JWC	JWC	ENGR. PROJ. ENGR.
2	3/17/80	JWC	JWC	ADD. GROUND DATA AND TERRACE DRAIN AND REVISIONS REQUEST.
3	3/17/80	JWC	JWC	REV. DRAINAGE CHANNEL GRADE AS PER JEFFERSON CITY REG.


FILMED
OCT 10 1985
SCD

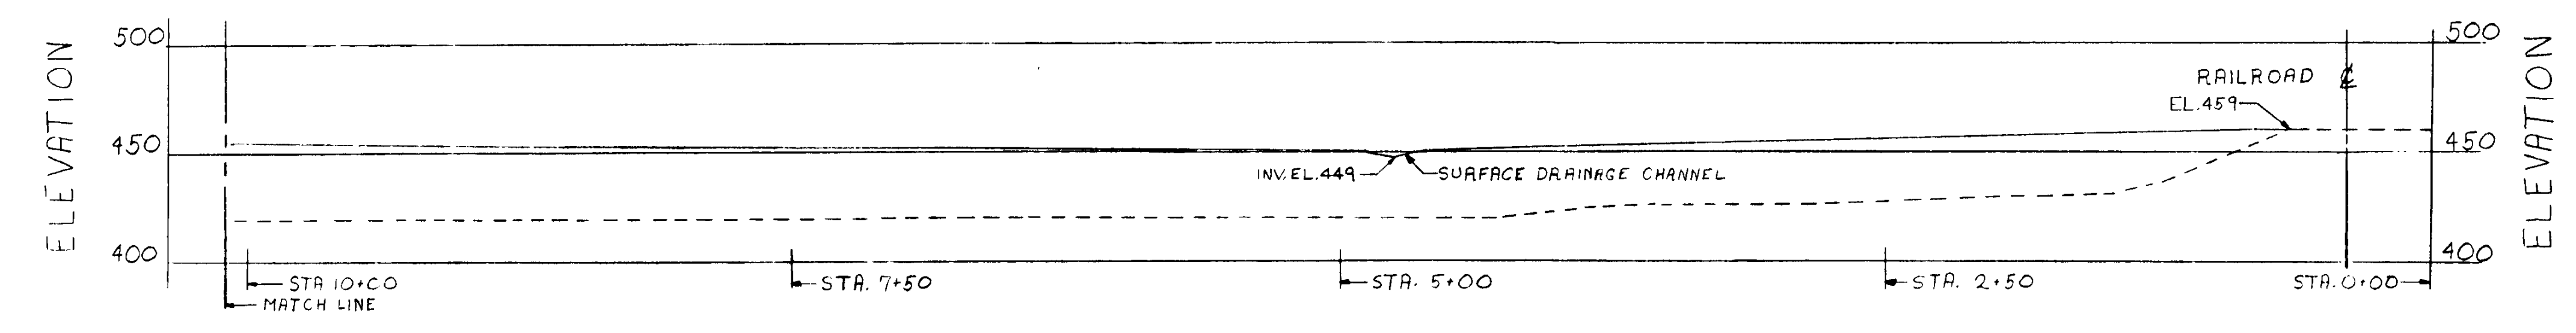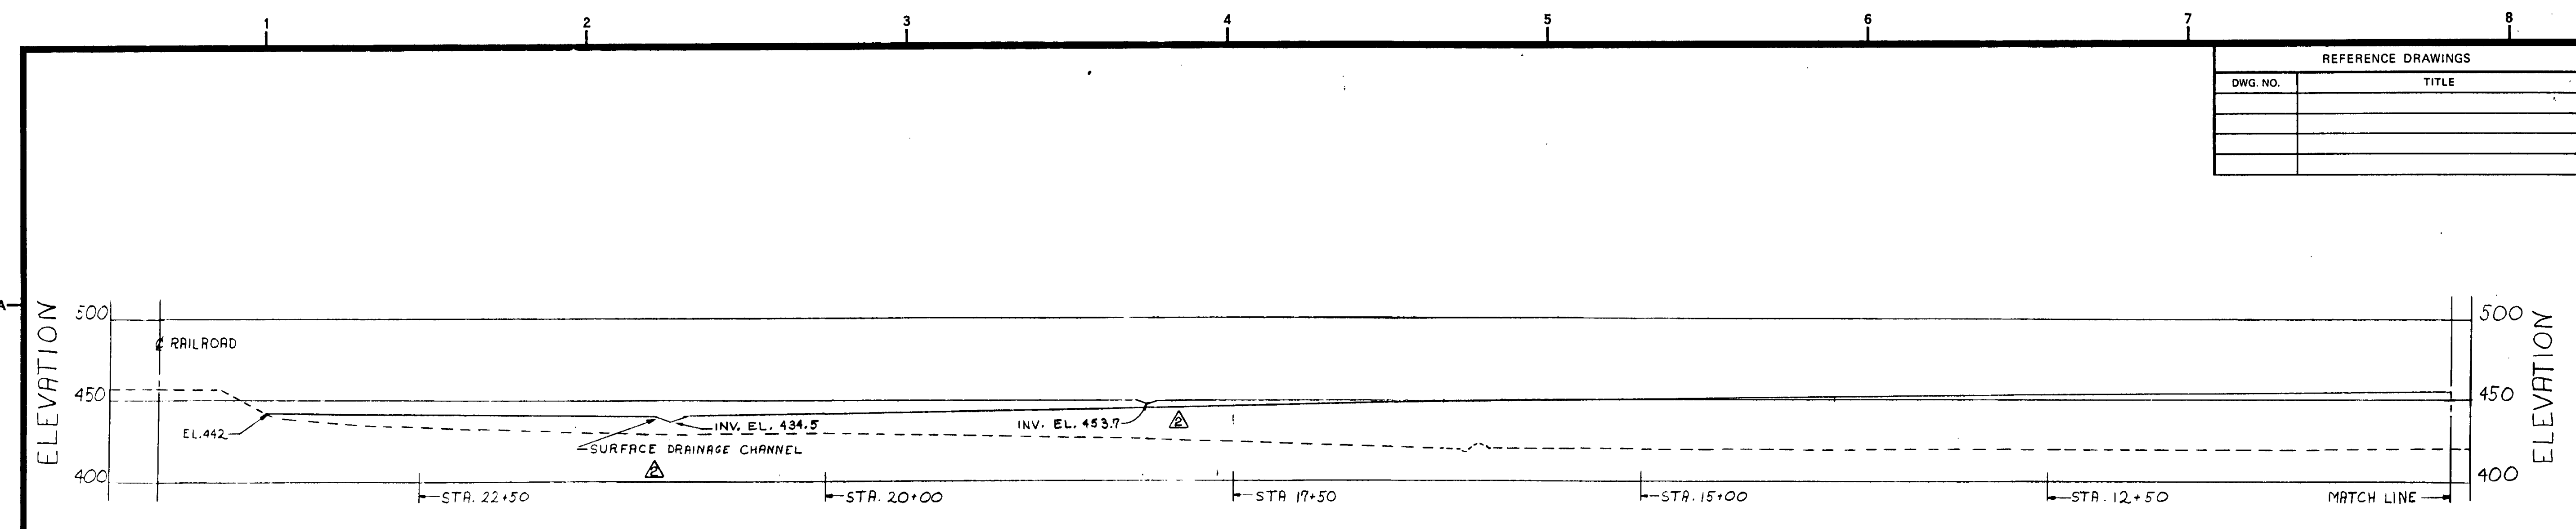


SECTION BA-BA
SCALE: 1" = 50'

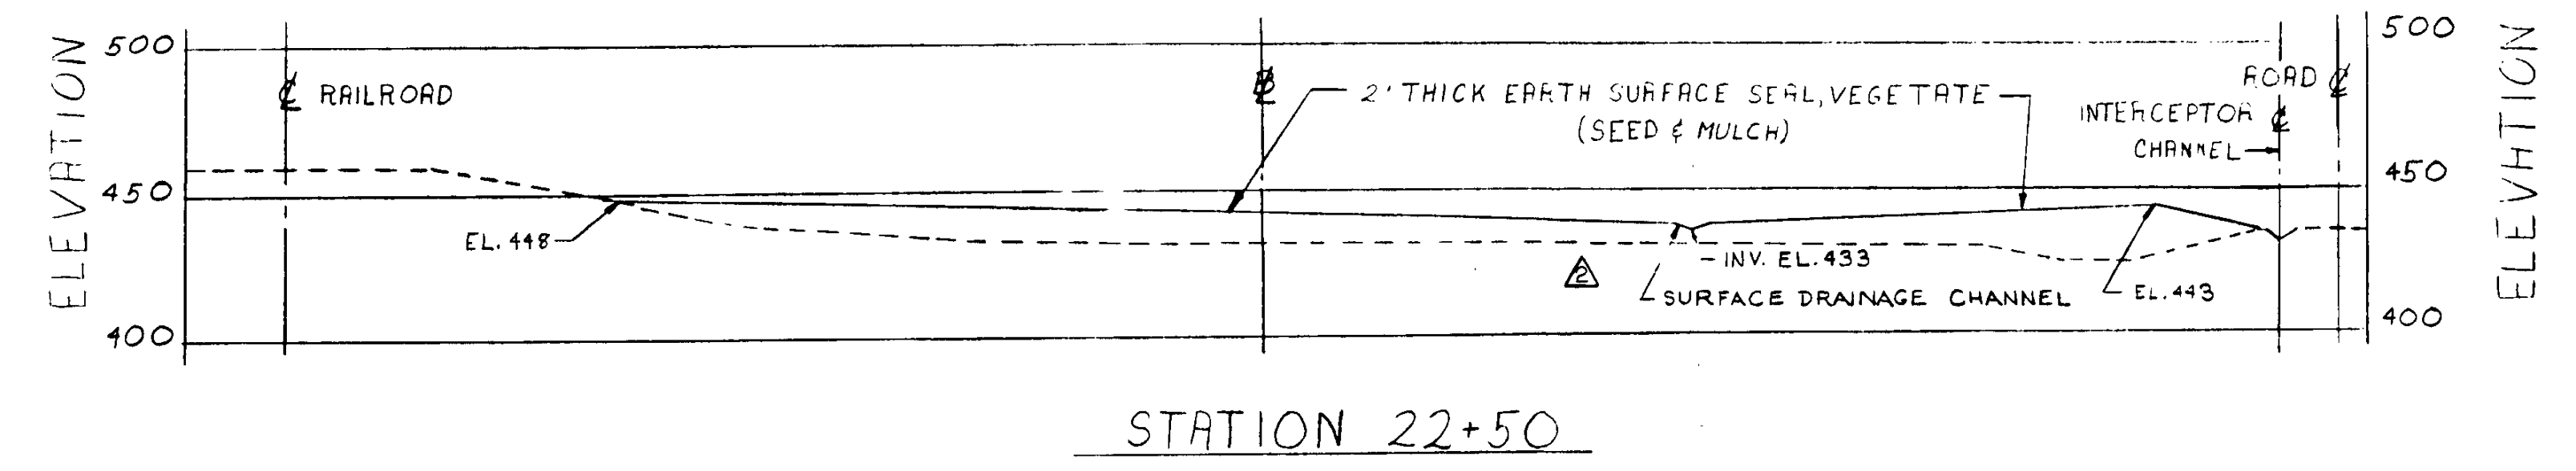


STATION 22+50

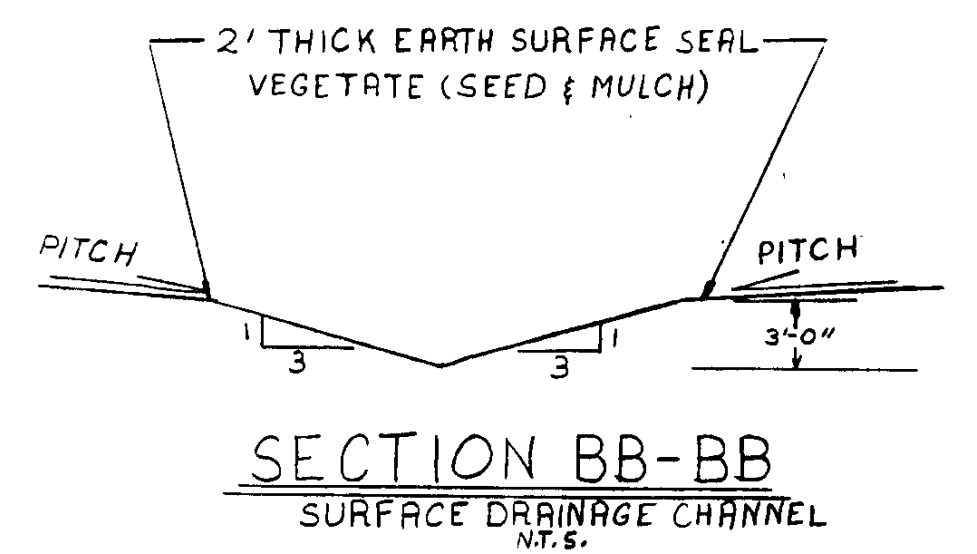

SECTION BB-BB
SURFACE DRAINAGE CHANNEL
N.T.S.

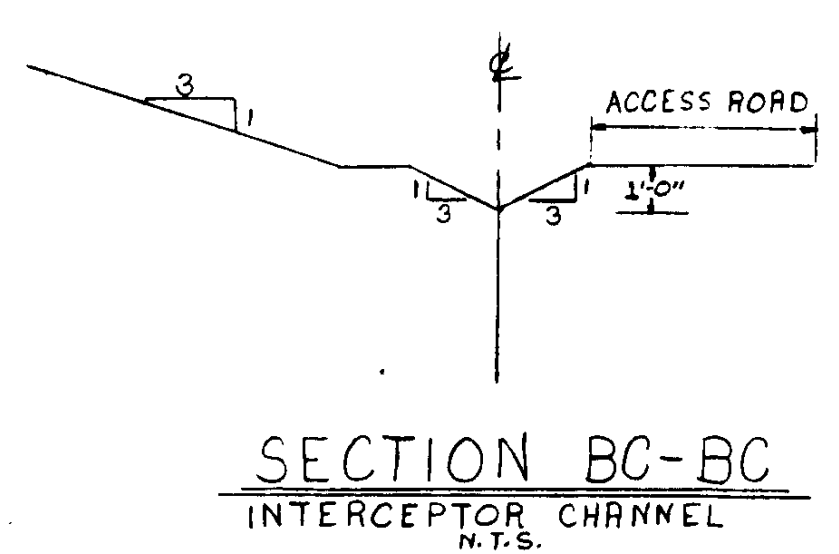


SECTION BC-BC
INTERCEPTOR CHANNEL
N.T.S.

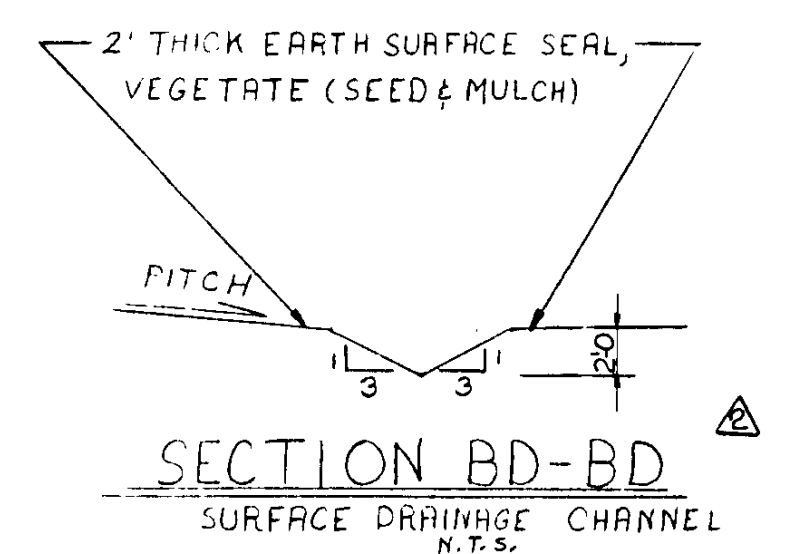

SECTION BD-BD
SURFACE DRAINAGE CHANNEL
N.T.S.

- NOTES:
- FOR LEGEND AND GENERAL NOTES SEE DWG. CRI0604.
 - FOR SECTION LOCATIONS SEE DWG. CRI0214. STATION MARKS DESIGNATE SECTIONS.
 - FOR LANDFILL CHEST GRADES SEE DWG. CRI0216.

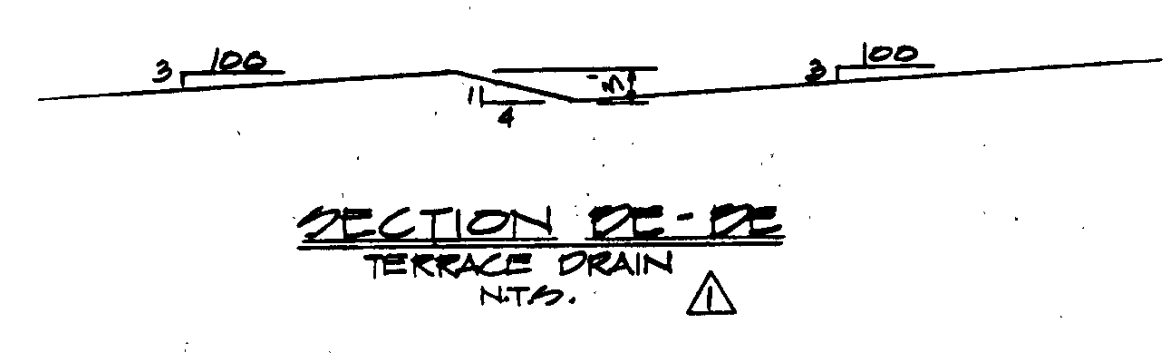

SECTION CE-CE
TERRACE DRAIN
N.T.S.

THIS REPRODUCTION IS CONFIDENTIAL AND SHALL NOT BE USED OR REPRODUCED IN ANY PART WITHOUT WRITTEN CONSENT OF IU CONVERSION SYSTEMS, INC.

IU CONVERSION SYSTEMS, INC.
HORSHAM, PA.

DRN. BY	DATE	CHK'D BY	DATE	DWG. NO.	REV. NO.
PLK	3-17-80	JWC	3-24-80	2204-E-113	2
ENGINEER	DATE	PROJ. MGR.	DATE		
JWC	3-17-80	JWC	3-24-80		

LOUISVILLE GAS & ELECTRIC CO.
CONSTRUCTION DEPT.
MILL CREEK GENERATING STATION

CROSS SECTIONS - SITE "B"

SCALE 1" = 50'	DATE	JOB 31-7400
DRAWN BY	DATE	No. CA10618
CHECKED BY	DATE	
APPROVED BY	DATE	

Project: Mill Creek Common	Contract No.	Central Engineering & Construction Management Department	From: Floor Engineers Inc.
Scale: 1" = 50'	Project Type: Civil	Client: LOUISVILLE GAS & ELECTRIC COMPANY	From: Floor Engineers Inc.
Site Imp.	Contract No.:	Contract No.:	From: Floor Engineers Inc.
			03/17/80
			2204-E-113
Project: IU CONVERSION	Job No: 31-7400	Drawing No: CA-10618	Sheet: B

REVISIONS

Project: MC_SETUP
Scanned Drawing and
set up in DWG database
and picked up field
revisions.
Dwn: Ray Miller
Dwg: Dave Wilms
App: Charles Jacobs

DWG. NO.	TITLE	REV.	DATE	BY	CHKD
		1	7/20	JWC	JWC
		2	7/20	JWC	JWC

REV.	DATE	BY	CHKD
1	7/20	JWC	JWC
2	7/20	JWC	JWC

FILMED
OCT 10 1985
SCD

THIS REPRODUCTION IS CONFIDENTIAL AND SHALL NOT BE USED OR REPRODUCED IN ANY PART WITHOUT WRITTEN CONSENT OF IU CONVERSION SYSTEMS, INC.

IU CONVERSION SYSTEMS, INC.
HORSHAM, PA.


DWG. BY	DATE	CHKD. BY	DATE	DWG. NO.	REV. NO.
JWC	3-3-80	JWC	3-29-80	2204-E-114	2
ENGINEER	DATE	PROJ. MGR.	DATE		
JWC	3-9-80	JWC	3-24-80		

LOUISVILLE GAS & ELECTRIC CO.
CONSTRUCTION DEPT.
MILL CREEK GENERATING STATION

CROSS SECTIONS SITE "B"

SCALE	1" = 20'
DRAWN BY	DATE
CHECKED BY	DATE
APPROVED BY	DATE

JOB 37-7490
No. CA10619

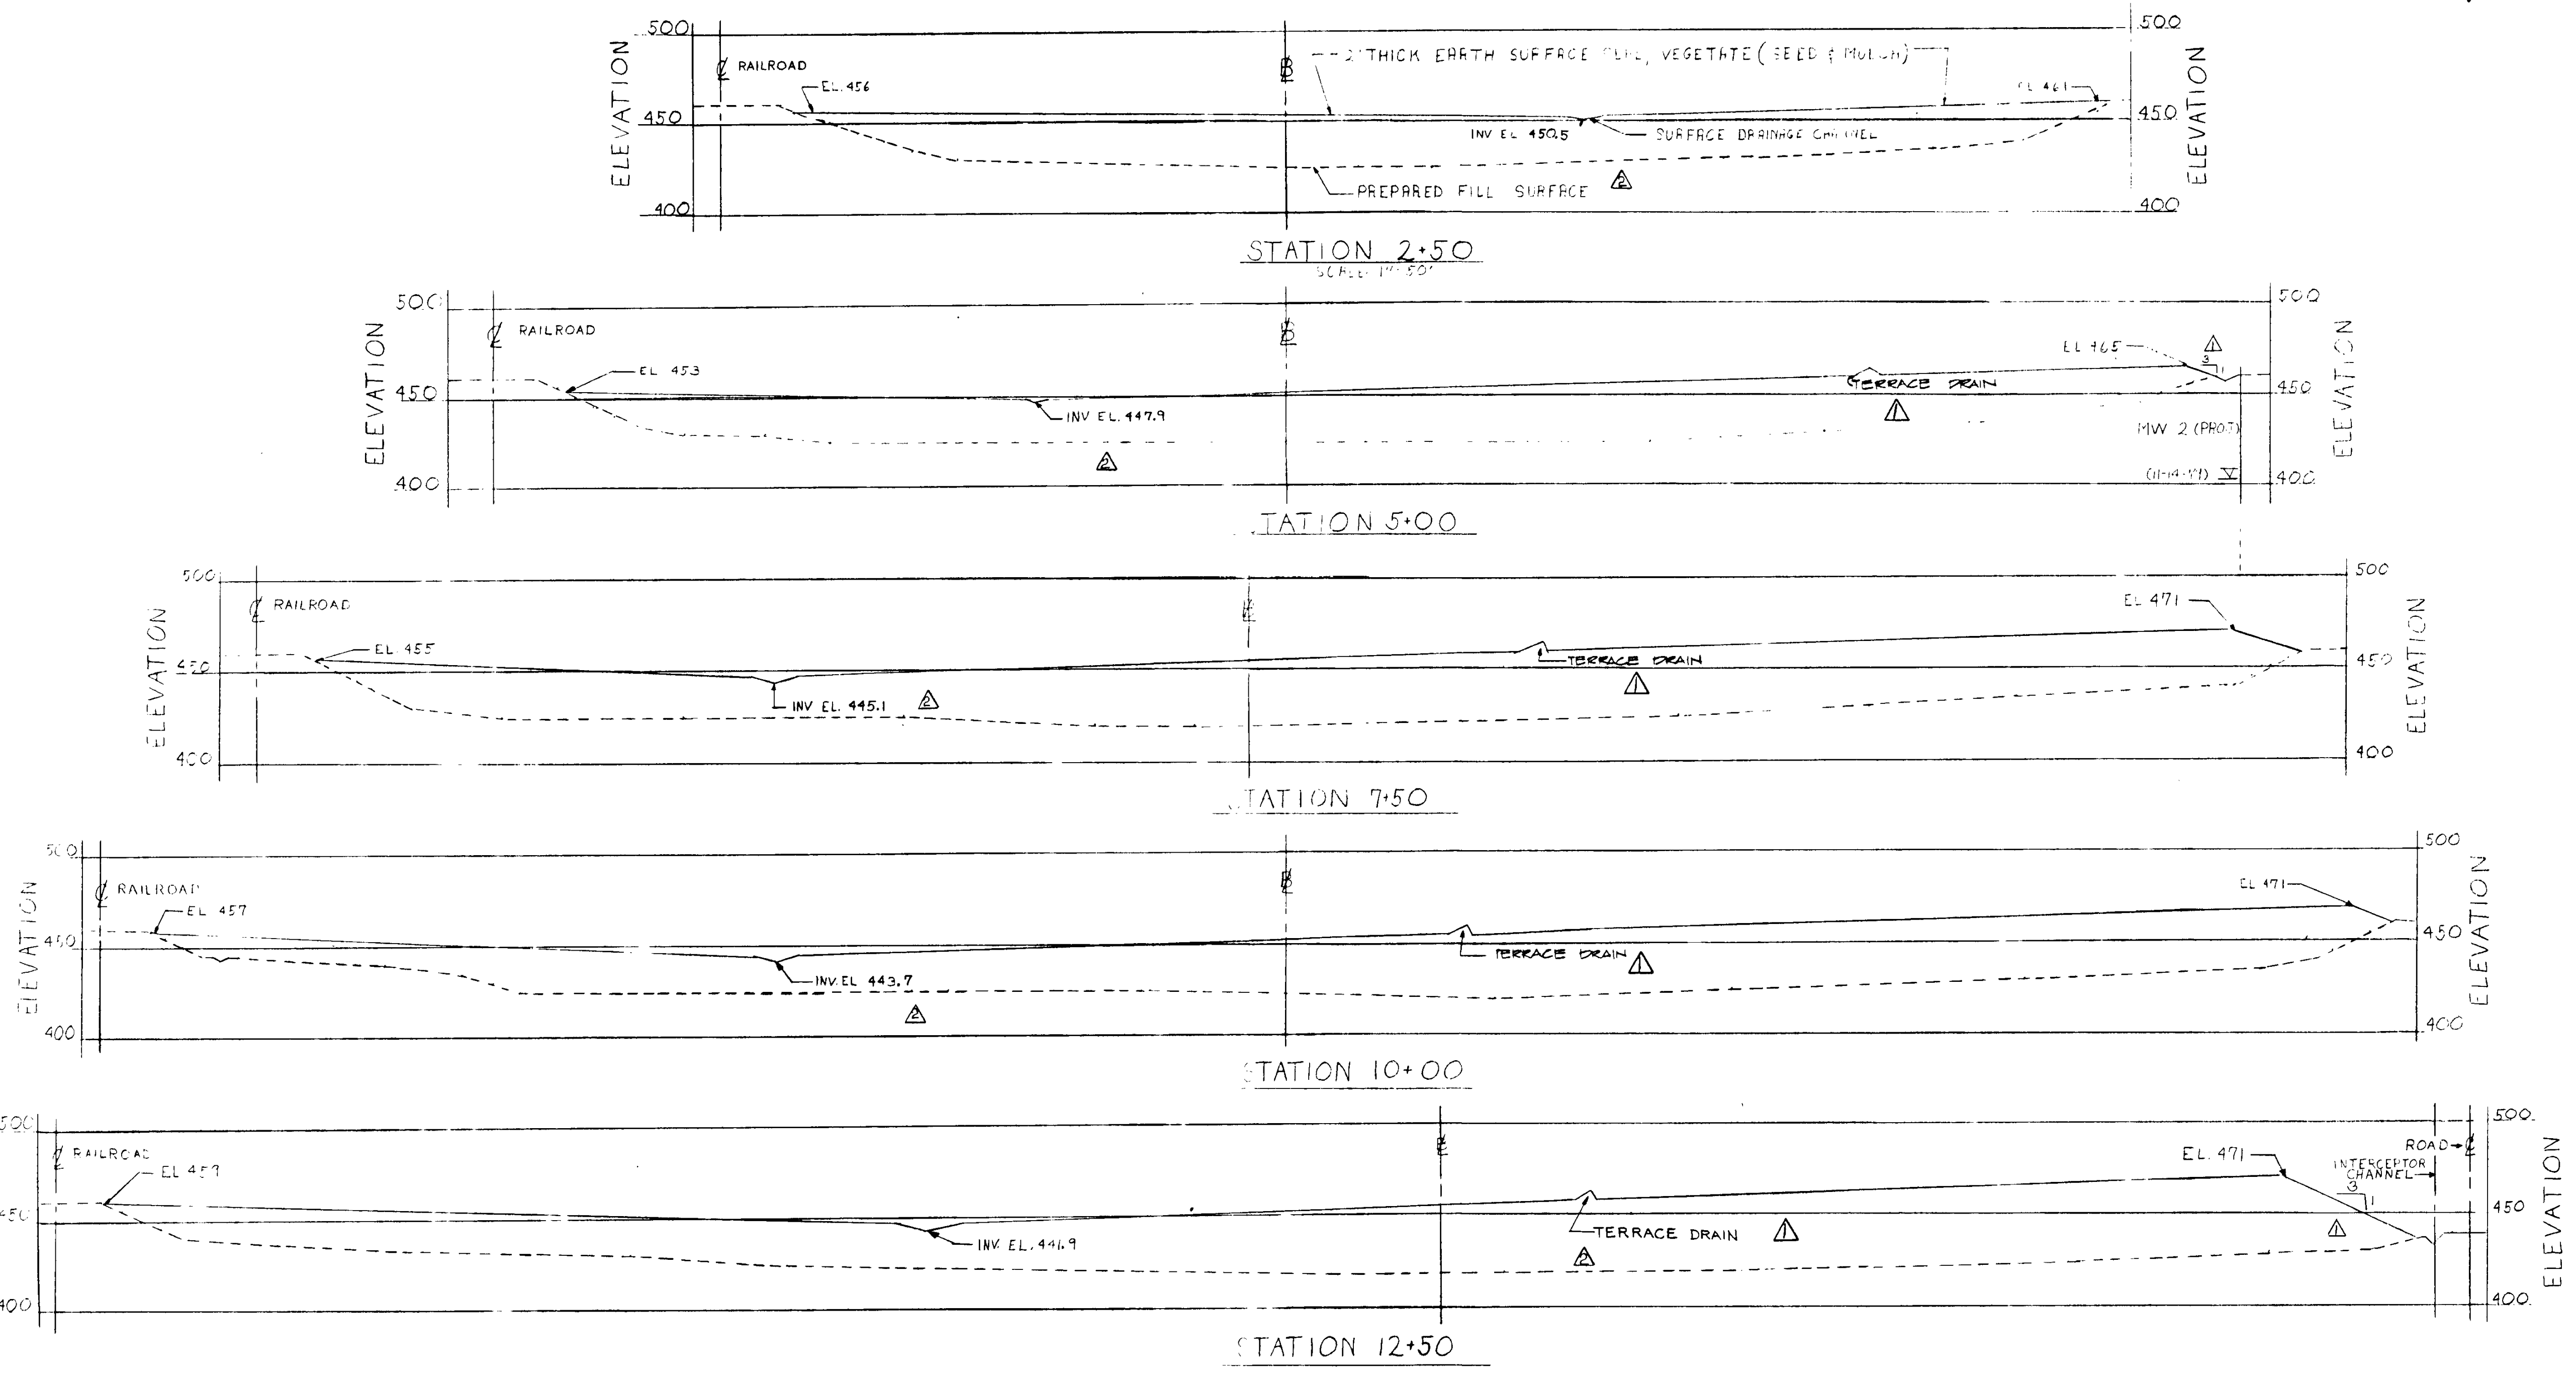

- NOTES:**
1. FOR LEGEND AND GENERAL NOTES SEE DWG. CA10600.
 2. FOR SECTION LOCATIONS SEE DWG. CA10616.
 3. NOTES ON SECTION @ STA 2+50 APPLY TO ALL LANDFILL CROSS SECTIONS SHOWN ON DWG'S UNLESS OTHERWISE NOTED.
 4. FOR LANDFILL CREEP GRADES SEE DWG. CA10616.

Project	Contract No.	LGE LOUISVILLE GAS & ELECTRIC COMPANY A DIVISION OF ENERGY.	From
None	n/a		Floor Engineers Inc.
Engineering Discipline	Drawing Type		From
E-M-C			Floor Engineers Inc.
			Floor Engineers Inc.
			CONSTRUCTION
			Interstate Drawing Inc.
Company Discipline	Job or Product No.	Drawing No.	
CE & CM Dept.			

DRAWING TITLE LINE #1
DRAWING TITLE LINE #2
DRAWING TITLE LINE #3


REVISIONS

Project: MC_SETUP
Scanned Drawing and
setup in DWG database
and picked up field
revisions.
Dwn: Ray Miller
Dwn: Dave Wilms
App: Charles Jacobs

REFERENCE DRAWINGS	
DWG. NO.	TITLE

REVISIONS			
REV.	DATE	BY	CHK'D
1	3/20/04	JKW	JWC
2	3/20/04	JKW	JWC

FILMED
OCT 10 2005
SCD

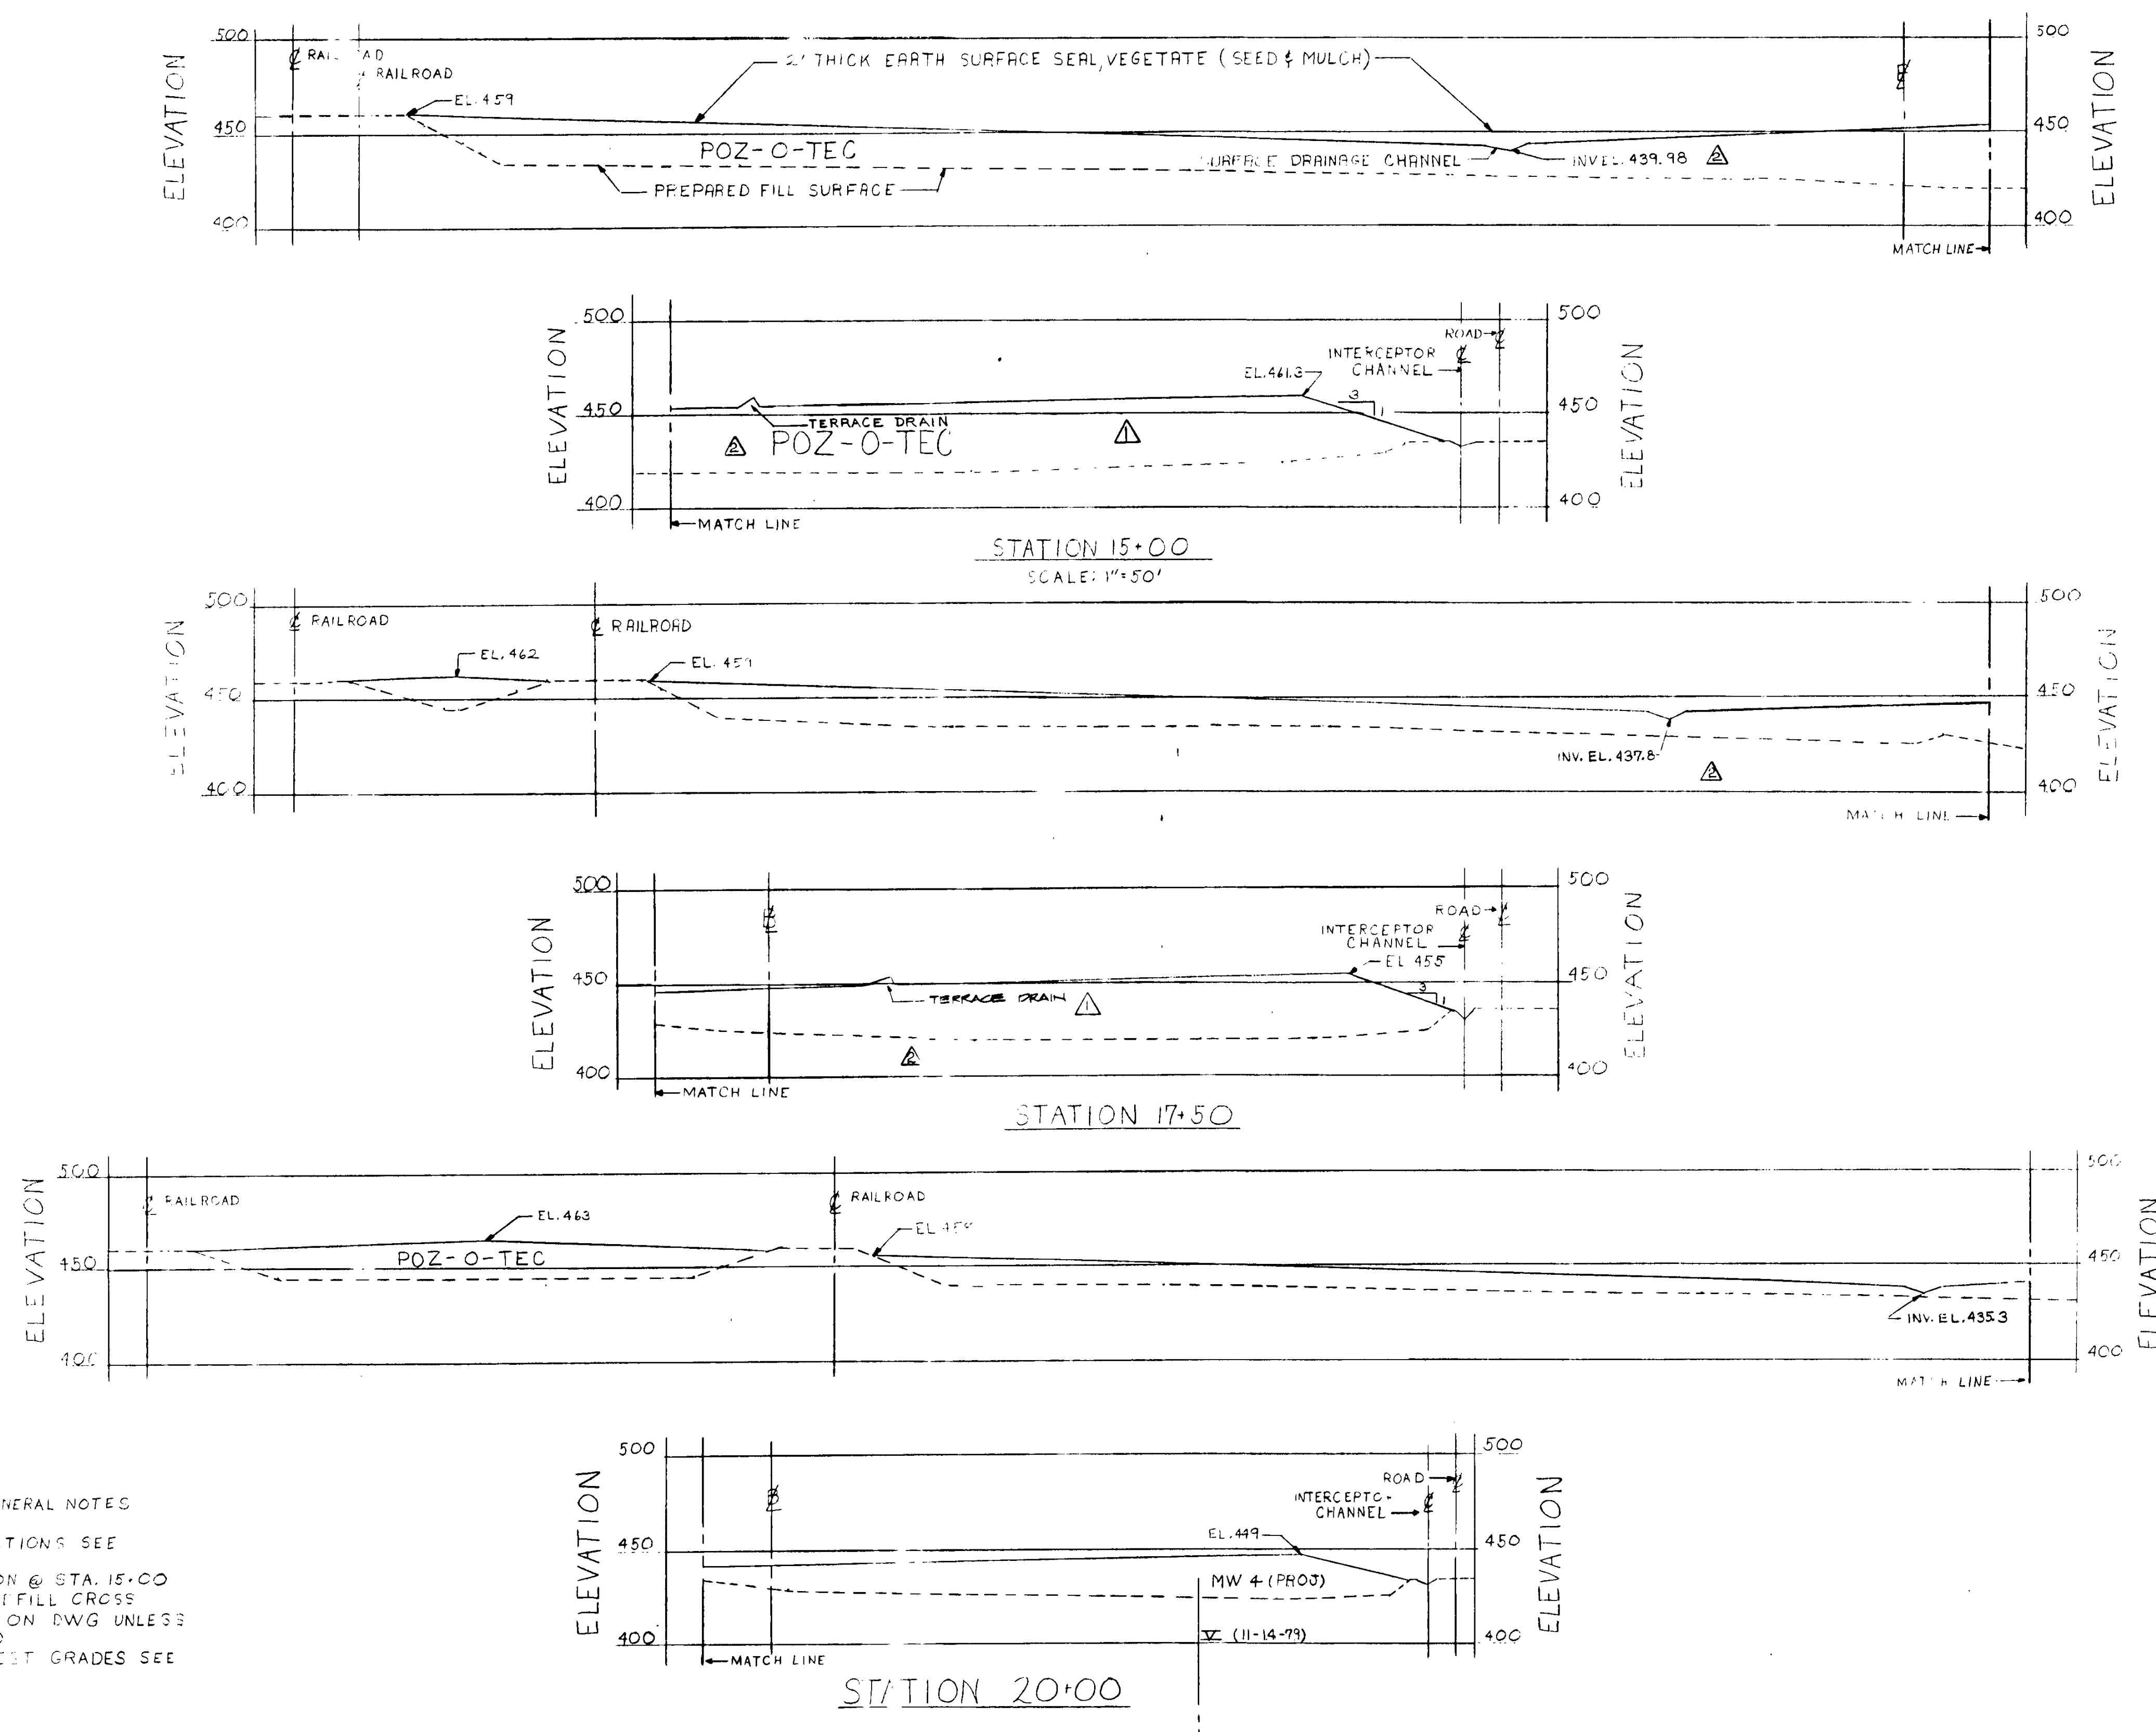

- NOTES:
- FOR LEGEND AND GENERAL NOTES SEE DWG. CA10606
 - FOR SECTION LOCATIONS SEE DWG. CA 10616
 - NOTES ON SECTION @ STA. 15+00 APPLY TO ALL LANDFILL CROSS SECTIONS SHOWN ON DWG UNLESS OTHERWISE NOTED
 - FOR LANDFILL CREST GRADES SEE DWG. CA10616

THIS REPRODUCTION IS CONFIDENTIAL AND SHALL NOT BE USED OR REPRODUCED IN ANY PART WITHOUT WRITTEN CONSENT OF IU CONVERSION SYSTEMS, INC.

IU CONVERSION SYSTEMS, INC.
HORSHAM, PA.

DRW. BY	DATE	CHK'D BY	DATE	DWG. NO.	REV.
JKW	3-23-00	JWC	3-24-00	2204-E-115	2
ENGINEER	DATE	PROJ. MGR.	DATE		
JWC	3-9-00	JWT	3-28-00		

LOUISVILLE GAS & ELECTRIC CO.
CONSTRUCTION DEPT.
MILL CREEK GENERATING STATION

CROSS SECTIONS SITE "B"

SCALE	DATE	JOB
1" = 50'		31-7400
DRAWN BY	DATE	CHECKED BY
APPROVED BY	DATE	

Project	Contract No.	LGE LOUISVILLE GAS & ELECTRIC COMPANY A DIVISION OF ENERGY	Client	Central Engineering & Construction Management Department
None	n/a		Project	None
Engineering Discipline	Design Type		Contractor	None
E-M-C			Construction	None
DRAWING TITLE LINE #1 DRAWING TITLE LINE #2 DRAWING TITLE LINE #3			Contract No.	None
Company Discipline	Job or Product No.	Drawing No.		
CE & CM Dept.				