


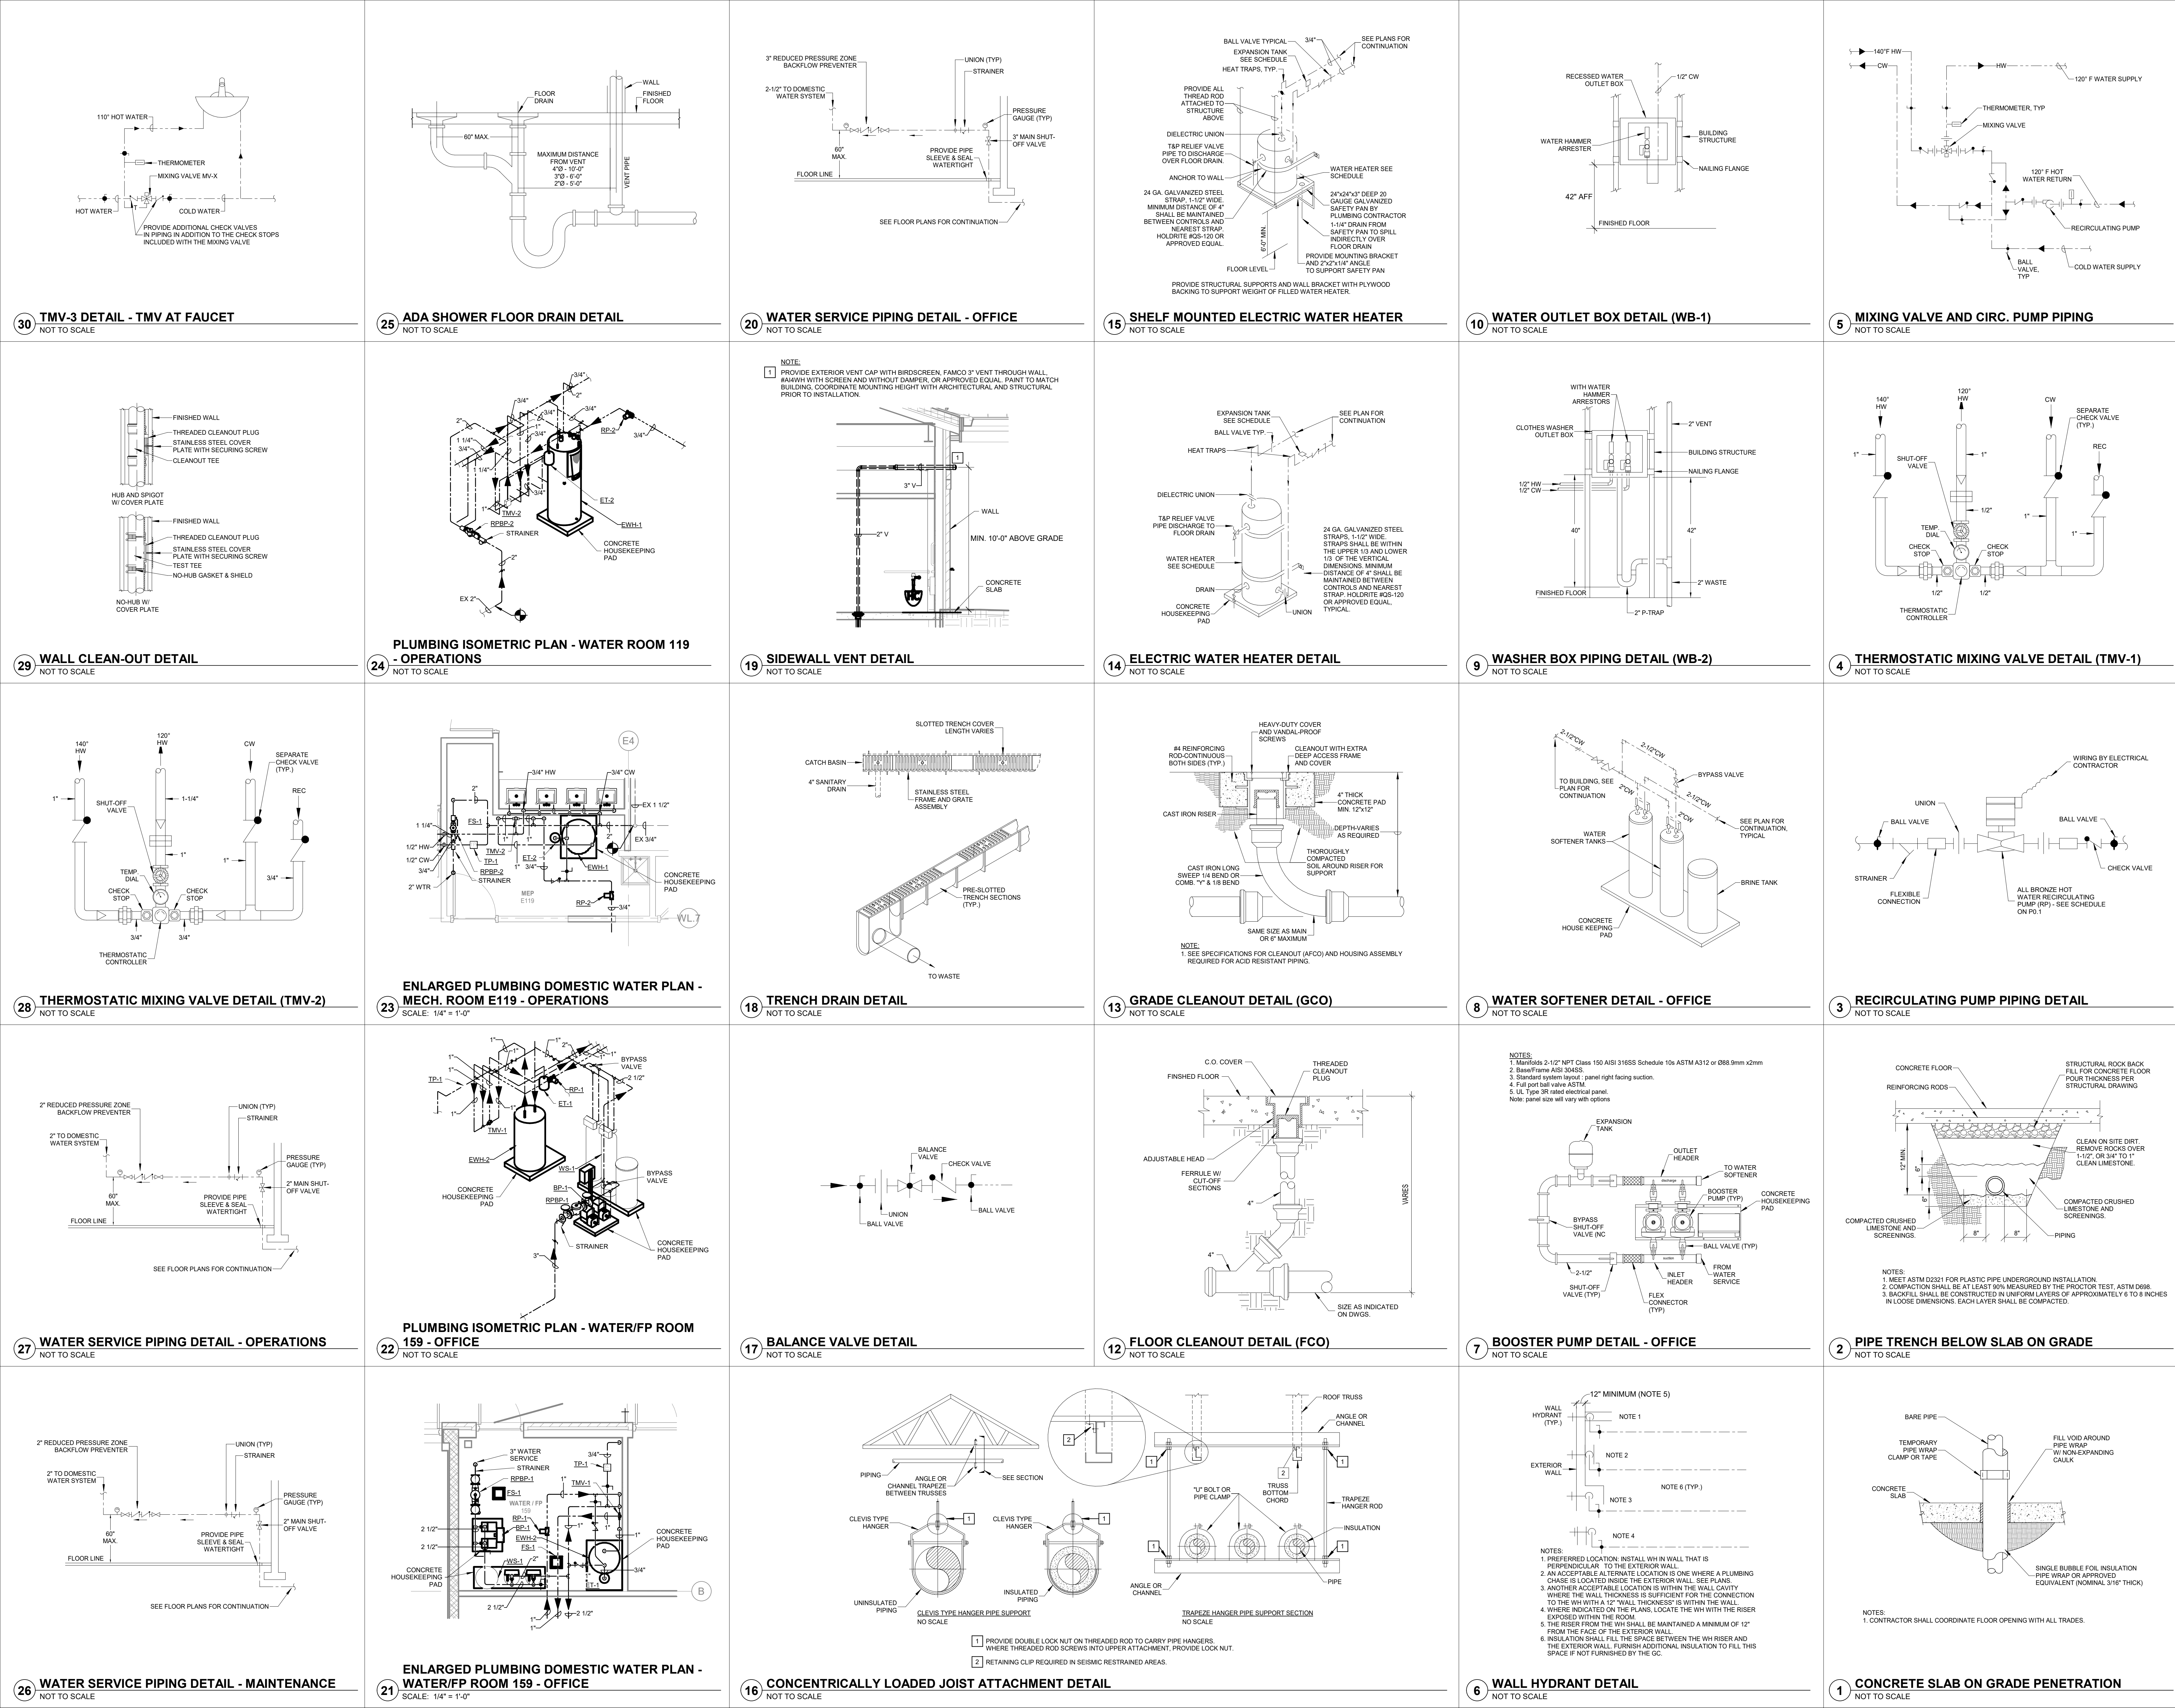

M+H
ARCHITECTS

ARCHITECT:
Mitchell and Hugesback Architects, Inc.
D.B.A. M+H Architects
12747 Olive Blvd., Suite 150
St. Louis, MO 63141
314-878-3500
www.mha-us.com

CONSULTANT:
SSC Engineering, Inc.
Michael K. Swim Consulting Engineer, Inc.
D.B.A. SSC Engineering, Inc.
18207 Edison Ave.
St. Louis, MO 63005
636-530-7770
Corporate License No.: 001244

COOPERATIVE
BUILDING SOLUTIONS

TAYLOR COUNTY RECC
685 WATER TOWER BYPASS
CAMBELLEVILLE, KY 42218

CHRISTIAN W. HULETT
Professional Engineer
KY LIC#: 29287
EXP: 06/30/2027

STATE OF KENTUCKY
CHRISTIAN W. HULETT
Professional Engineer
LICENSED PROFESSIONAL ENGINEER


The Seal and Signature apply only to the Document to which they are Affixed, and Expressly Disclaim any Responsibility for all other Plans, Specifications, Estimates, Reports, or other Documents or Instruments relating to or intended to be used for any part or parts of the Architectural or Engineering Project.
Copyright © 2025 by SSC Engineering

REVISION:
100% CONSTRUCTION DOCUMENTS
08/20/2026


Sheet Issue Date: 08/20/2026
Job Number: 250120.00
Drawn By: CMW
Checked By: MEL
Drawing Title:

PLUMBING DETAILS
P0.2


SSC JOB# 2025456

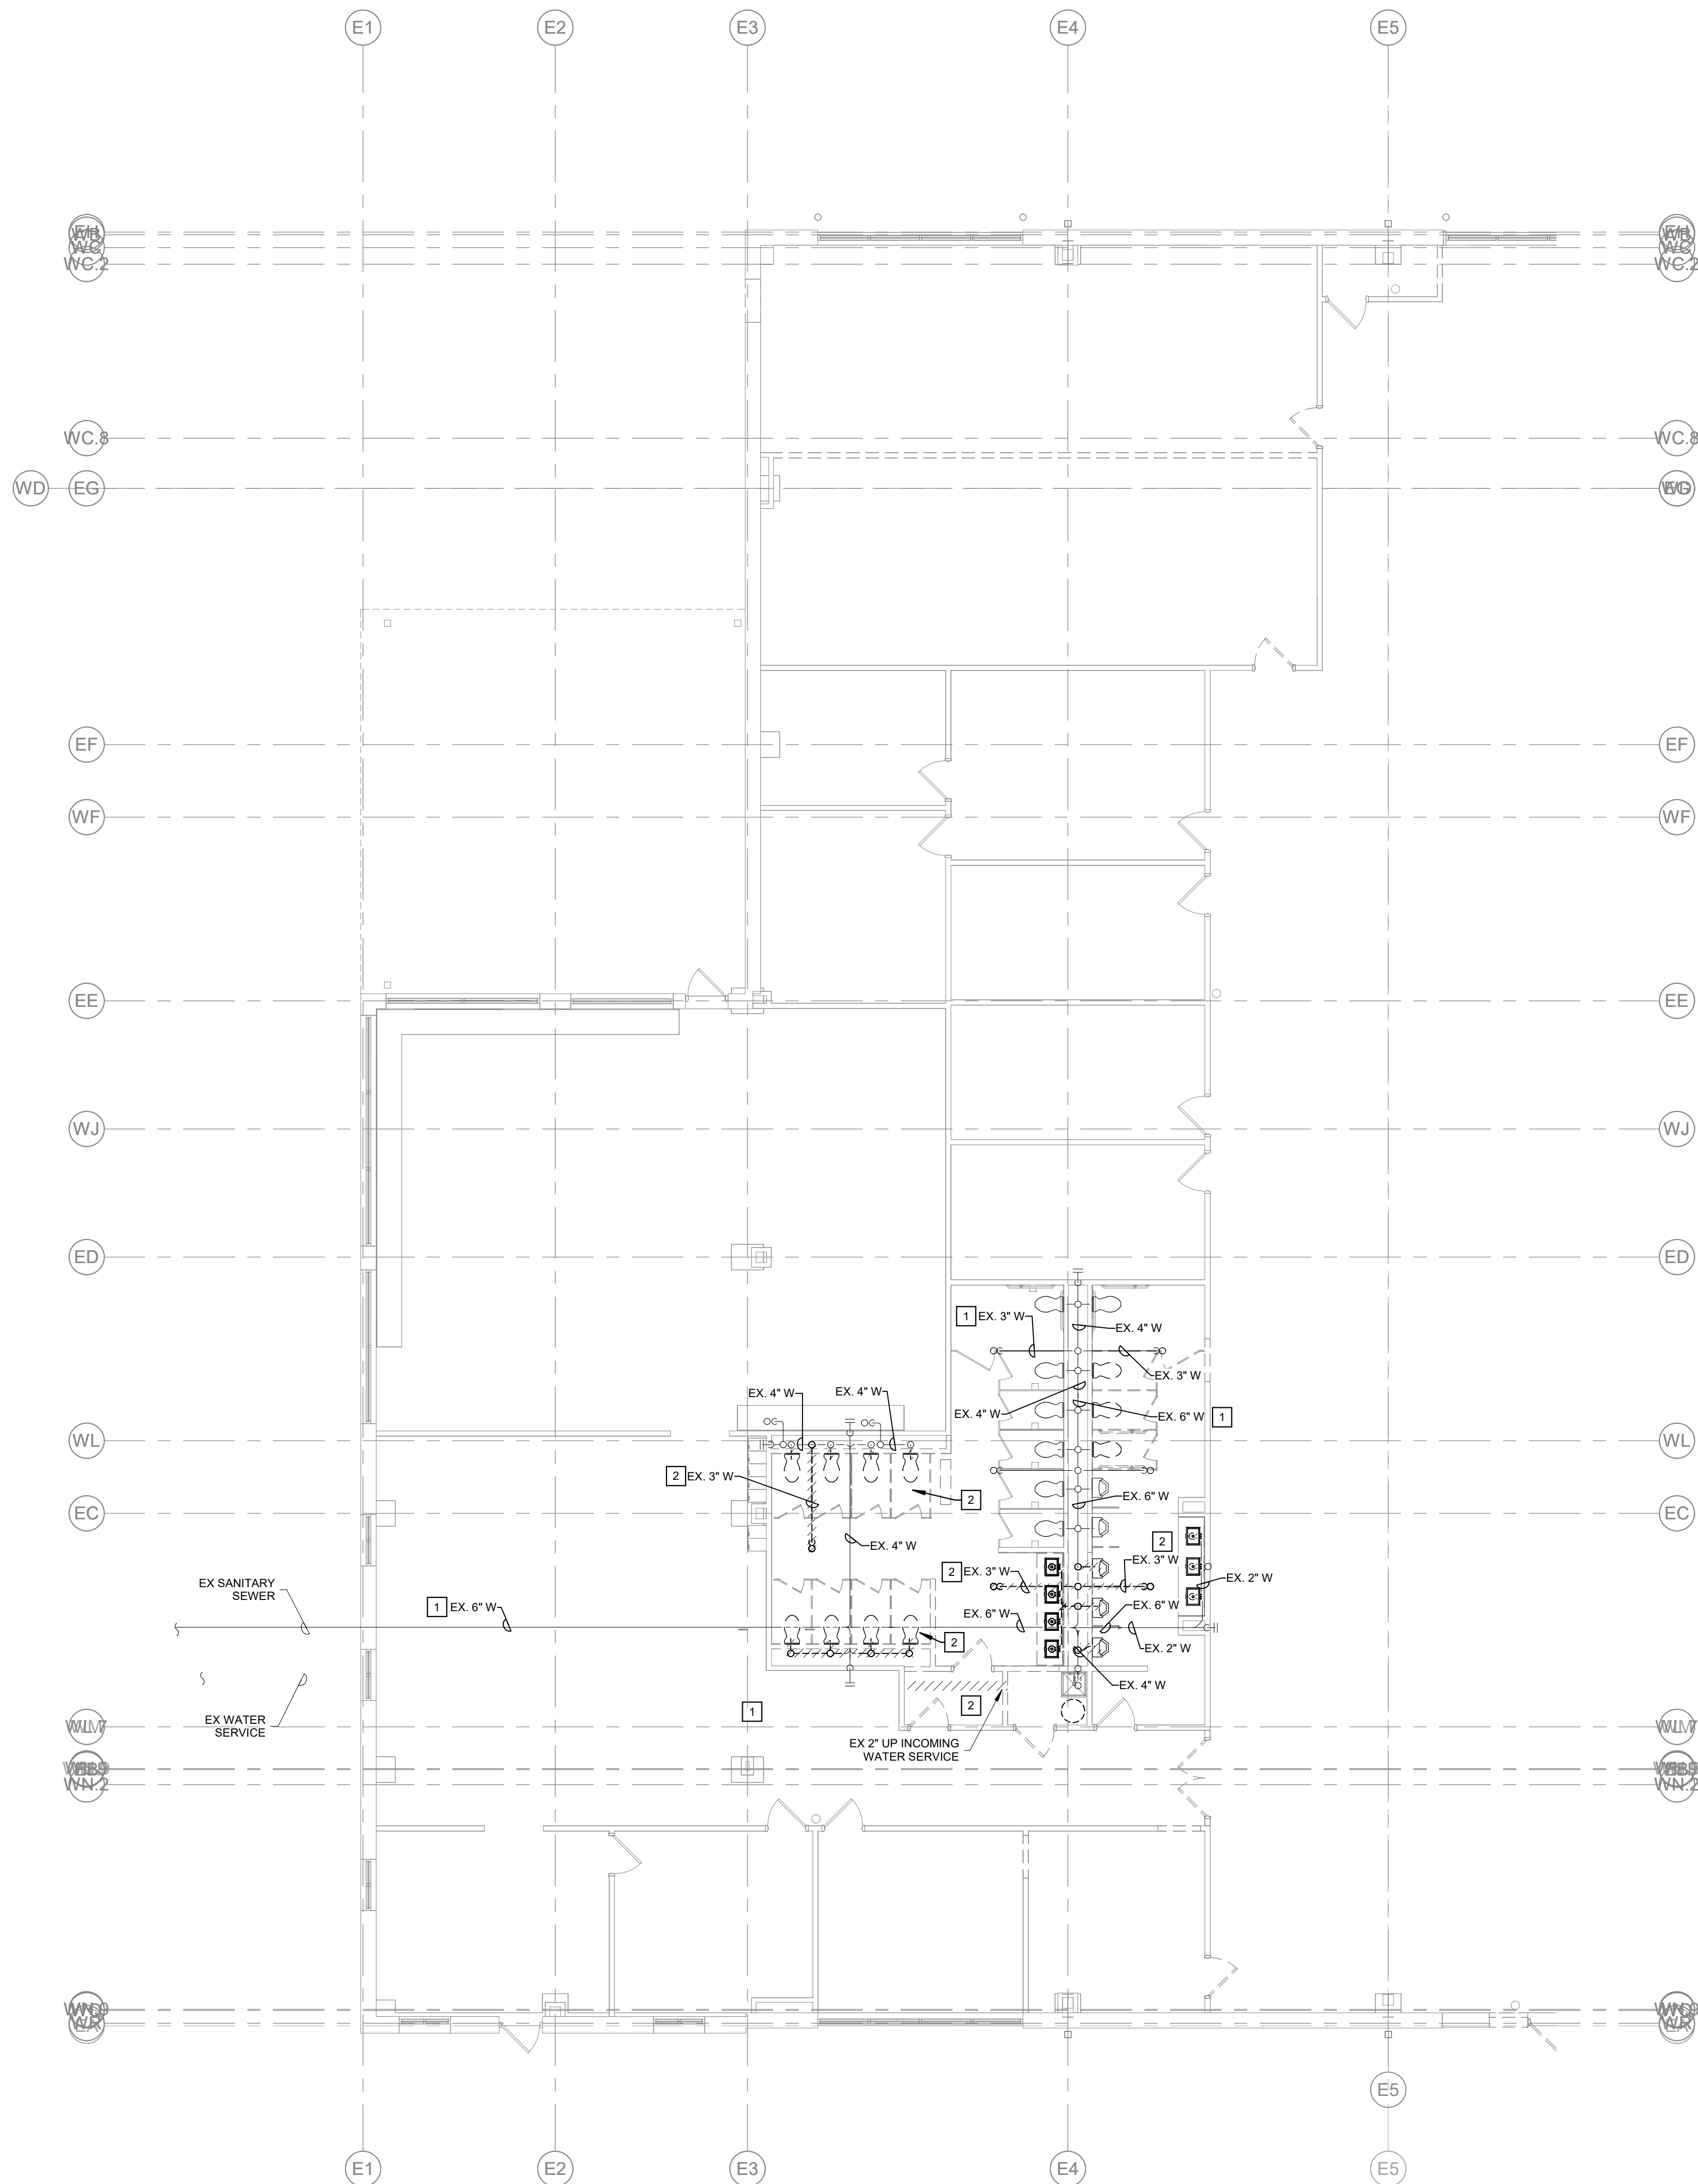

UNDERGROUND PLUMBING DEMOLITION PLAN - OPERATIONS
SCALE: 1/8" = 1'-0"
NORTH

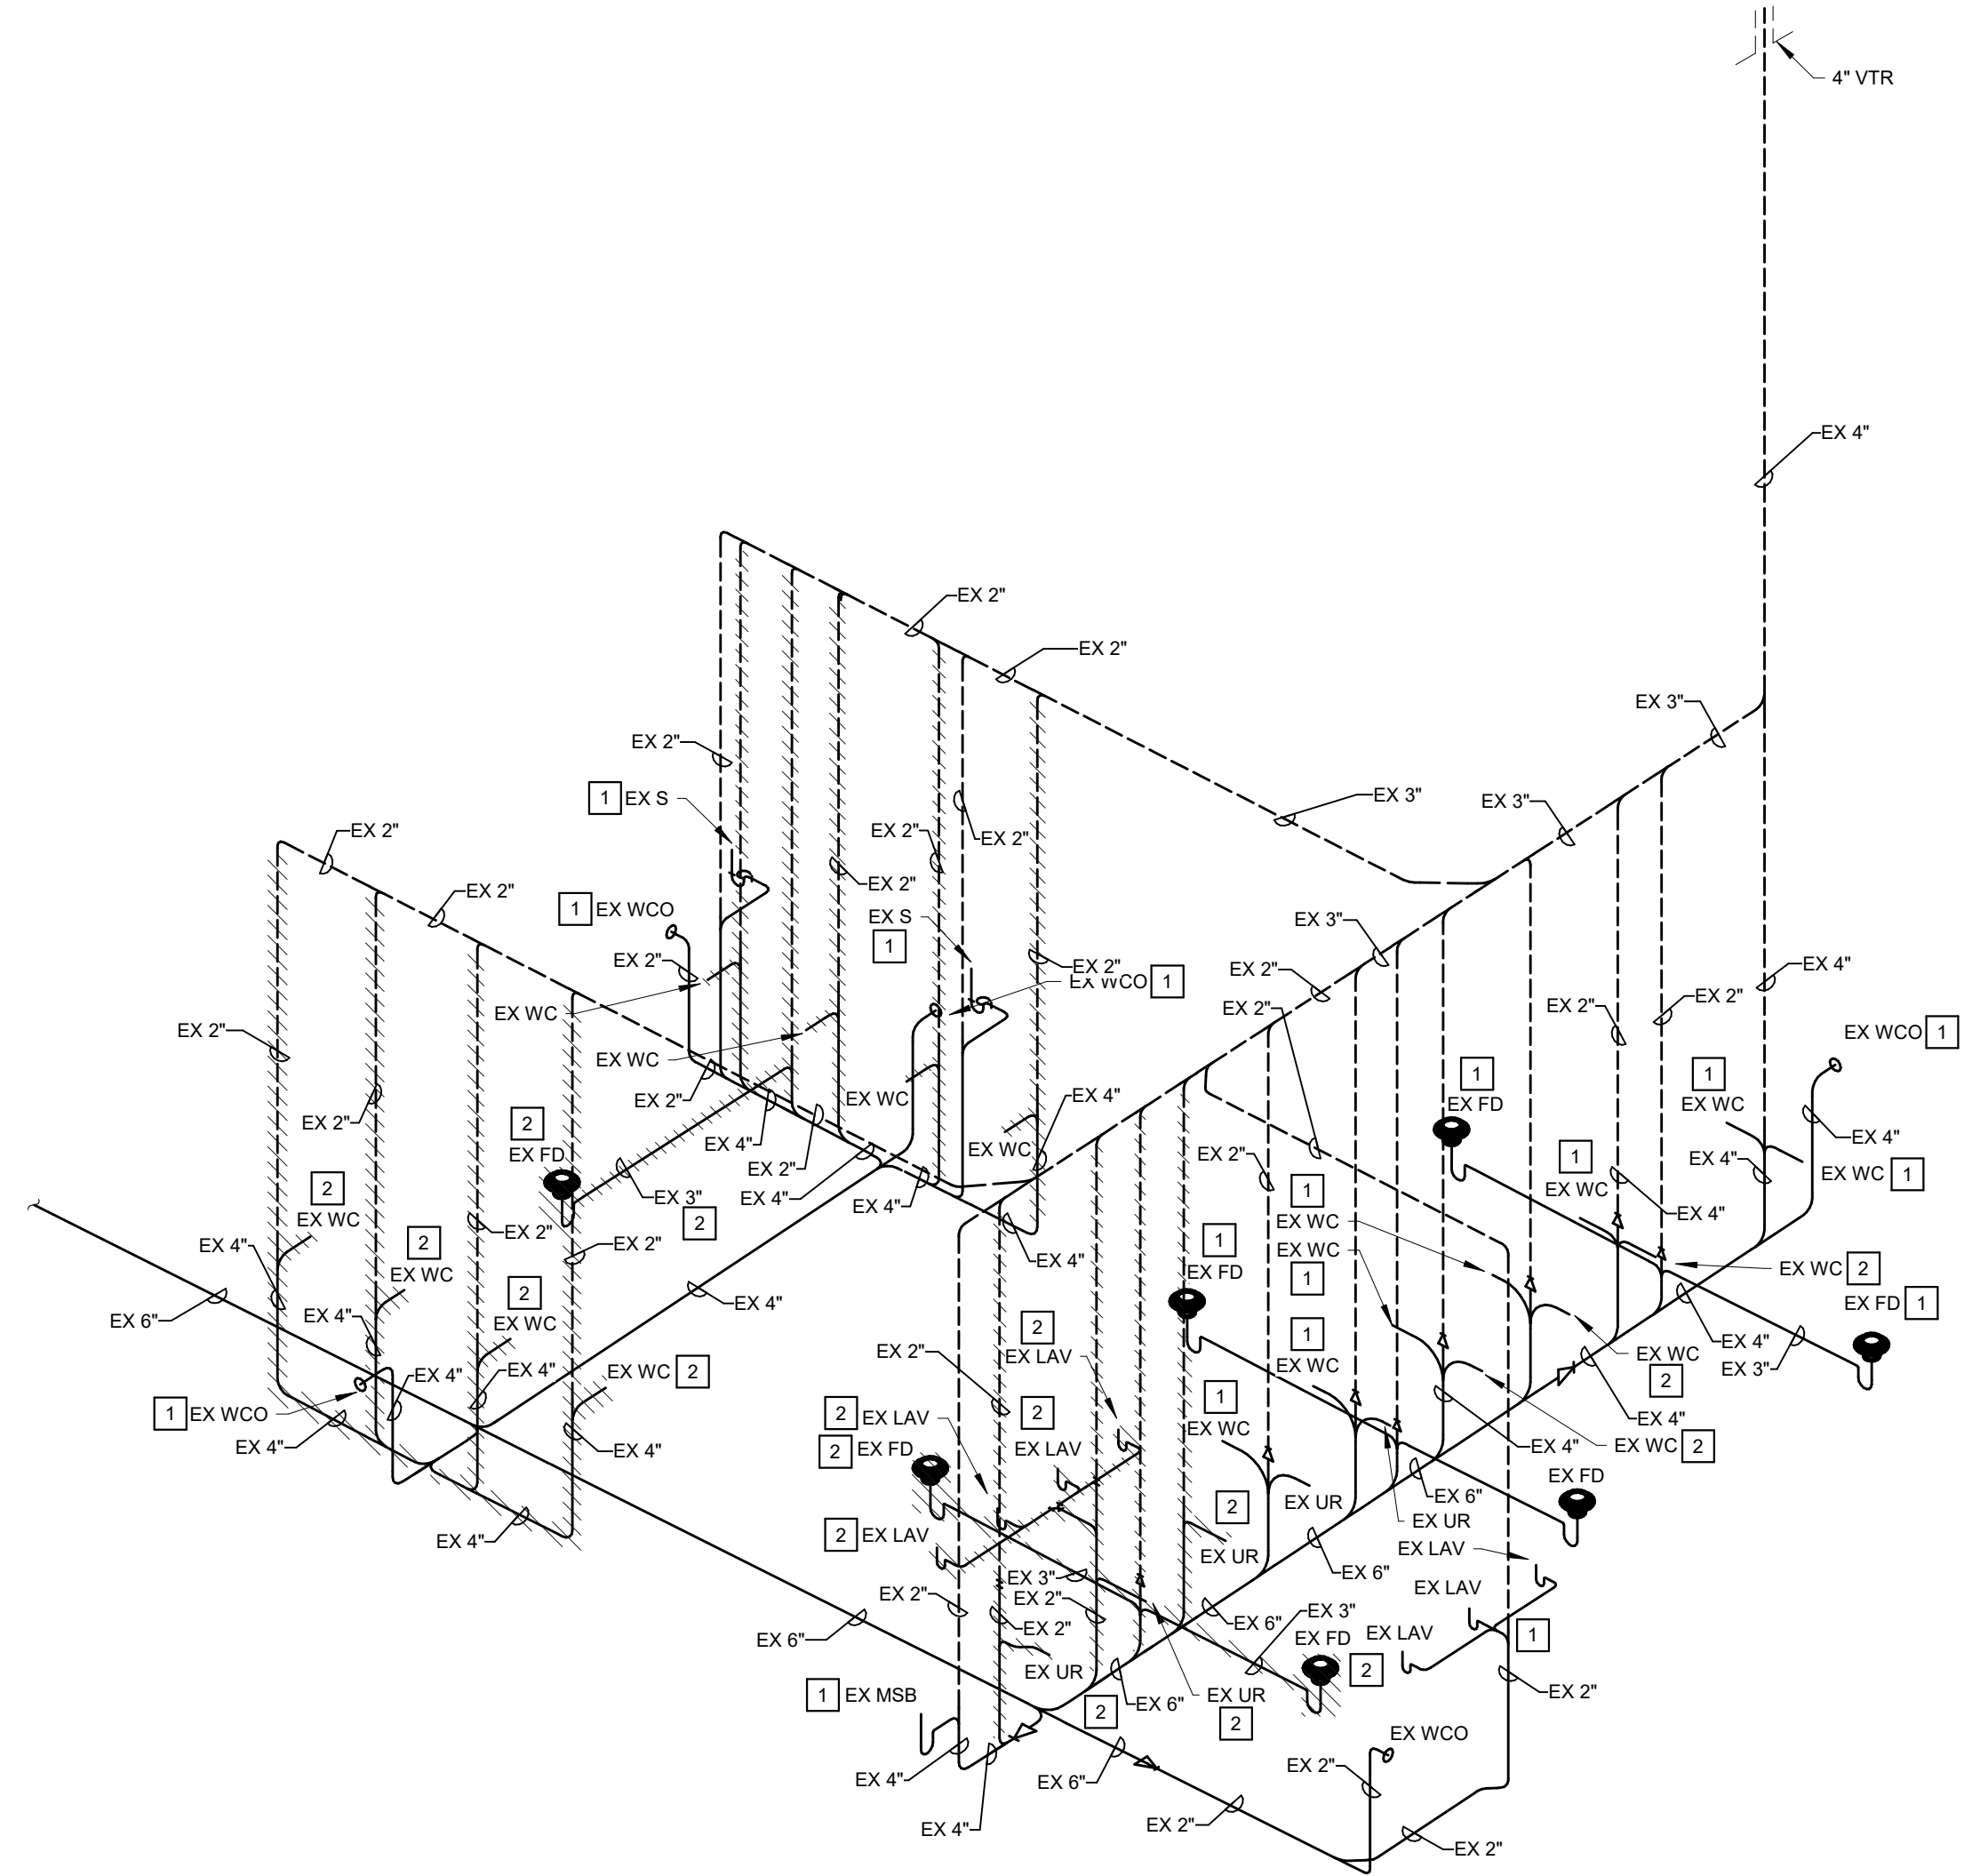

PLUMBING WASTE & VENT ISOMETRIC PLAN - EXISTING
NOT TO SCALE

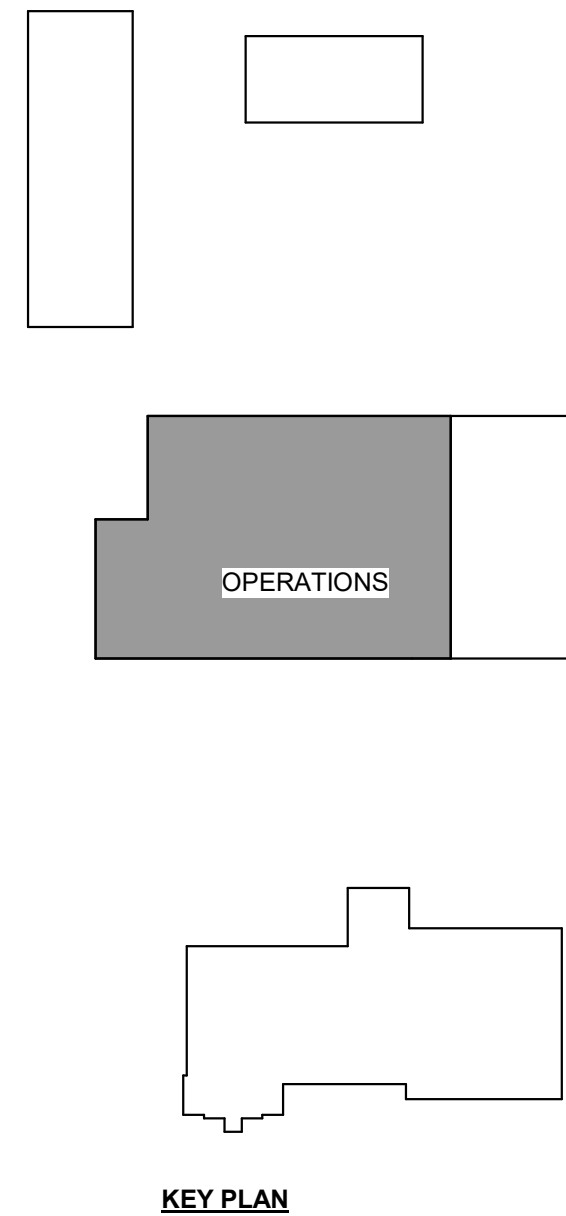

GENERAL NOTES:

1. REFER TO SHEET PD.1 FOR SYMBOLS, ABBREVIATIONS AND GENERAL CONSTRUCTION NOTES.

KEYED NOTES:

- 1 EXISTING TO REMAIN.
2 DISCONNECT AND REMOVE.

CONSULTANT:


SSC Engineering, Inc.

Michael K. Swim Consulting Engineer, Inc.
D.B.A. SSC Engineering, Inc.
18207 Edison Ave.
St. Louis, MO 63005
636-530-7770
Corporate License No.: 001244

TAYLOR COUNTY RECC

685 WATER TOWER BYPASS
CAMBELLSVILLE, KY 42718

CHRISTIAN W. HULETT
Professional Engineer
KY LIC#: 29287
EXP: 06/30/2027

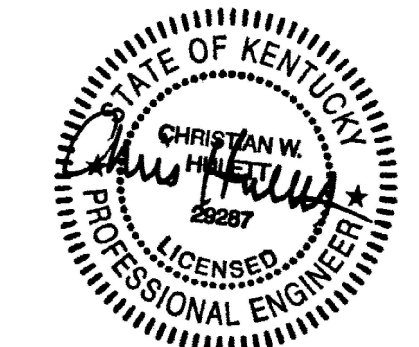

08/20/2026
The Seal and Signature apply only to the Document to which they are Affixed, and Expressly Disclaim any Responsibility for all other Plans, Specifications, Estimates, Reports, or other Documents or Instruments relating to or intended to be used for any part or parts of the Architectural or Engineering Project.
Copyright © 2026 by SSC Engineering

REVISION:

100% CONSTRUCTION DOCUMENTS 08/20/2026

Sheet Issue Date: 08/20/2026

Job Number: 250120.00

Drawn By: CMW

Checked By: MEL

Drawing Title:

**PLUMBING
UNDERGROUND
DEMOLITION PLAN -
OPERATIONS**

PD1.1

SSC JOB# 2025456

TAYLOR COUNTY RECC

685 WATER TOWER BYPASS
CAMBELLSVILLE, KY 42718CHRISTIAN W. HULETT
Professional Engineer
KY LIC#: 29287
EXP: 06/30/2027

08/20/2026

The Seal and Signature apply only to the Document to which they are Affixed, and Expressly Disclaim any Responsibility for all other Plans, Specifications, Estimates, Reports, or other Documents or Instruments relating to or intended to be used for any part or parts of the Architectural or Engineering Project.
Copyright © 2026 by SSC Engineering

REVISION:
100% CONSTRUCTION DOCUMENTS 08/20/2026Sheet Issue Date: 08/20/2026
Job Number: 250120.00
Drawn By: CMW
Checked By: MELDrawing Title:
**PLUMBING WASTE
AND VENT
DEMOLITION PLAN -
OPERATIONS**


PD2.1

PLUMBING GENERAL NOTES:


1. REFER TO SHEET PD.1 FOR SYMBOLS, ABBREVIATIONS AND GENERAL CONSTRUCTION NOTES.

PLUMBING KEYED NOTES:

- 1 EXISTING TO REMAIN.
- 2 EXISTING FIXTURE TO BE SALVAGED AND RELOCATED.
- 3 REMOVE FIXTURE & RELATED PIPING.
- 4 REMOVE FLOOR FOR NEW WORK. COORDINATE WITH STRUCTURAL DRAWINGS.
- 5 REMOVE WALL TO ACCESS PIPE CHASE.

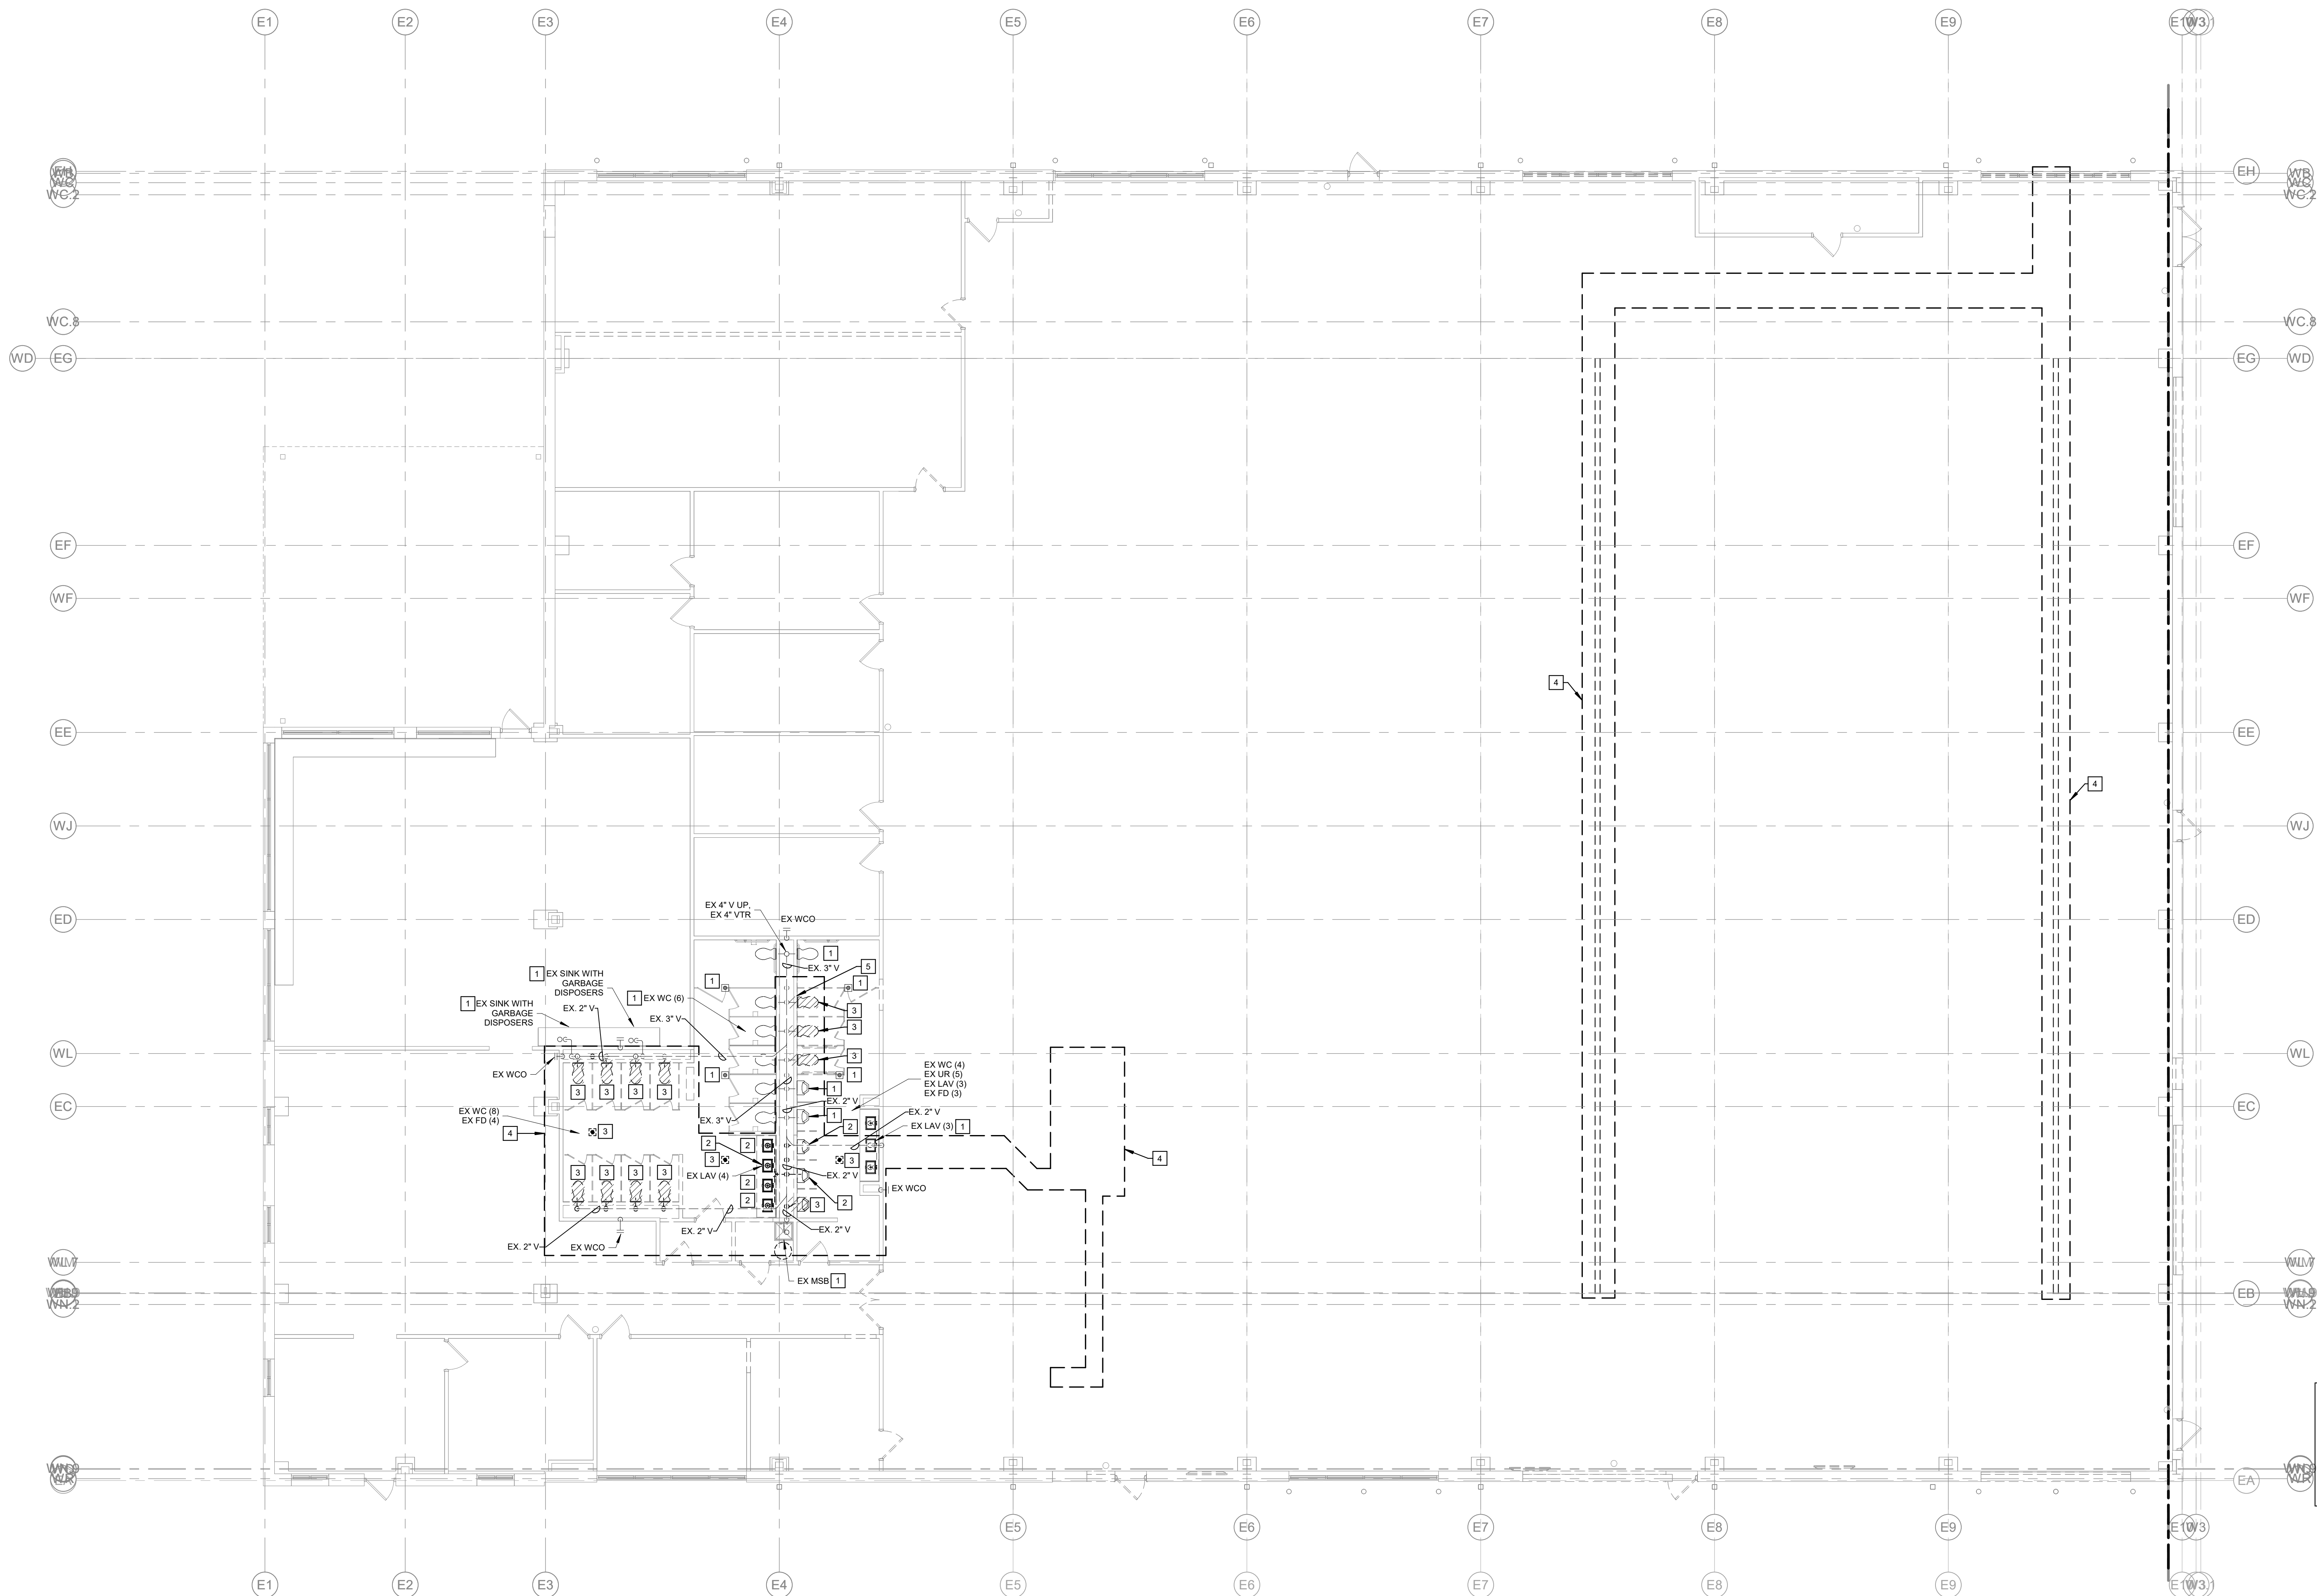**FIRST FLOOR PLUMBING WASTE AND VENT DEMOLITION PLAN - OPERATIONS**
SCALE: 1/8\" = 1'-0\"
NORTH

OPERATIONS

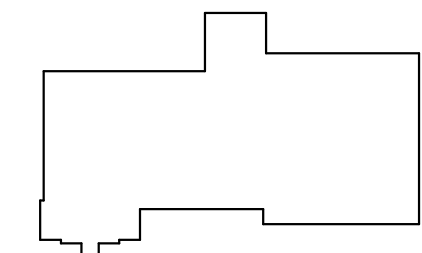

KEY PLAN


SSC JOB# 2025456

PLUMBING GENERAL NOTES:

1. REFER TO SHEET PD 1 FOR SYMBOLS, ABBREVIATIONS AND GENERAL CONSTRUCTION NOTES.


PLUMBING KEYED NOTES:

- 1 EXISTING TO REMAIN.
- 2 EXISTING FIXTURE TO BE SALVAGED AND RELOCATED.
- 3 REMOVE FIXTURE & RELATED PIPING.
- 4 REMOVE FLOOR FOR NEW WORK. COORDINATE WITH STRUCTURAL DRAWINGS. NOT USED.
- 5 REMOVE WALL TO ACCESS PIPE CHASE.
- 6 VERIFY WATER PIPE CONNECTIONS AT EXISTING EQUIPMENT. REPAIR PIPE OR CONNECTION TO FIX/STOP LEAK.

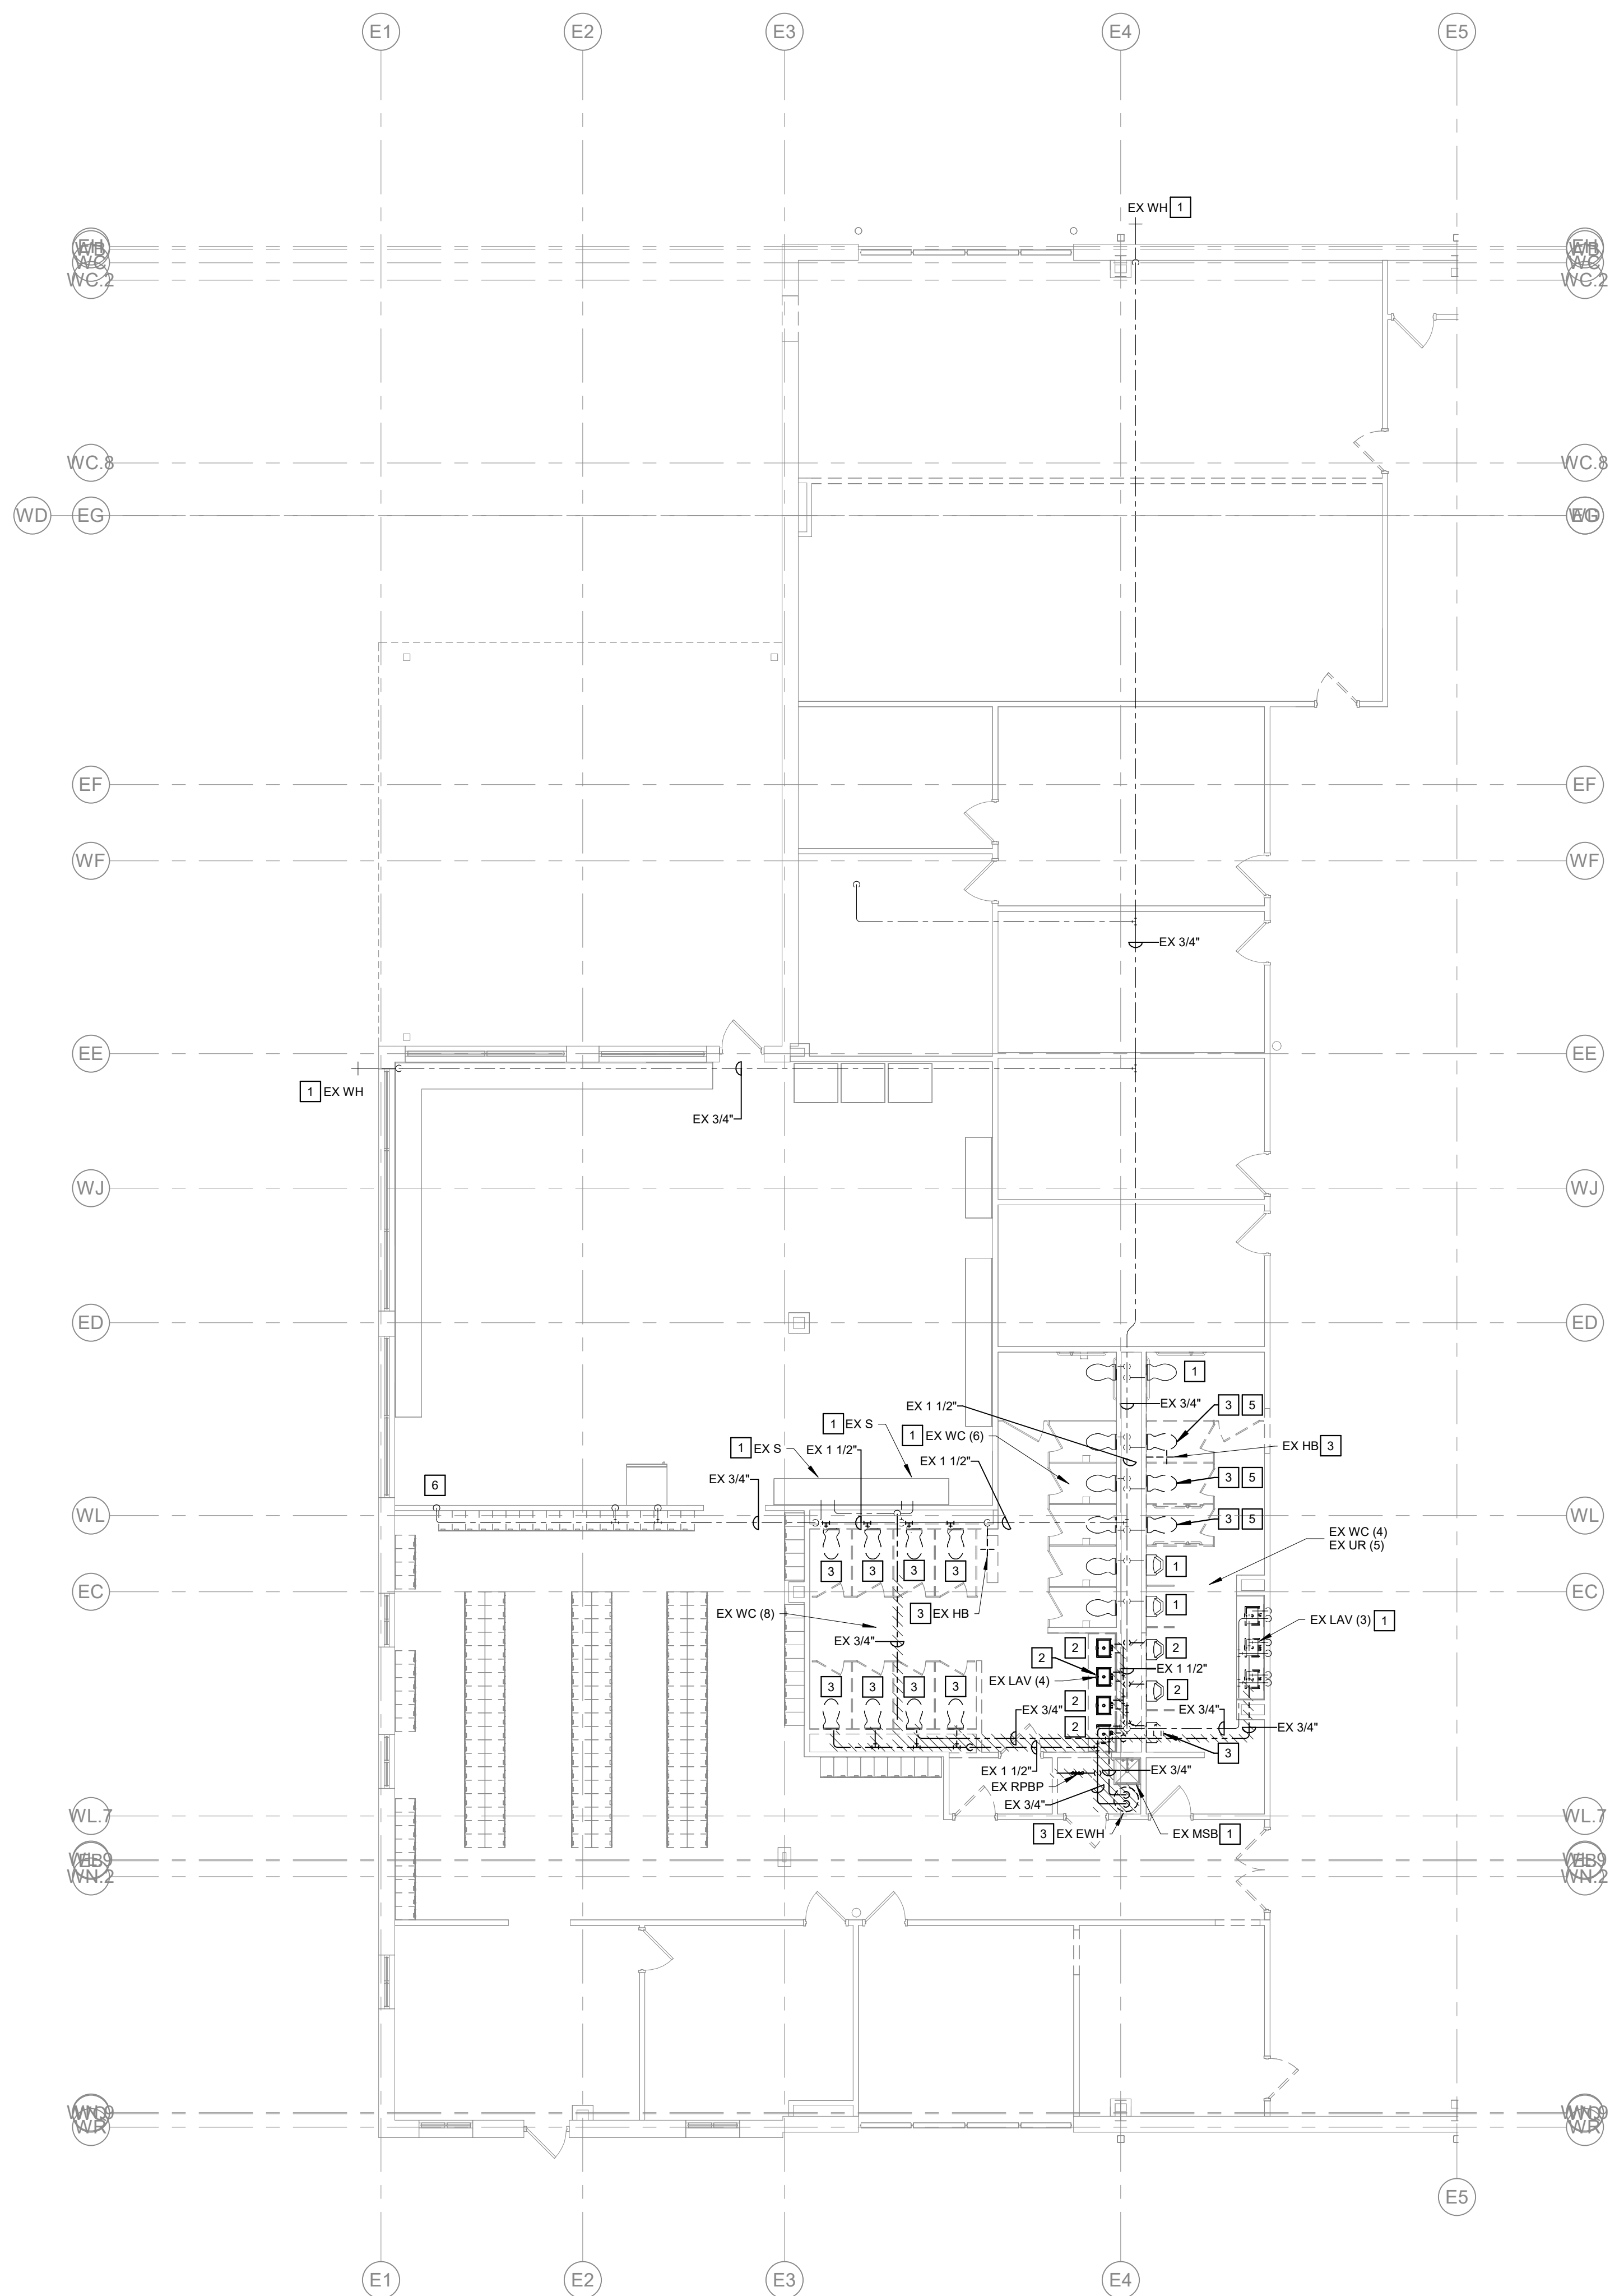




FIRST FLOOR PLUMBING DOMESTIC WATER DEMOLITION PLAN - OPERATIONS

SCALE: 1/8" = 1'-0"

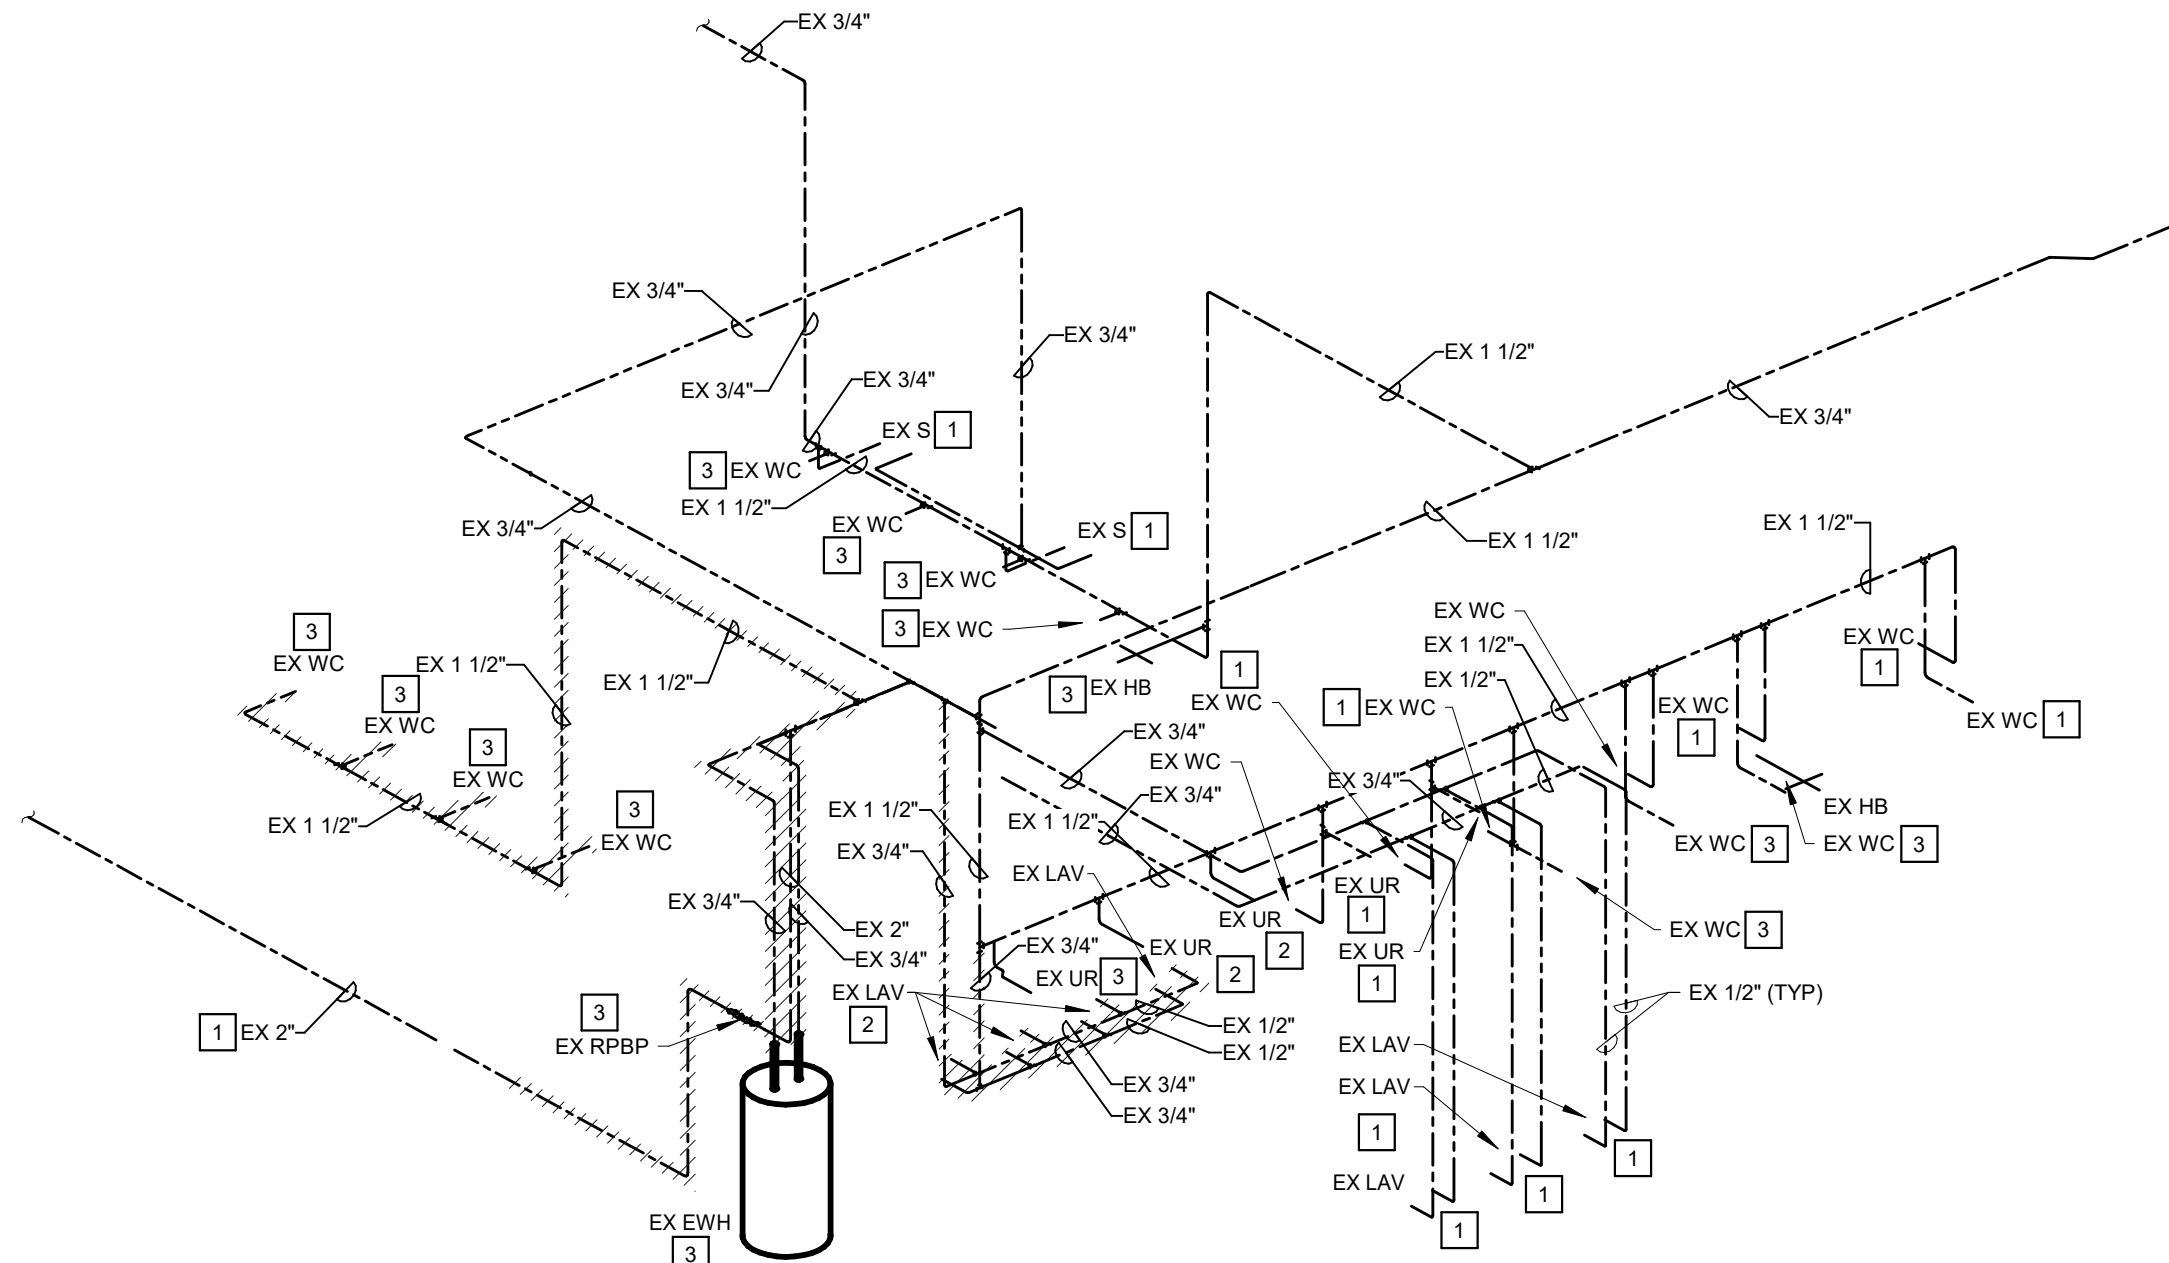

PLUMBING DOMESTIC WATER ISOMETRIC PLAN - EXISTING

NOT TO SCALE

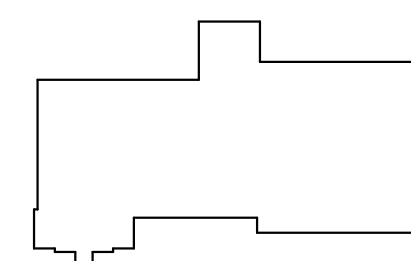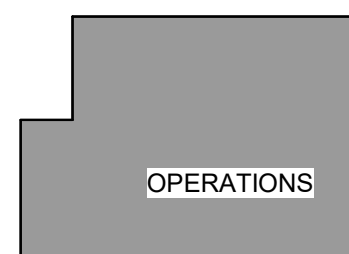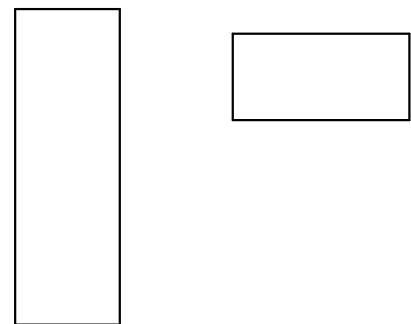

KEY PLAN

TAYLOR COUNTY RECC

685 WATER TOWER BYPASS
CAMBELLSVILLE, KY 42718CHRISTIAN W. HULETT
Professional Engineer
KY LIC#: 29287
EXP: 06/30/2027

08/20/2026

The Seal and Signature apply only to the Document to which they are Affixed, and Expressly Disclaim any Responsibility for all other Plans, Specifications, Estimates, Reports, or other Documents or Instruments relating to or intended to be used for any part or parts of the Architectural or Engineering Project.
Copyright © 2026 by SSC Engineering

REVISION:

100% CONSTRUCTION DOCUMENTS	08/20/2026
-----------------------------	------------

Sheet Issue Date:	08/20/2026
Job Number:	250120.00
Drawn By:	CMW
Checked By:	MEL
Drawing Title:	

PLUMBING
UNDERGROUND PLAN
- OPERATIONS


P1.1

GENERAL NOTES:

1. REFER TO SHEET P0.1 FOR SYMBOLS, ABBREVIATIONS AND GENERAL CONSTRUCTION NOTES.


KEYED NOTES:

- 1 SEE CIVIL FOR CONTINUATION.
2 COORDINATE WITH STRUCTURAL DETAIL #20 ON S0.4.

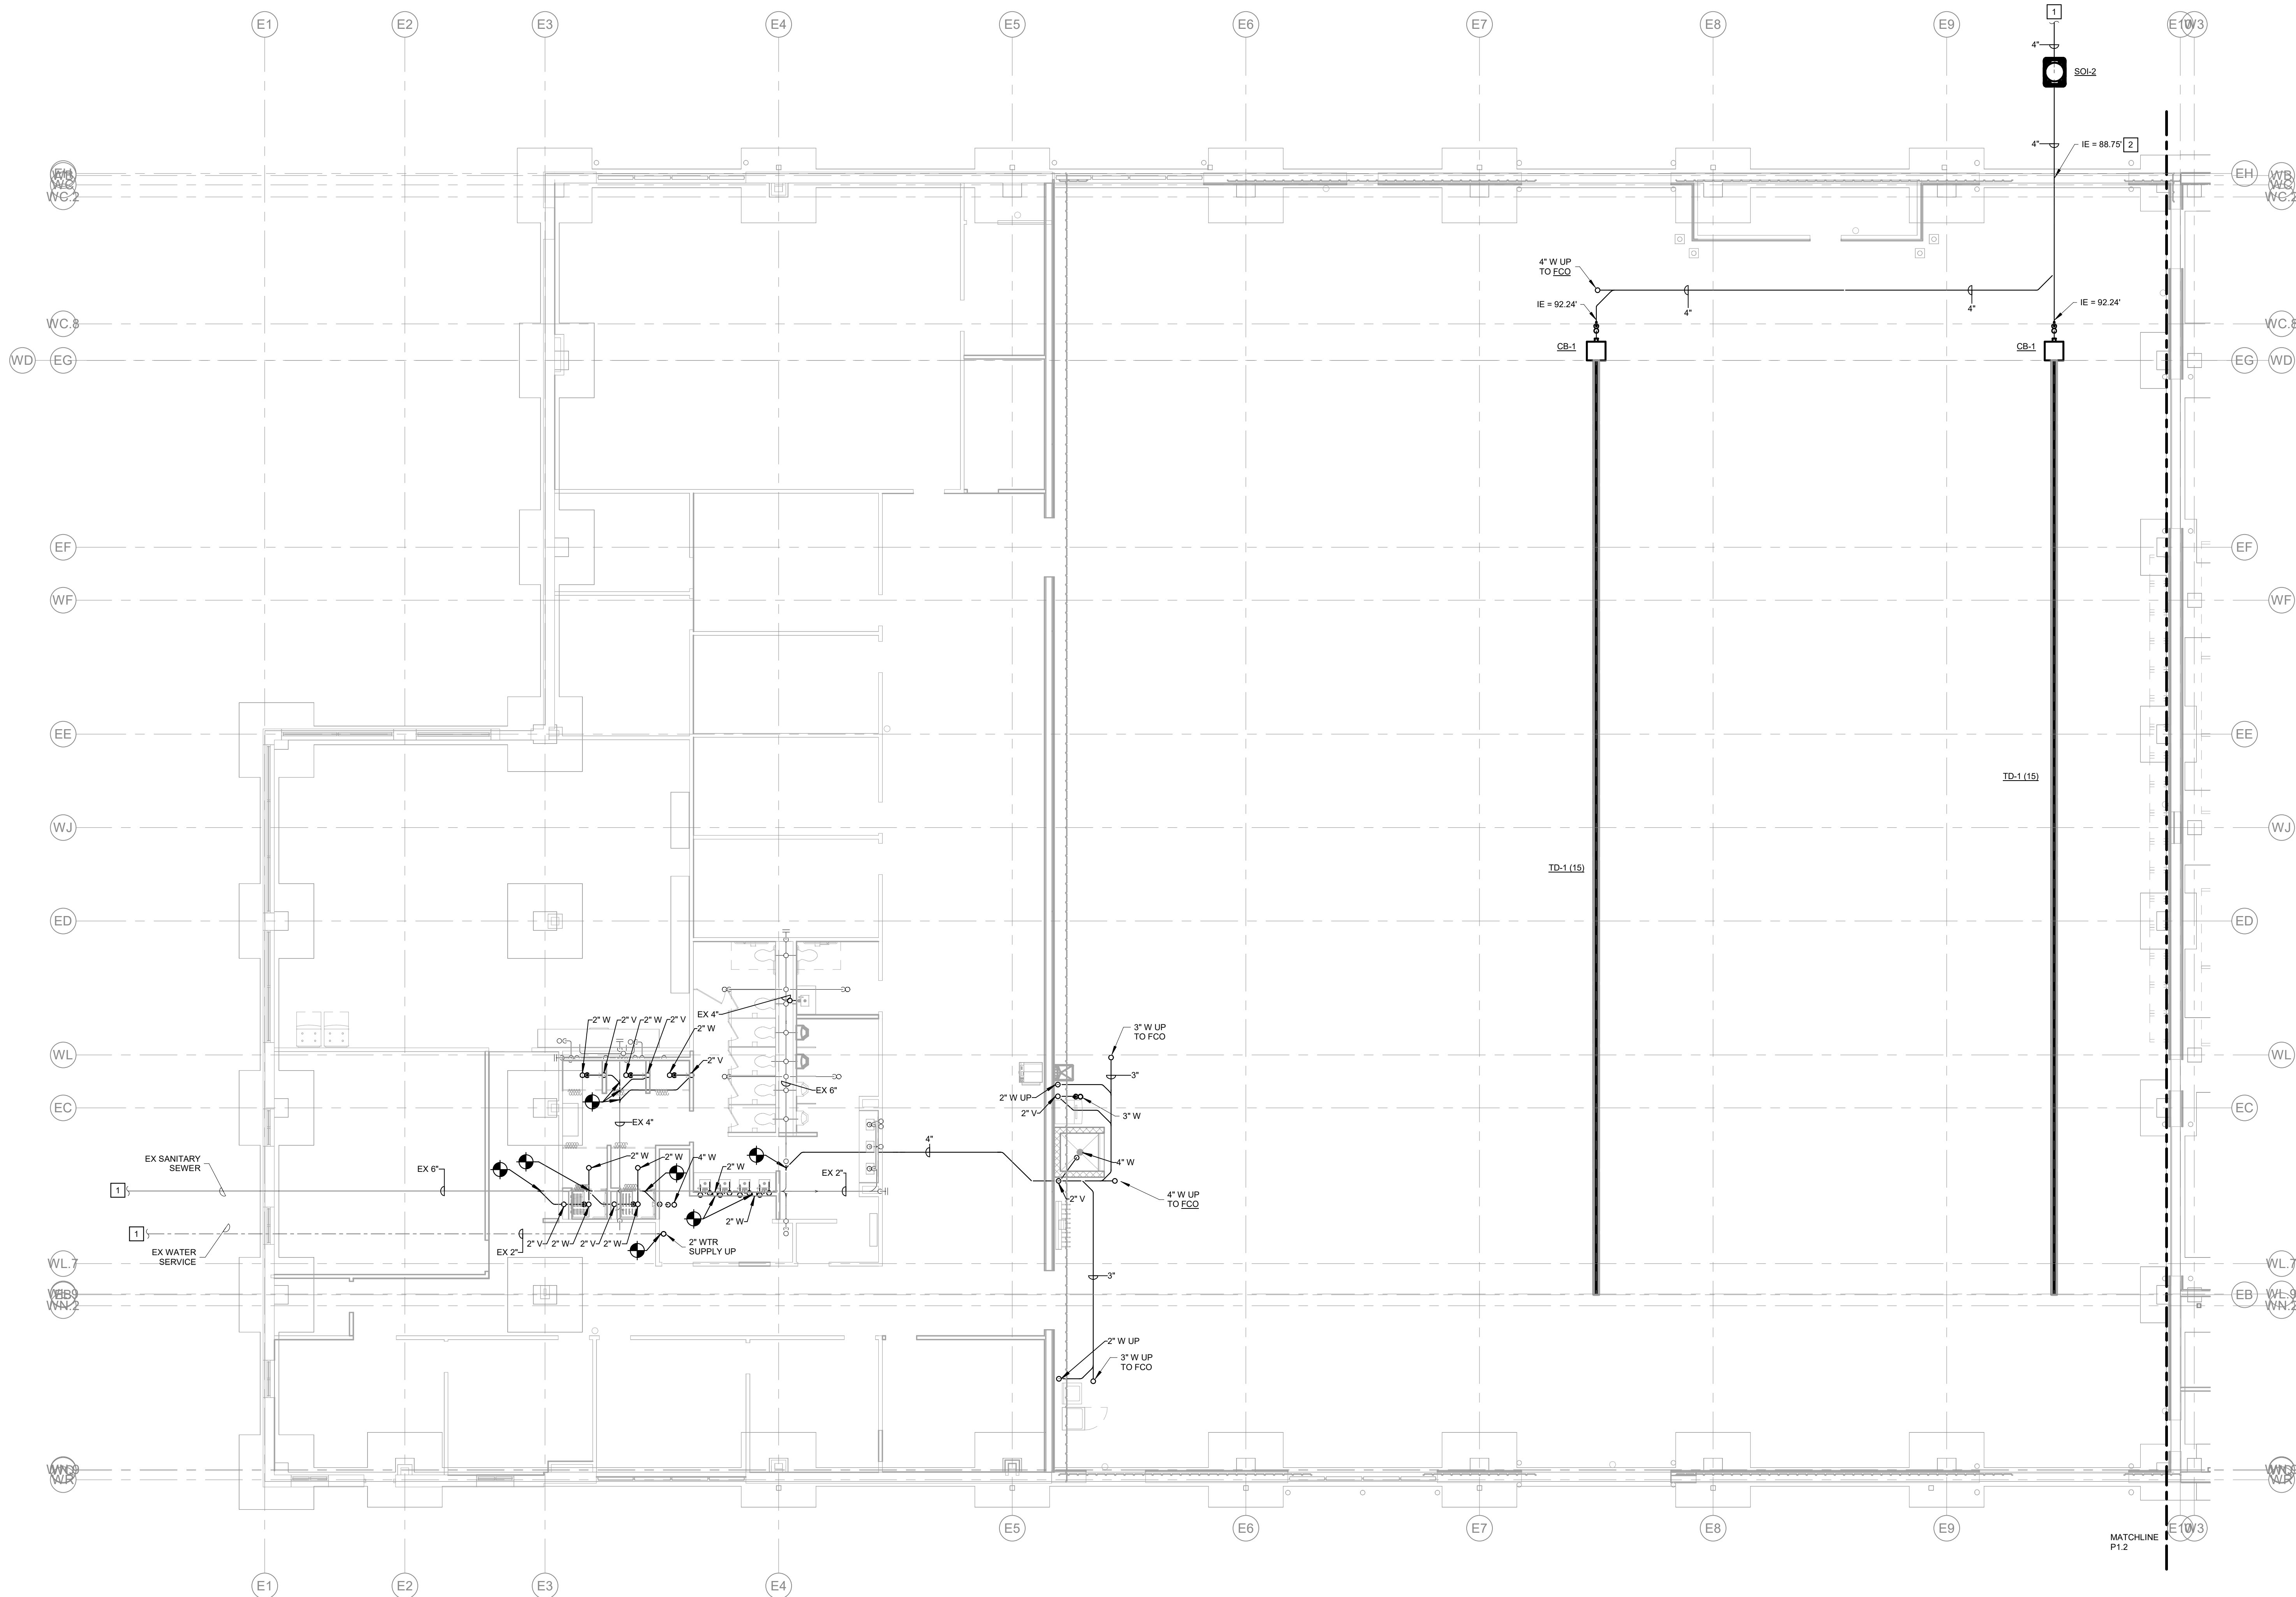


PLUMBING UNDERGROUND PLAN - OPERATIONS
SCALE: 1/8" = 1'-0"
NORTH

OPERATIONS

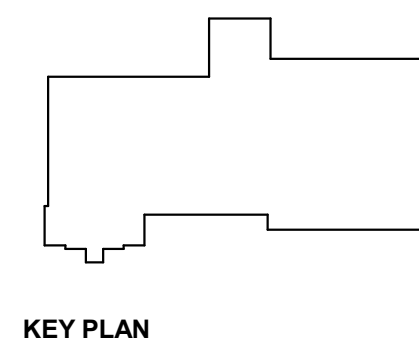

KEY PLAN

SSC JOB# 2025456

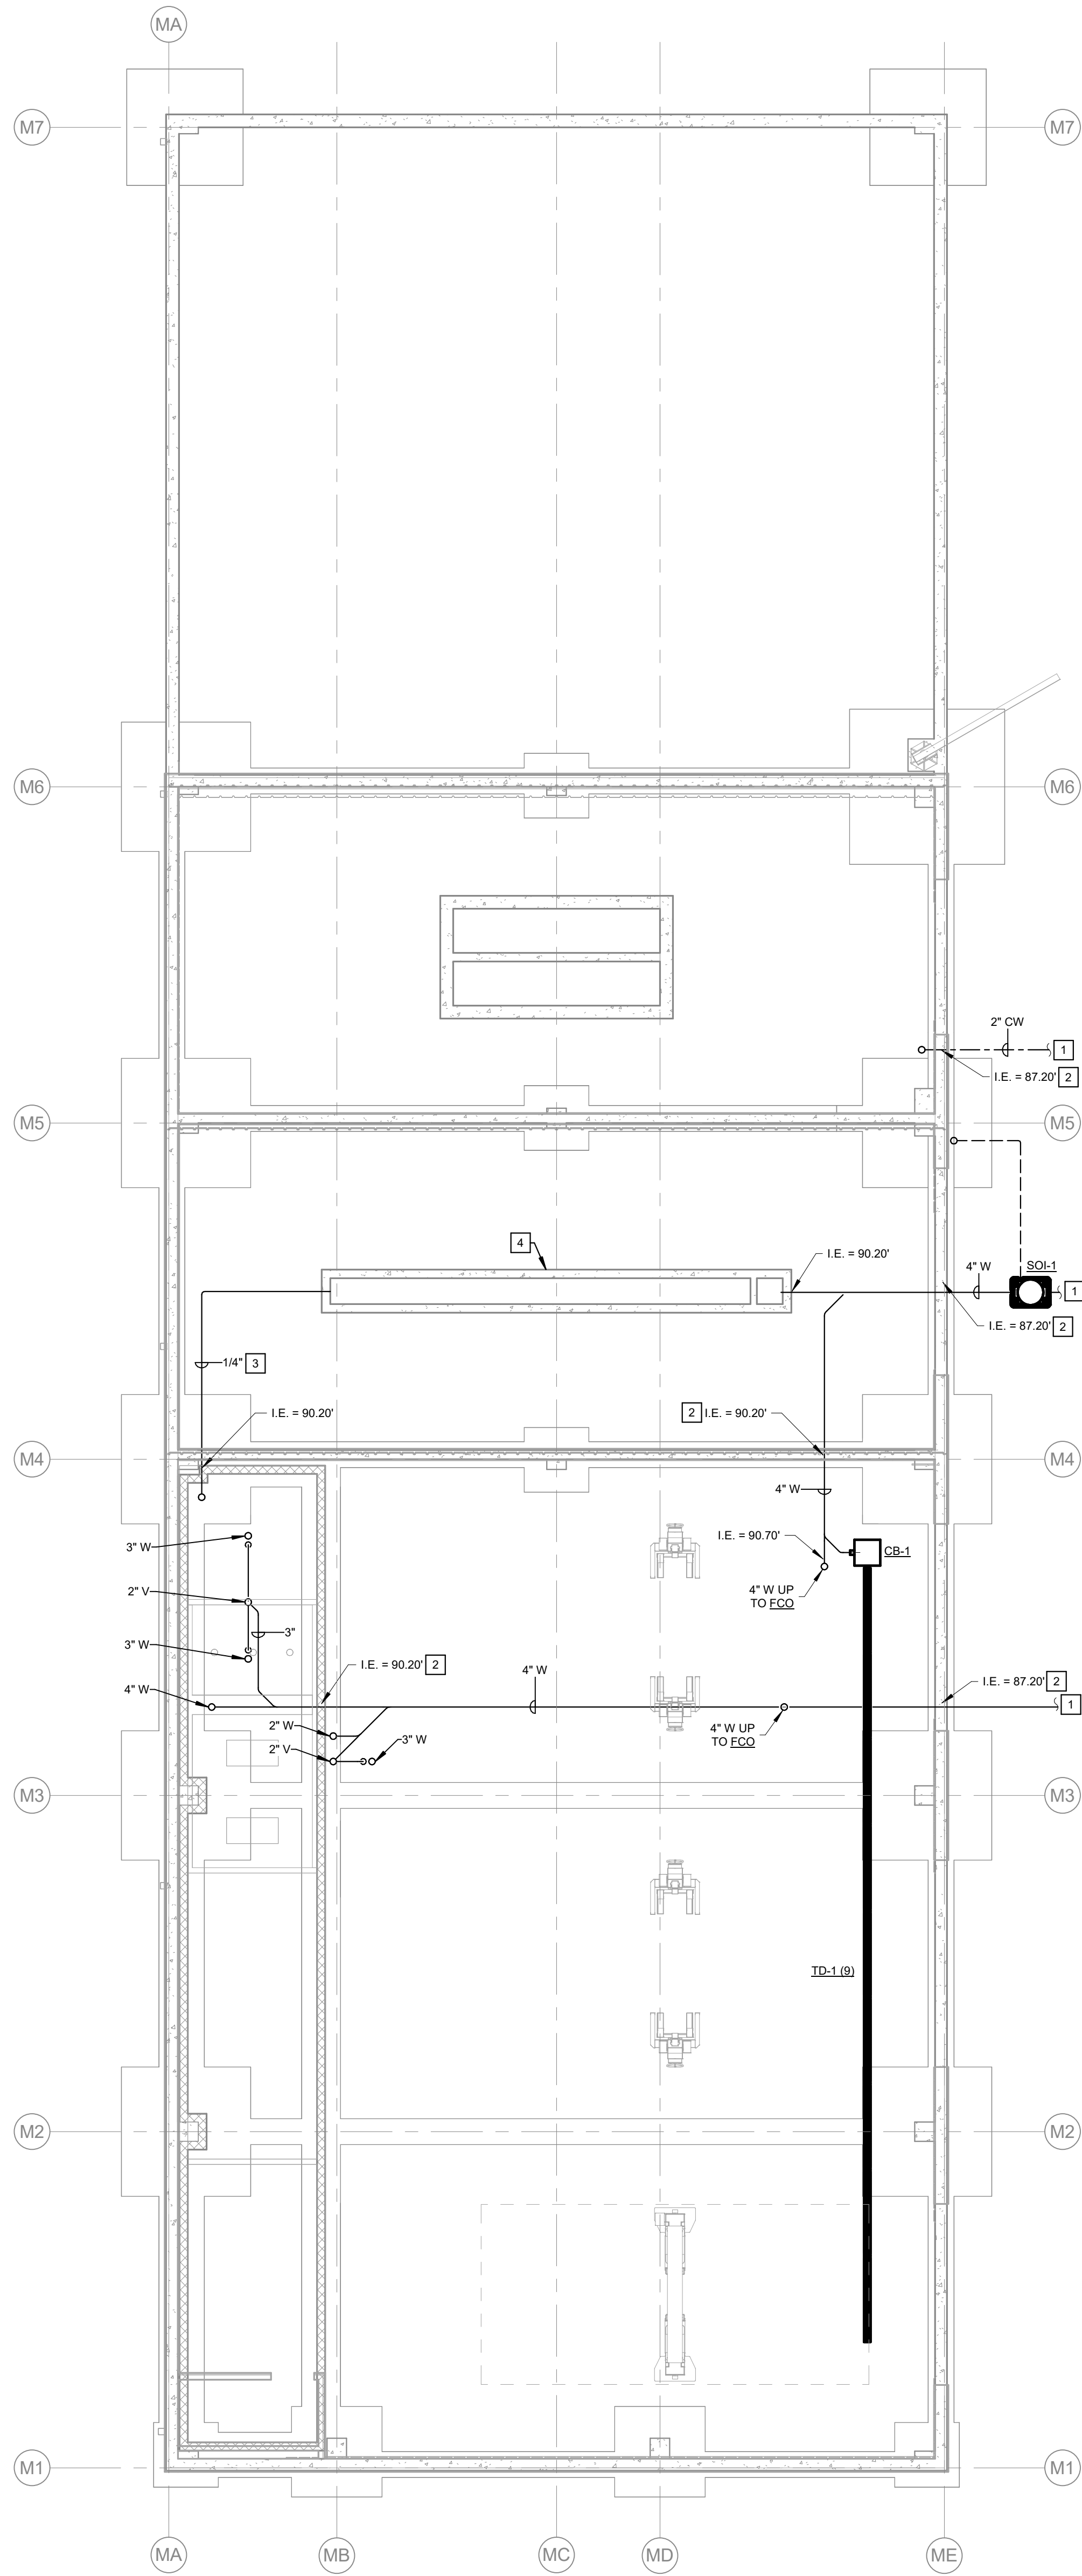

PLUMBING UNDERGROUND PLAN - MAINTENANCE
SCALE: 1/8" = 1'-0"
NORTH

GENERAL NOTES:

1. REFER TO SHEET PD.1 FOR SYMBOLS, ABBREVIATIONS AND GENERAL CONSTRUCTION NOTES.

KEYED NOTES:

- 1 SEE CIVIL FOR CONTINUATION.
2 COORDINATE WITH STRUCTURAL DETAIL #20 ON S0.4.
3 CHEMICAL PIPE.
4 COORDINATE WITH STRUCTURAL TRENCH DETAILS ON S1.3.

M+H
ARCHITECTS
ARCHITECT:
Mitchell and Hugelback Architects, Inc.
D.B.A. M+H Architects
12747 Olive Blvd., Suite 150
St. Louis, MO 63141
314-878-3500
www.mha.us.com

CONSULTANT:
SSC Engineering, Inc.
Michael K. Swim Consulting Engineer, Inc.
D.B.A SSC Engineering, Inc.
18207 Edison Ave.
St. Louis, MO 63005
636-530-7770
Corporate License No.: 001244


COOPERATIVE
BUILDING SOLUTIONS

TAYLOR COUNTY RECC

685 WATER TOWER BYPASS
CAMBELLSVILLE, KY 42718



CHRISTIAN W. HULETT
Professional Engineer
KY LIC#: 29287
EXP: 06/30/2027

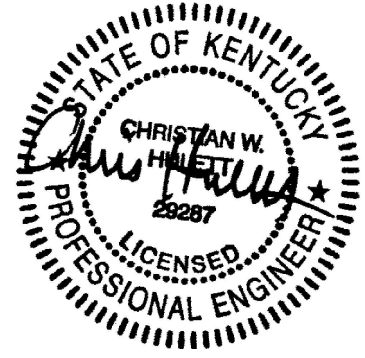

08/20/2026
The Seal and Signature apply only to the Document to which they are Affixed, and Expressly Disclaim any Responsibility for all other Plans, Specifications, Estimates, Reports, or other Documents or Instruments relating to or intended to be used for any part or parts of the Architectural or Engineering Project.
Copyright © 2026 by SSC Engineering

REVISION:

100% CONSTRUCTION DOCUMENTS 08/20/2026

Sheet Issue Date: 08/20/2026

Job Number: 250120.00

Drawn By: CMW


Checked By: MEL

Drawing Title:

**PLUMBING
UNDERGROUND PLAN
- MAINTENANCE**

P1.3

SSC JOB# 2025456

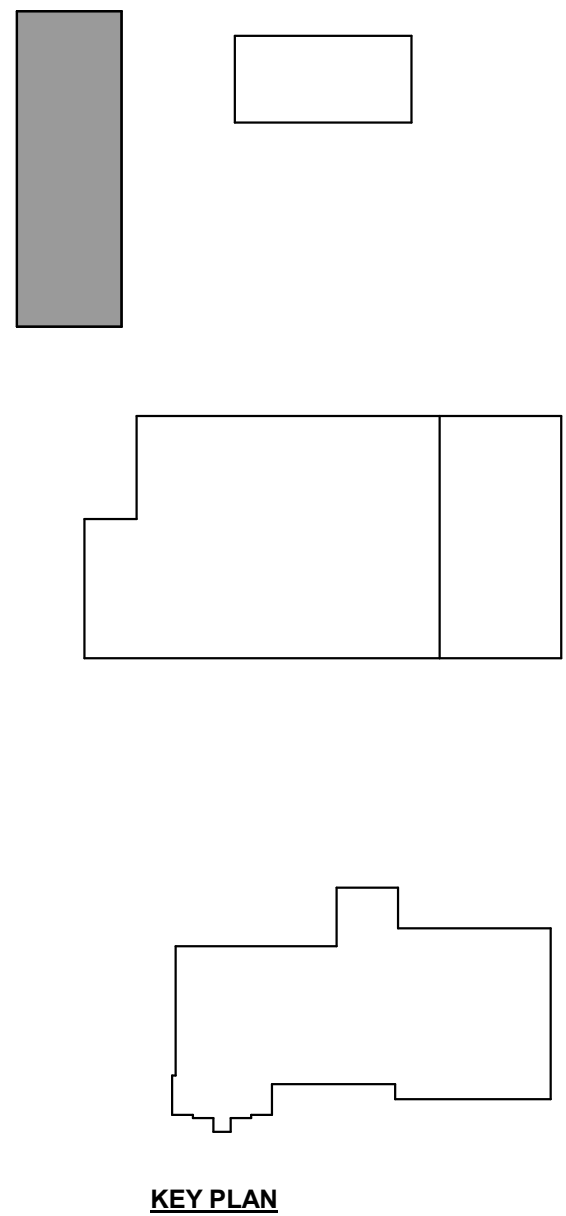

TAYLOR COUNTY RECC

685 WATER TOWER BYPASS
CAMBELLSVILLE, KY 42718CHRISTIAN W. HULETT
Professional Engineer
KY LIC#: 29287
EXP: 06/30/2027

08/20/2026

The Seal and Signature apply only to the Document to which they are Affixed, and Expressly Disclaim any Responsibility for all other Plans, Specifications, Estimates, Reports, or other Documents or Instruments relating to or intended to be used for any part or parts of the Architectural or Engineering Project.

Copyright © 2026 by SSC Engineering

REVISION:

100% CONSTRUCTION DOCUMENTS	08/20/2026
-----------------------------	------------

Sheet Issue Date:	08/20/2026
Job Number:	250120.00
Drawn By:	CMW
Checked By:	MEL
Drawing Title:	

PLUMBING
UNDERGROUND PLAN
- OFFICE


P1.4

PLUMBING GENERAL NOTES:


1. REFER TO SHEET P0.1 FOR SYMBOLS, ABBREVIATIONS AND GENERAL CONSTRUCTION NOTES.

PLUMBING KEYED NOTES:

- 1 SEE CIVIL DRAWINGS FOR CONTINUATION.
2 COORDINATE WITH STRUCTURAL DETAIL 20' S0.4.

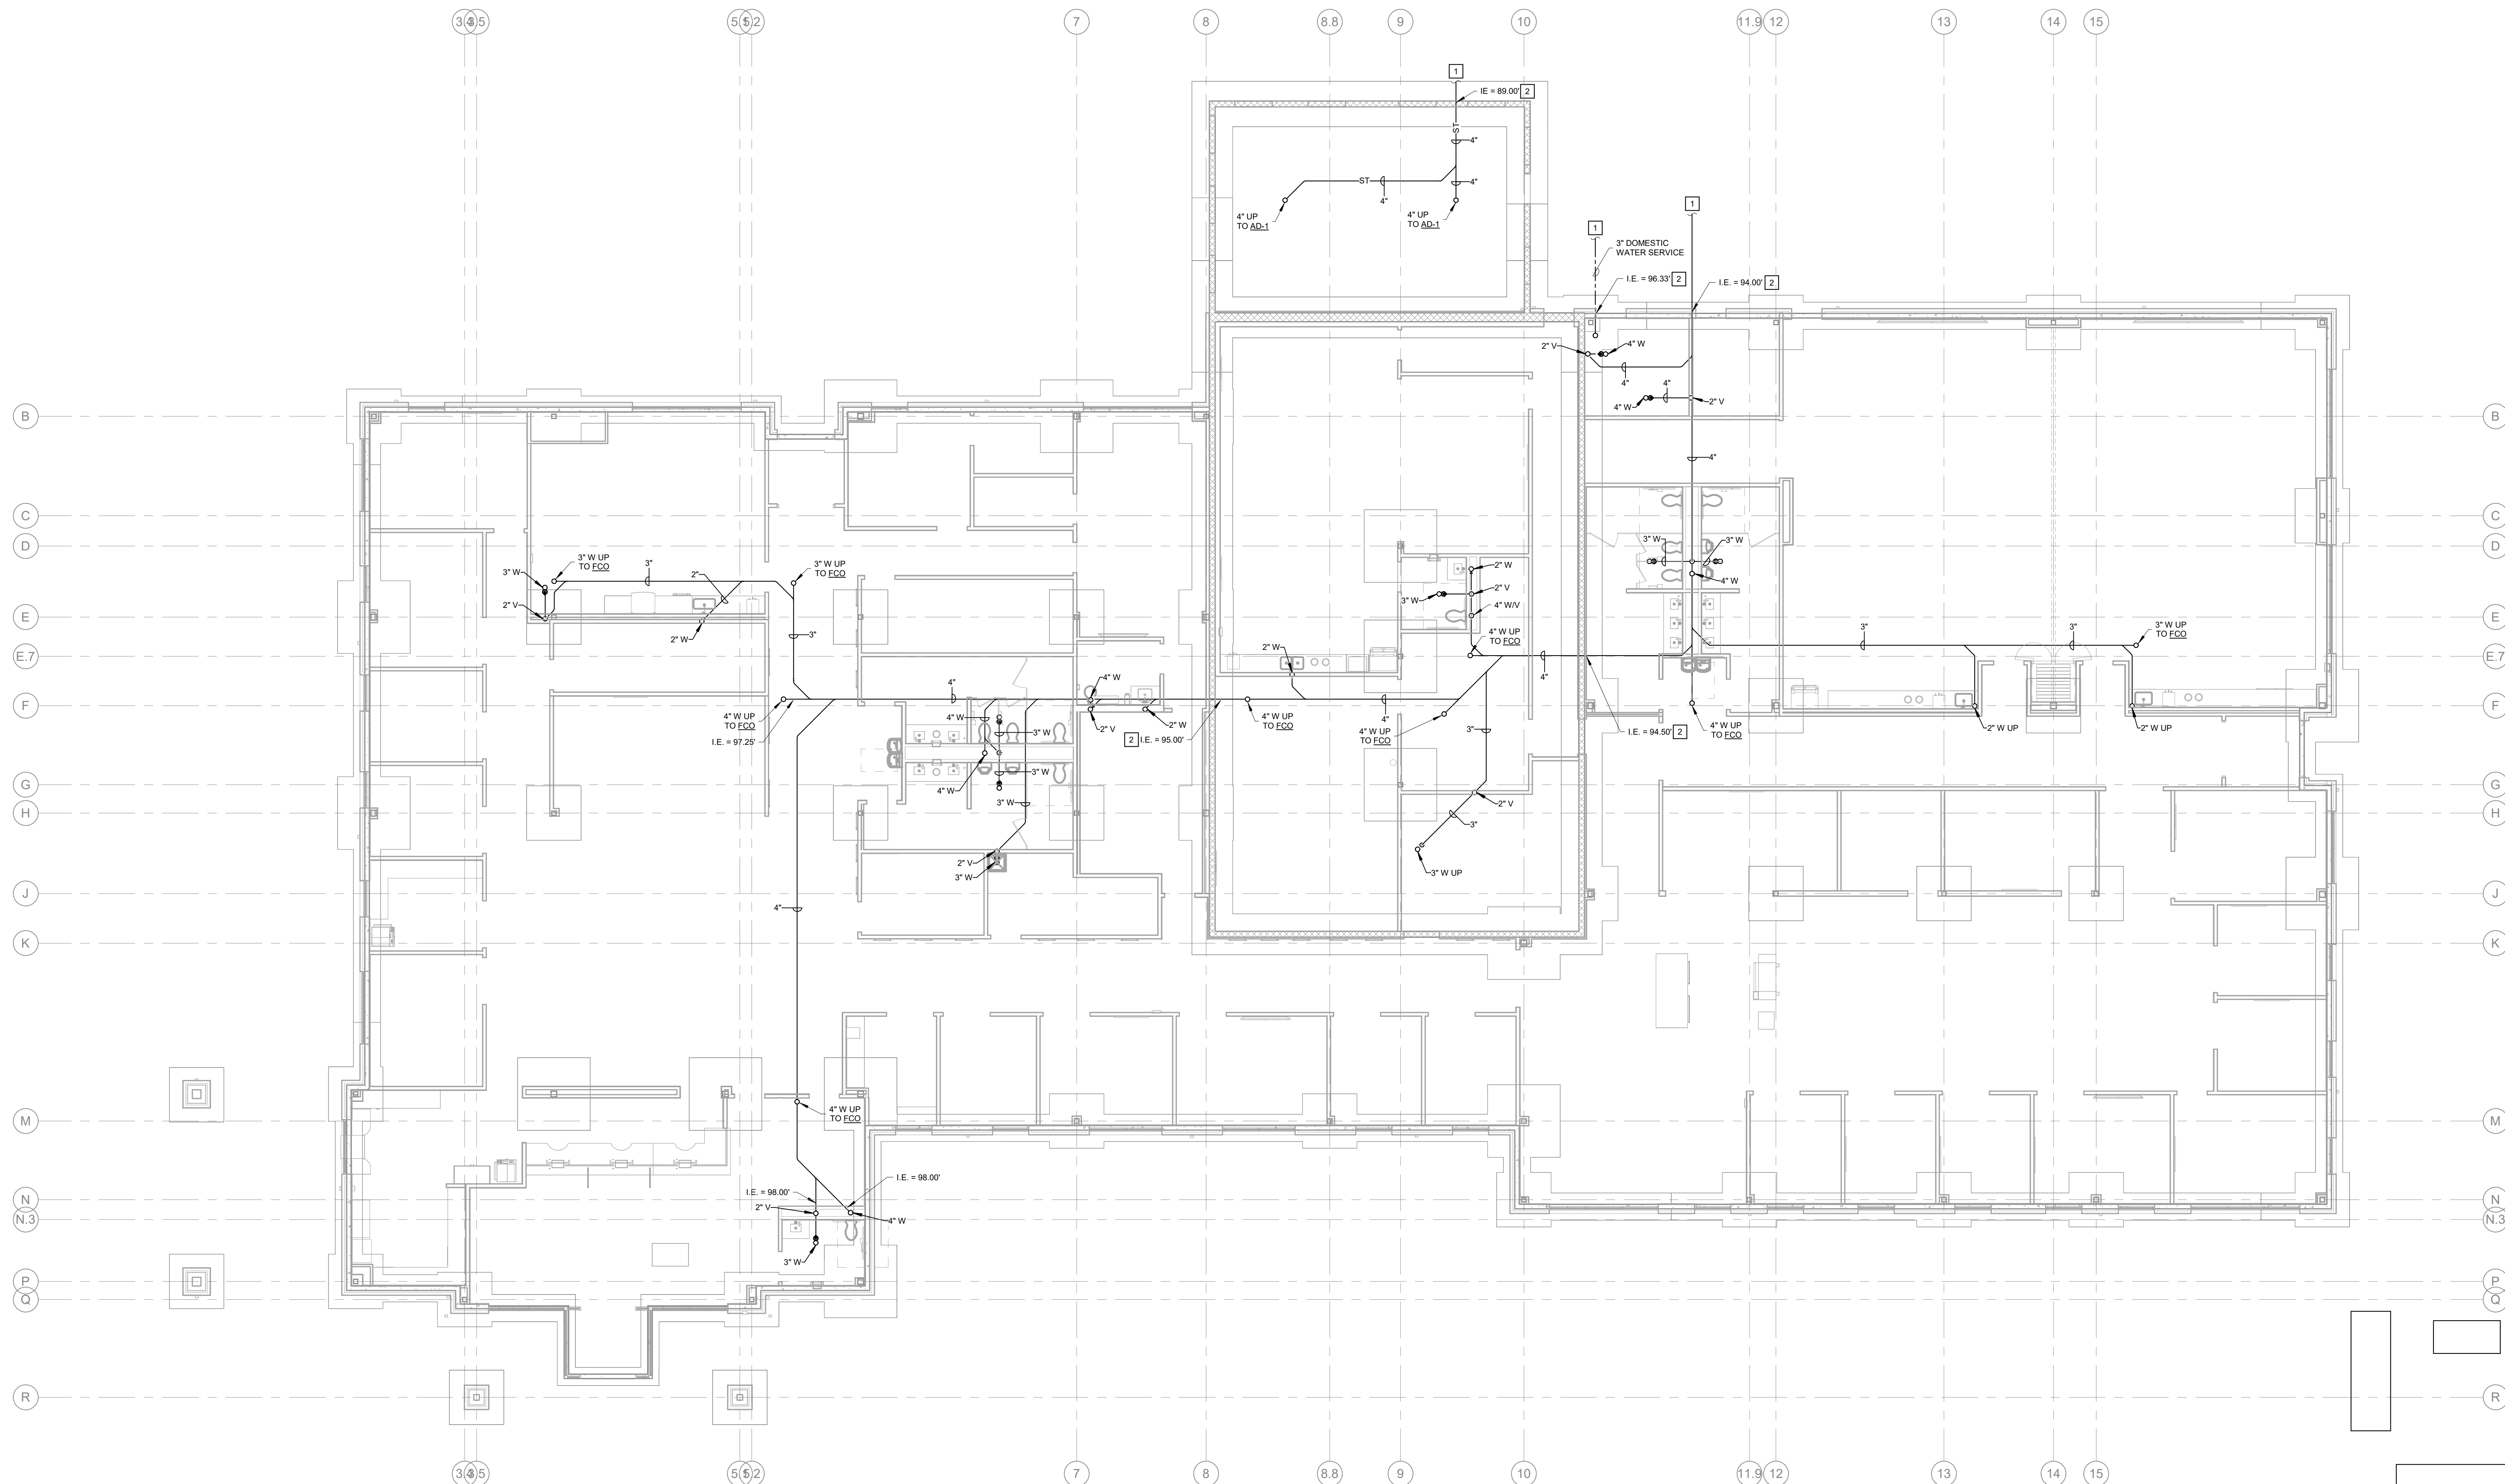

PLUMBING UNDERGROUND PLAN - OFFICE
SCALE: 1/8" = 1'-0"
NORTH

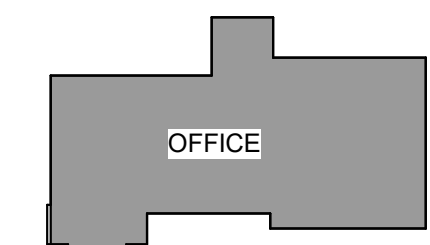

KEY PLAN

SSC JOB# 2025456

TAYLOR COUNTY RECC
685 WATER TOWER BYPASS
CAMBELLSVILLE, KY 42718



CHRISTIAN W. HULETT
Professional Engineer
KY LIC#: 29287
EXP: 06/30/2027



08/20/2026
The Seal and Signature apply only to the Document to which they are Affixed, and Expressly Disclaim any Responsibility for all other Plans, Specifications, Estimates, Reports, or other Documents or Instruments relating to or intended to be used for any part or parts of the Architectural or Engineering Project.
Copyright © 2026 by SSC Engineering

REVISION:
100% CONSTRUCTION DOCUMENTS 08/20/2026

Sheet Issue Date: 08/20/2026

Job Number: 250120.00

Drawn By: CMW

Checked By: MEL

Drawing Title:

PLUMBING WASTE
AND VENT PLAN -
OPERATIONS

P2.1

SSC JOB# 2025456

GENERAL NOTES:



1. REFER TO SHEET P0.1 FOR SYMBOLS, ABBREVIATIONS AND GENERAL CONSTRUCTION NOTES.

KEYED NOTES:


- EXISTING TO REMAIN.
- EXISTING SALVAGED FIXTURE NEW LOCATION.
- TWO HOUR FIRE WALL, PATCH AND SEAL FOR ULR419 RATED ASSEMBLY.



FIRST FLOOR PLUMBING WASTE AND VENT PLAN - OPERATIONS
SCALE: 1/8" = 1'-0"
NORTH
F.F.E. = 93.74' (CIVIL = 888.04')

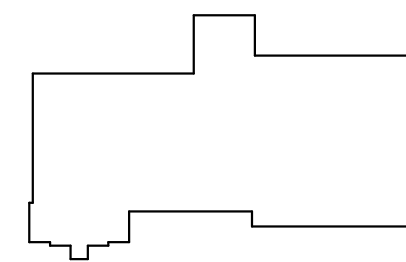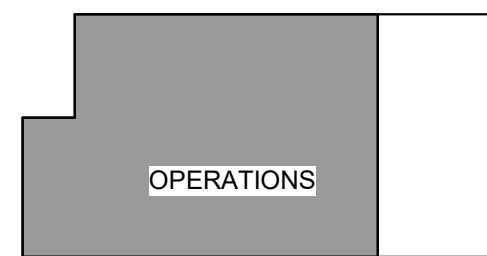

KEY PLAN

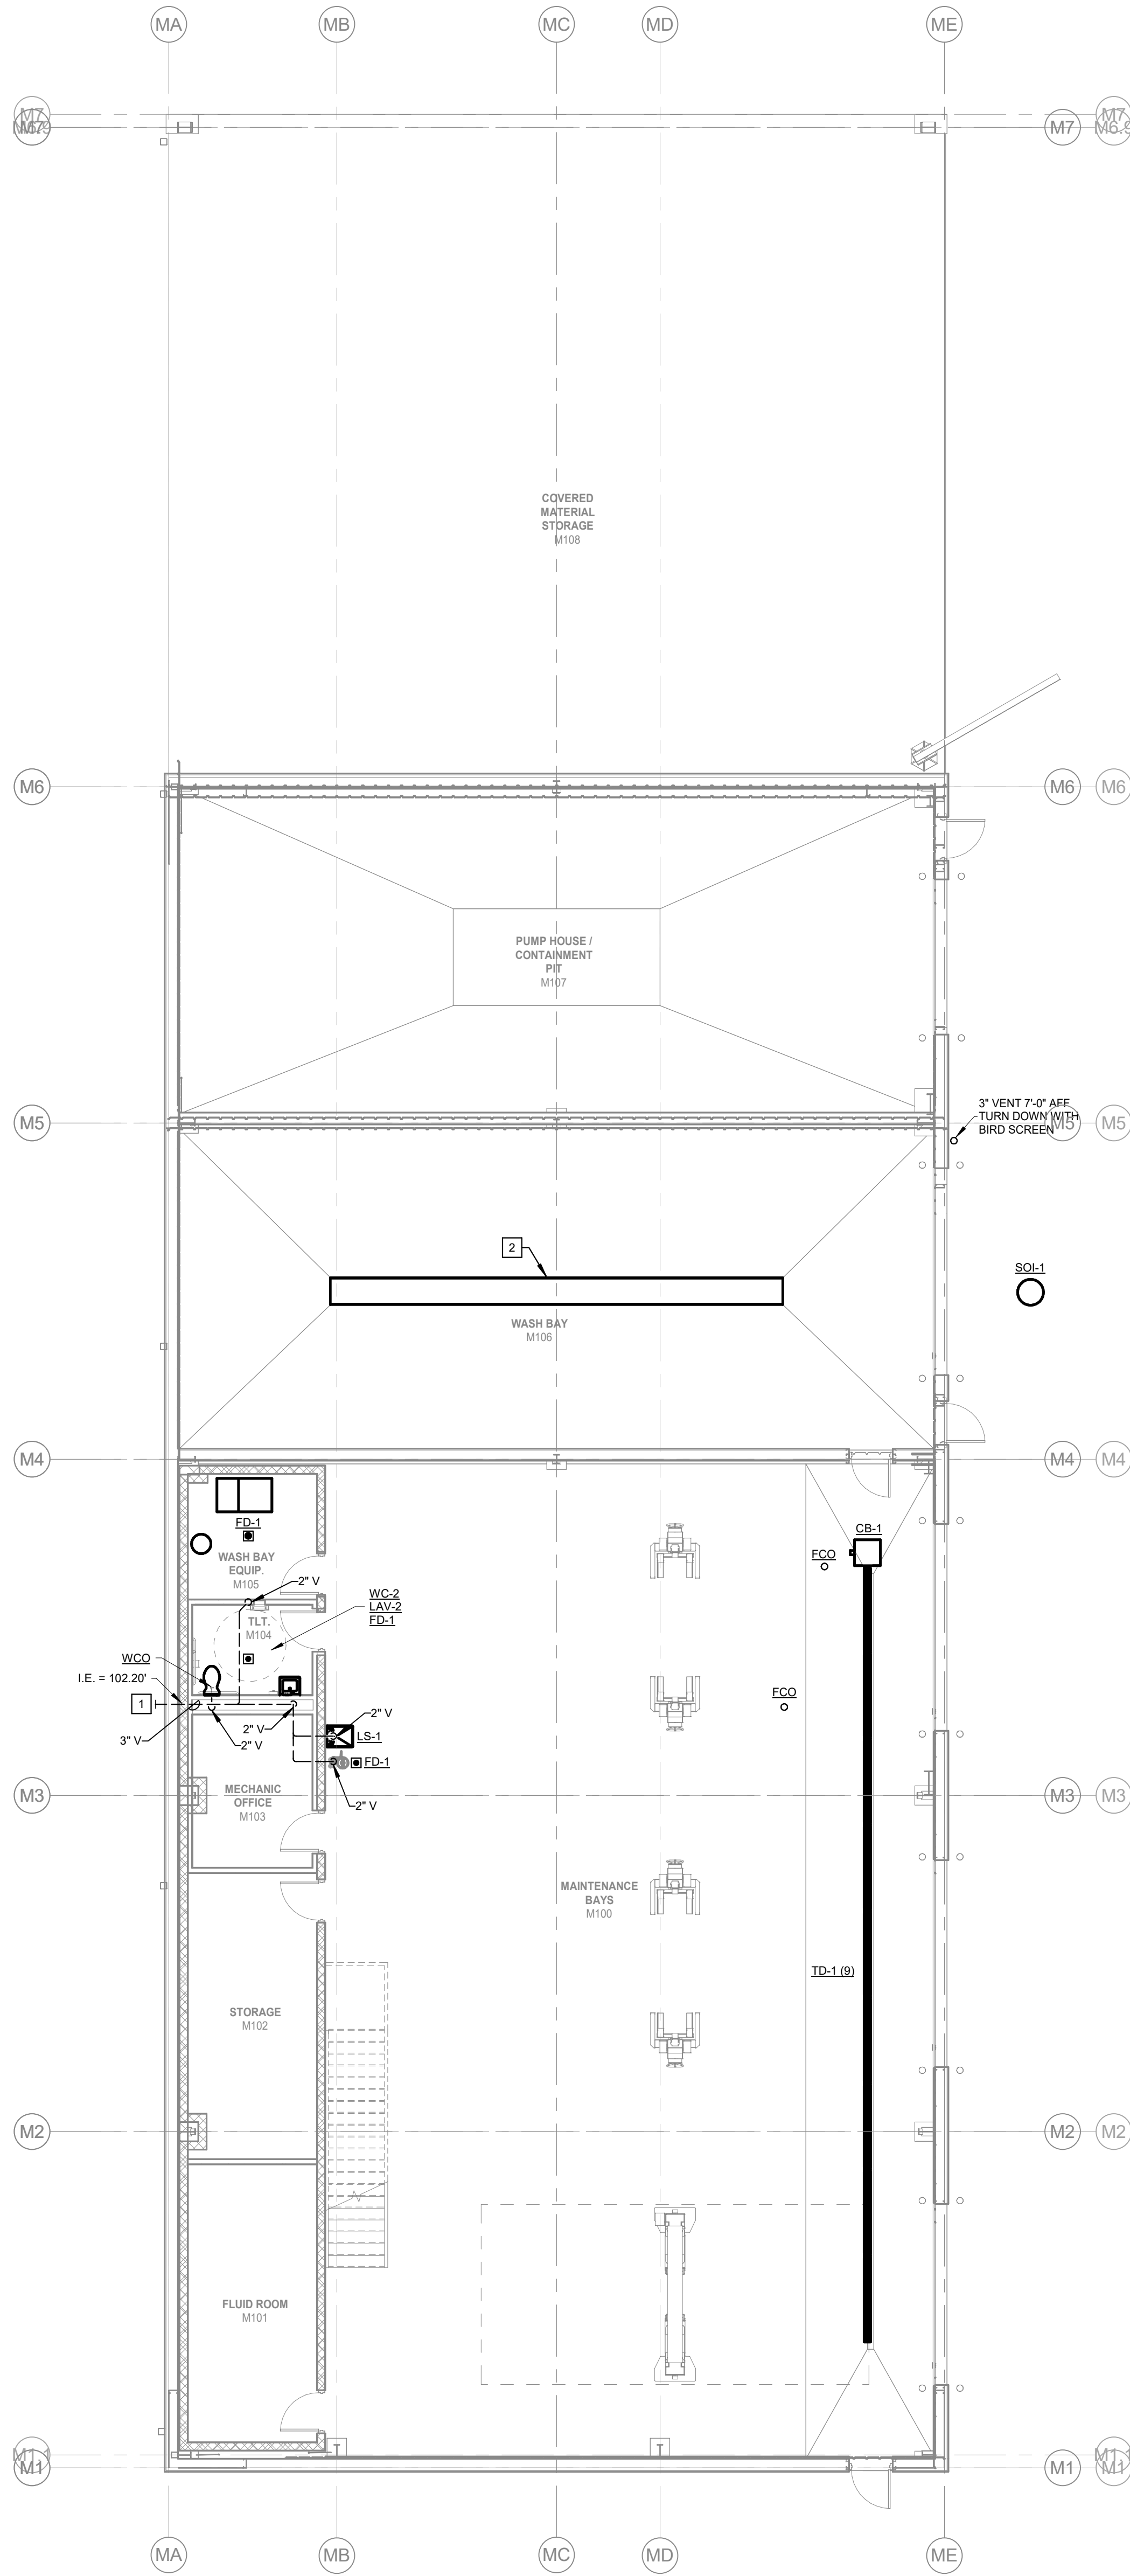


FIRST FLOOR PLUMBING WASTE AND VENT PLAN - MAINTENANCE
SCALE: 1/8" = 1'-0" F.F.E. = 92.20' (CIVIL = 887.50')
NORTH

GENERAL NOTES:

1. REFER TO SHEET PD.1 FOR SYMBOLS, ABBREVIATIONS AND GENERAL CONSTRUCTION NOTES.

KEYED NOTES:

1. SIDE WALL VENT. PROVIDE EXTERIOR VENT CAP WITH BIRDSCREEN. FAMCO 3" VENT THROUGH WALL. BAWWH WITH SCREEN AND WITHOUT DAMPER, OR APPROVED EQUAL. PAINT TO MATCH BUILDING. COORDINATE MOUNTING HEIGHT WITH ARCHITECTURAL AND STRUCTURAL PRIOR TO INSTALLATION.
2. COORDINATE WITH STRUCTURAL DETAILS FOR TRENCH PIT.

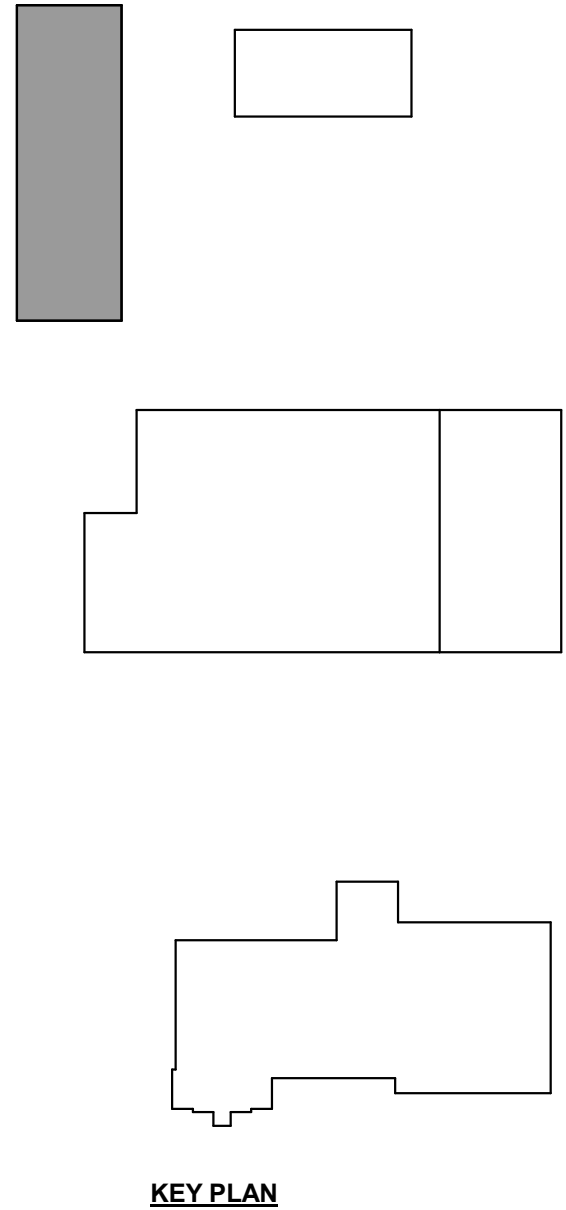

REVISION:		
100% CONSTRUCTION DOCUMENTS	08/20/2026	

Sheet Issue Date:	08/20/2026
Job Number:	250120.00
Drawn By:	CMW
Checked By:	MEL



Drawing Title:
PLUMBING WASTE AND VENT PLAN - MAINTENANCE

PLUMBING GENERAL NOTES:

1. REFER TO SHEET P0.1 FOR SYMBOLS, ABBREVIATIONS AND GENERAL CONSTRUCTION NOTES.

PLUMBING KEYED NOTES:

1. PROVIDE EXTERIOR VENT CAP WITH BIRDSCREEN. FAMCO 3" VENT THROUGH WALL. #1/4"X1/2" WITH SCREEN AND WITHOUT DAMPER. OR APPROVED EQUAL. PAINT TO MATCH BUILDING. COORDINATE MOUNTING HEIGHT WITH ARCHITECTURAL AND STRUCTURAL PRIOR TO INSTALLATION.
2. STORM SHELTER EXTENTS. SEE ARCH DRAWINGS.
3. ALL STORM SHELTER PENETRATIONS LARGER THAN 2-1/8" DIA. SHALL BE PROTECTED FROM IMPACT.

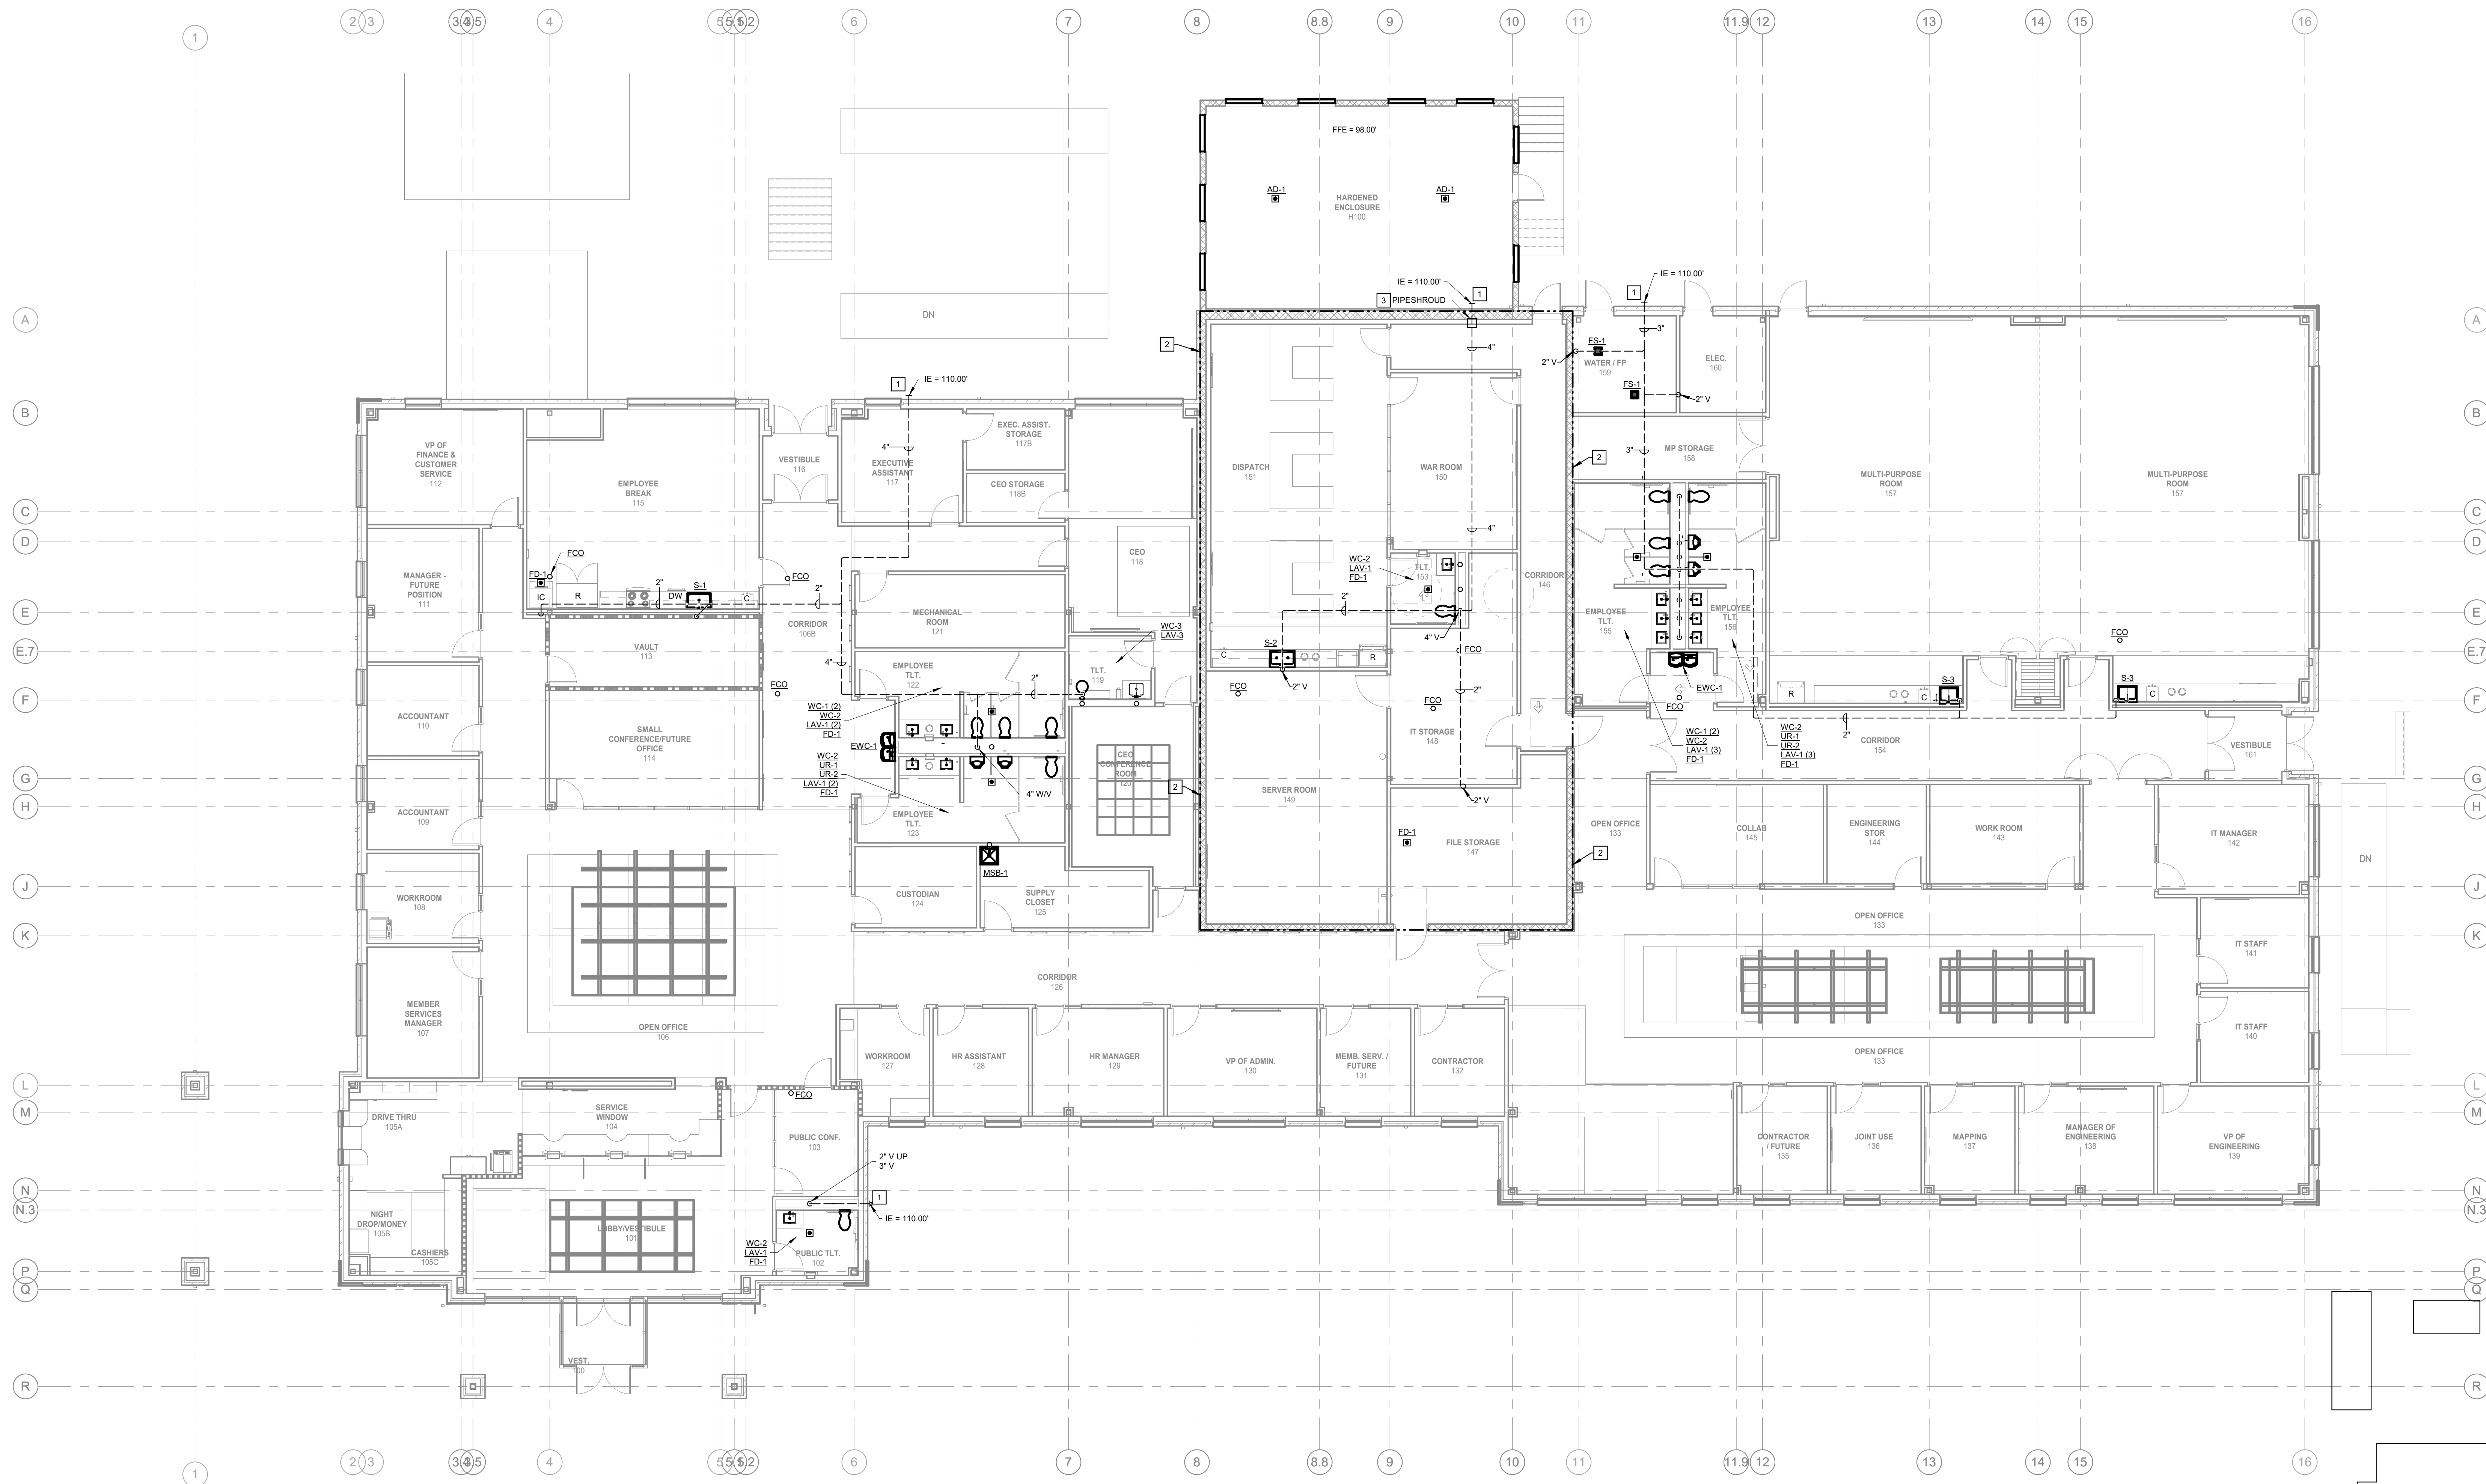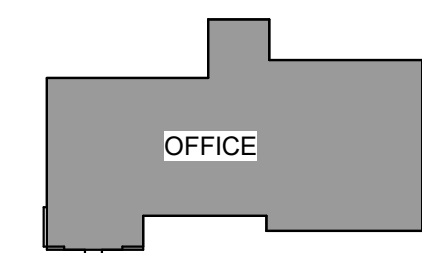FIRST FLOOR PLUMBING WASTE AND VENT PLAN - OFFICE
SCALE: 1/8" = 1'-0"
NORTH
F.F.E. = 100.00' (CIVIL = 895.30')

KEY PLAN

SSC JOB# 2025456

TAYLOR COUNTY RECC

685 WATER TOWER BYPASS
CAMBELLSVILLE, KY 42718CHRISTIAN W. HULETT
Professional Engineer
KY LIC#: 29287
EXP: 06/30/2027

08/20/2026

The Seal and Signature apply only to the Document to which they are Affixed, and Expressly Disclaim any Responsibility for all other Plans, Specifications, Estimates, Reports, or other Documents or Instruments relating to or intended to be used for any part or parts of the Architectural or Engineering Project.
Copyright © 2026 by SSC Engineering

REVISION:
100% CONSTRUCTION DOCUMENTS 08/20/2026

Sheet Issue Date: 08/20/2026

Job Number: 250120.00

Drawn By: CMW

Checked By: MEL

Drawing Title:

PLUMBING DOMESTIC
WATER PLAN -
OPERATIONS

P3.1

SSC JOB# 2025456

GENERAL NOTES:


1. REFER TO SHEET P0.1 FOR SYMBOLS, ABBREVIATIONS AND GENERAL CONSTRUCTION NOTES.

KEYED NOTES:

1. EXISTING TO REMAIN.
2. EXISTING SALVAGED FIXTURE NEW LOCATION.
3. PROVIDE DISHWASHER ROUGH-IN FROM HOT WATER SUPPLY AT SINK.
4. COORDINATE LOCATION WITH OWNER PRIOR TO INSTALLATION FOR FINAL EQUIPMENT LOCATION.
5. TWO HOUR FIRE WALL, PATCH AND SEAL FOR ULRU419 RATED ASSEMBLY.
6. CONNECT TO EXISTING WATER PIPE IN CHASE.

FIRST FLOOR PLUMBING DOMESTIC WATER PLAN - OPERATIONS
SCALE: 1/8" = 1'-0"
NORTH
F.F.E. = 93.74' (CIVIL = 889.04')

KEY PLAN

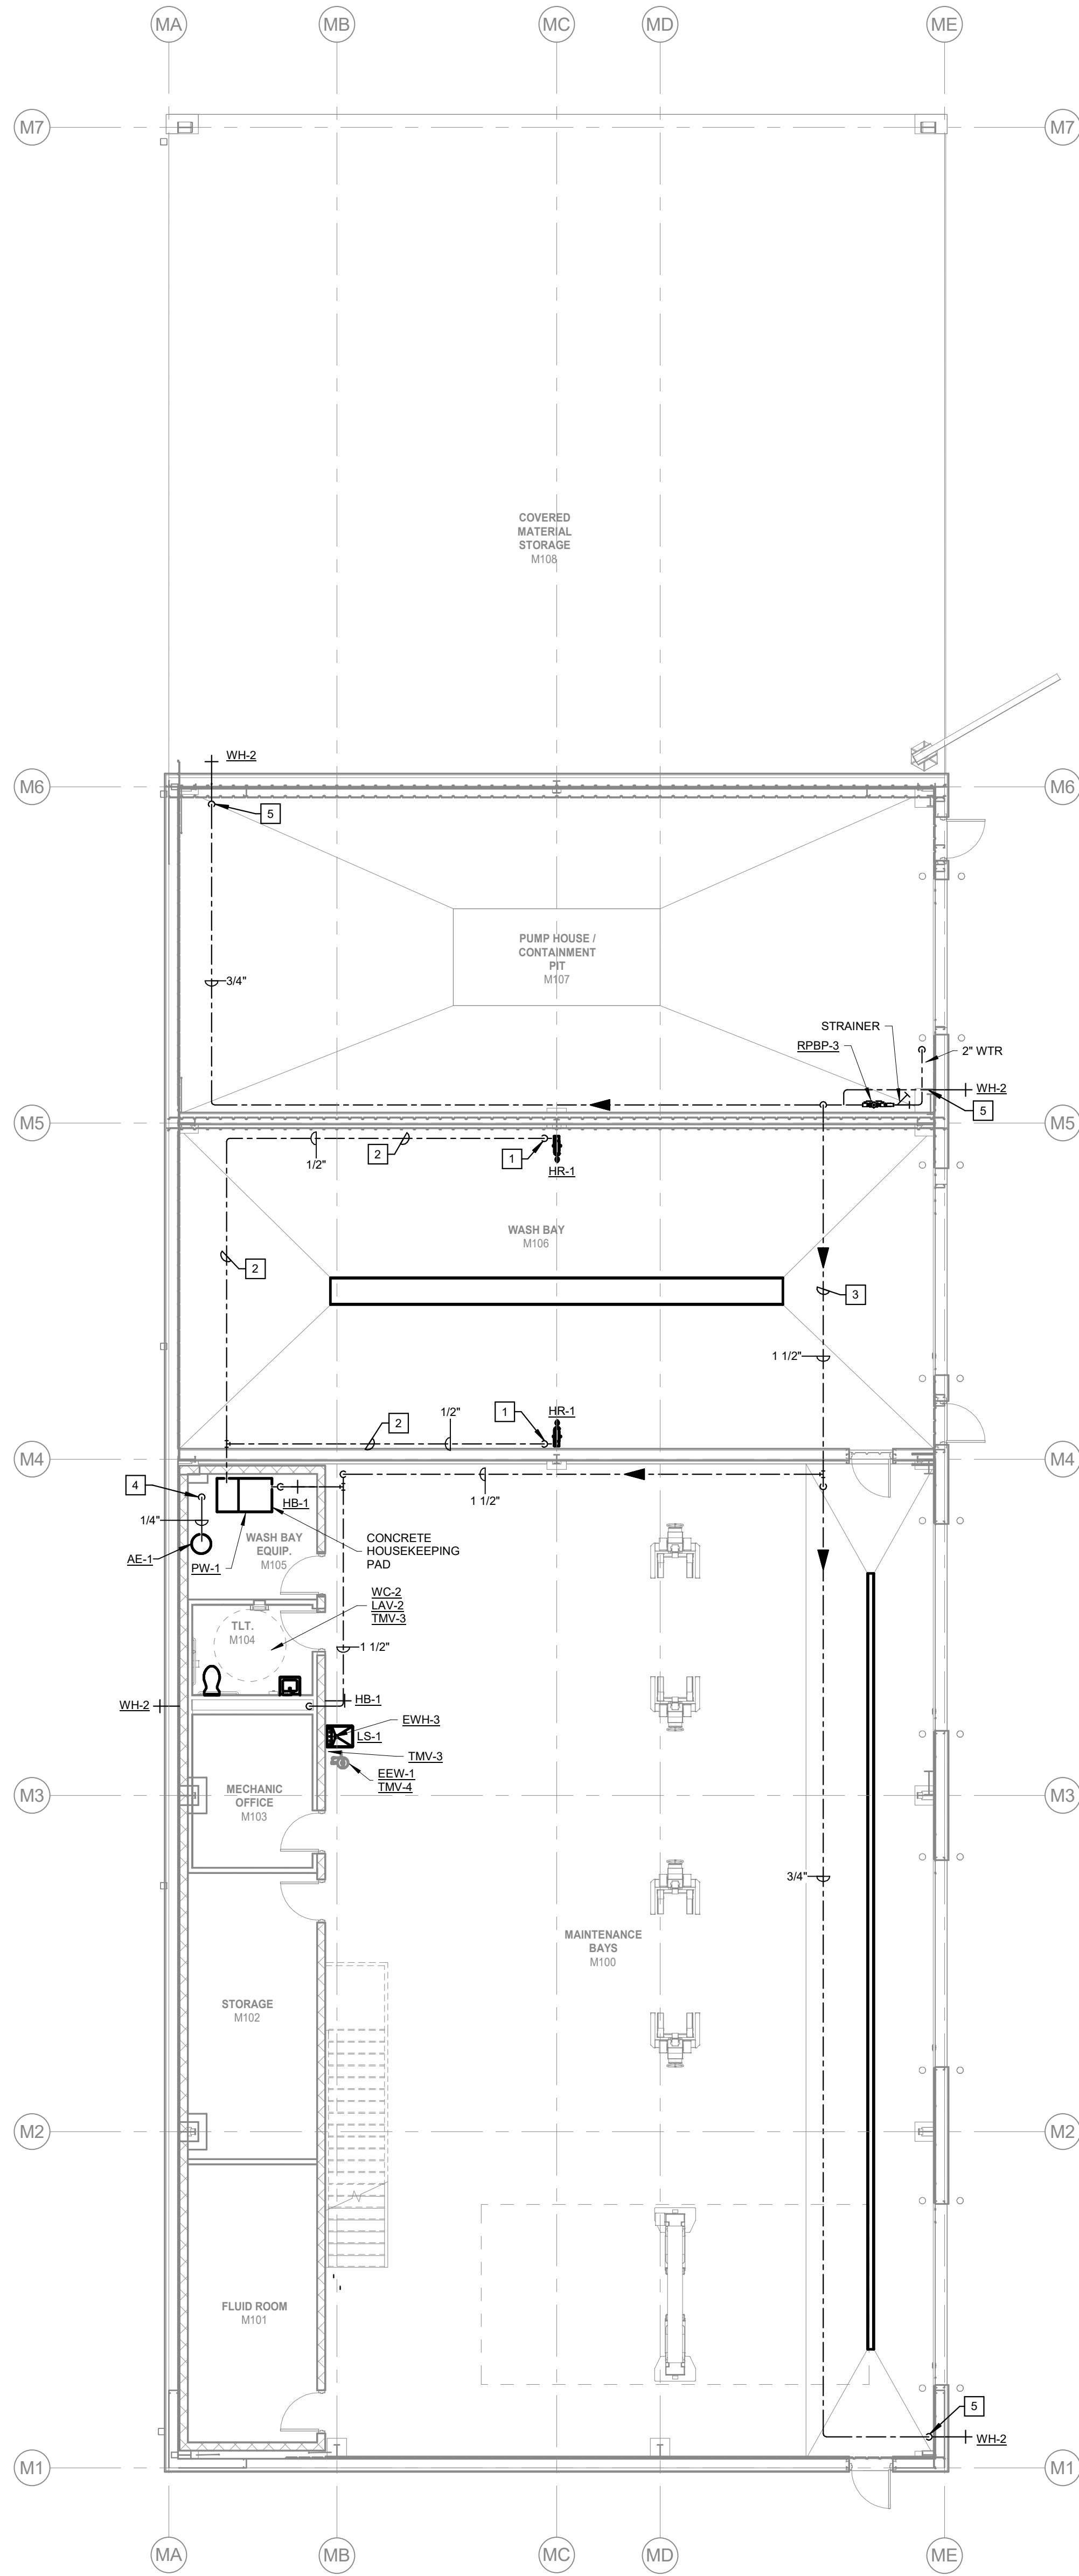


FIRST FLOOR PLUMBING DOMESTIC WATER PLAN - MAINTENANCE
SCALE: 1/8" = 1'-0" F.F.E. = 92.20' (CIVIL = 887.50')
NORTH

GENERAL NOTES:

1. REFER TO SHEET P0.1 FOR SYMBOLS, ABBREVIATIONS AND GENERAL CONSTRUCTION NOTES.

KEYED NOTES:

- 1. ROUGH-IN AND CONNECTION TO EQUIPMENT. PROVIDE FLEX HOSE AT CONNECTIONS.
- 2. PIPE ROUTED THROUGH WASH BAY SHALL HAVE ALUMINUM JACKET, SEALED WATER TIGHT. PIPE SHALL BE SEAMLESS SCHEDULED 80 BLACK IRON.
- 3. PIPE ROUTED THROUGH WASH BAY SHALL HAVE ALUMINUM JACKET, SEALED WATER TIGHT.
- 4. CHEMICAL PIPE ROUTED BELOW FLOOR TO TRENCH DRAIN. SEE DWG P1.3 FOR CONTINUATION.
- 5. PROVIDE SHUT OFF VALVE 48" AFF.

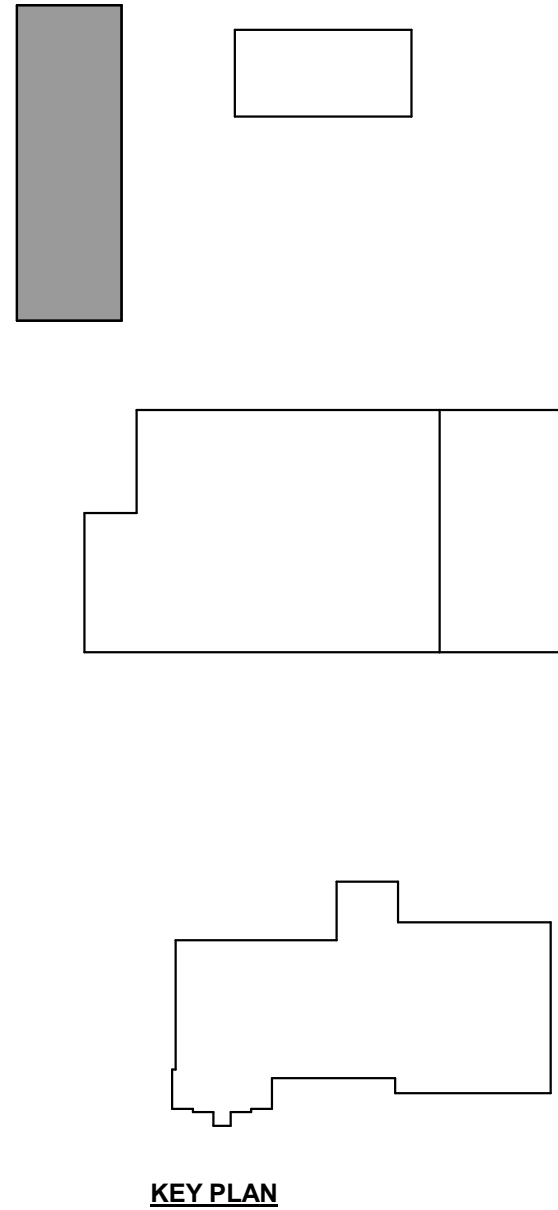

REVISION:

100% CONSTRUCTION DOCUMENTS	08/20/2026
-----------------------------	------------

Sheet Issue Date: 08/20/2026

Job Number: 250120.00

Drawn By: CMW

Checked By: MEL

Drawing Title:

PLUMBING DOMESTIC
WATER PLAN -
MAINTENANCE

TAYLOR COUNTY RECC

685 WATER TOWER BYPASS
CAMBELLSVILLE, KY 42718CHRISTIAN W. HULETT
Professional Engineer
KY LIC#: 29287
EXP: 06/30/2027

08/20/2026

The Seal and Signature apply only to the Document to which they are Affixed, and Expressly Disclaim any Responsibility for all other Plans, Specifications, Estimates, Reports, or other Documents or Instruments relating to or intended to be used for any part or parts of the Architectural or Engineering Project.

Copyright © 2026 by SSC Engineering

REVISION:
100% CONSTRUCTION DOCUMENTS
08/20/2026Sheet Issue Date: 08/20/2026
Job Number: 250120.00
Drawn By: CMW
Checked By: MEL
Drawing Title:PLUMBING DOMESTIC
WATER PLAN - OFFICE



P3.4

PLUMBING GENERAL NOTES:

1. REFER TO SHEET P0.1 FOR SYMBOLS, ABBREVIATIONS AND GENERAL CONSTRUCTION NOTES.


PLUMBING KEYED NOTES:

1. COORDINATE LOCATION WITH OWNER PRIOR TO INSTALLATION FOR FINAL EQUIPMENT LOCATION.

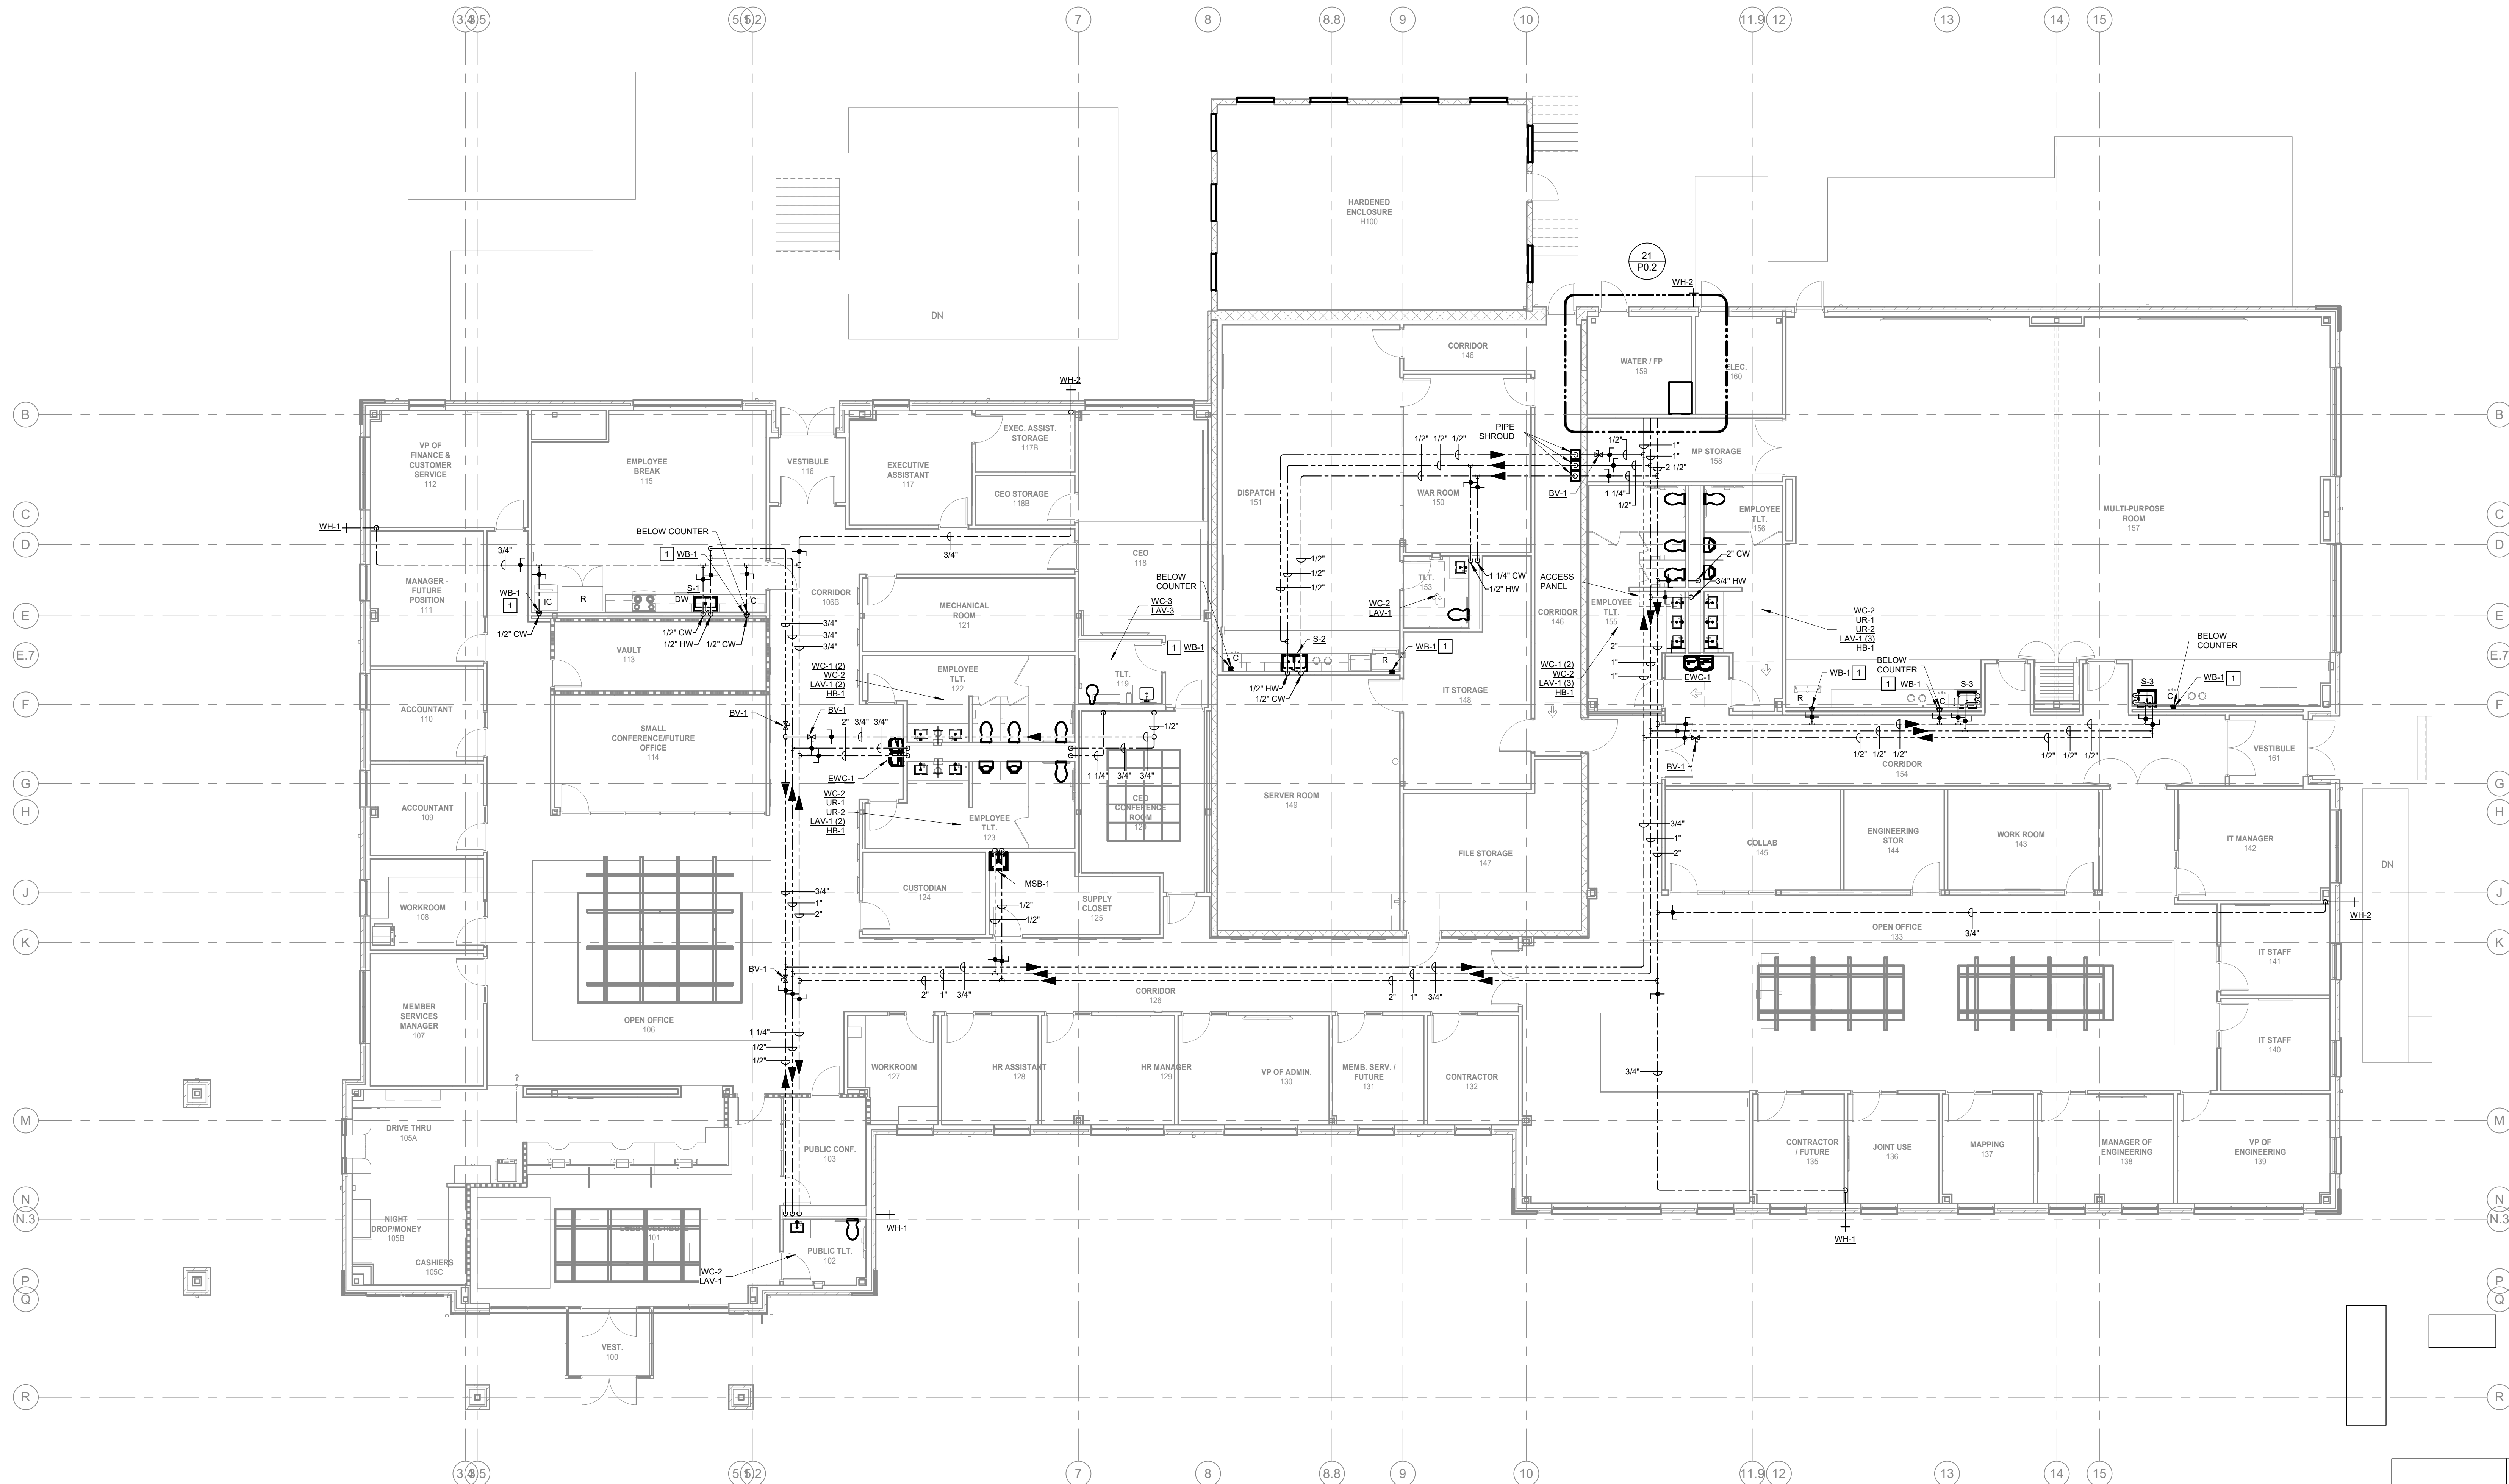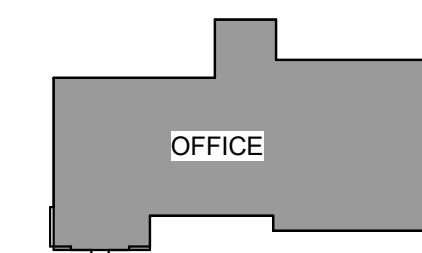
FIRST FLOOR PLUMBING DOMESTIC WATER PLAN - OFFICE
SCALE: 1/8" = 1'-0"
F.F.E. = 100.00' (CIVIL = 885.30')
NORTH

KEY PLAN


SSC JOB# 2025456

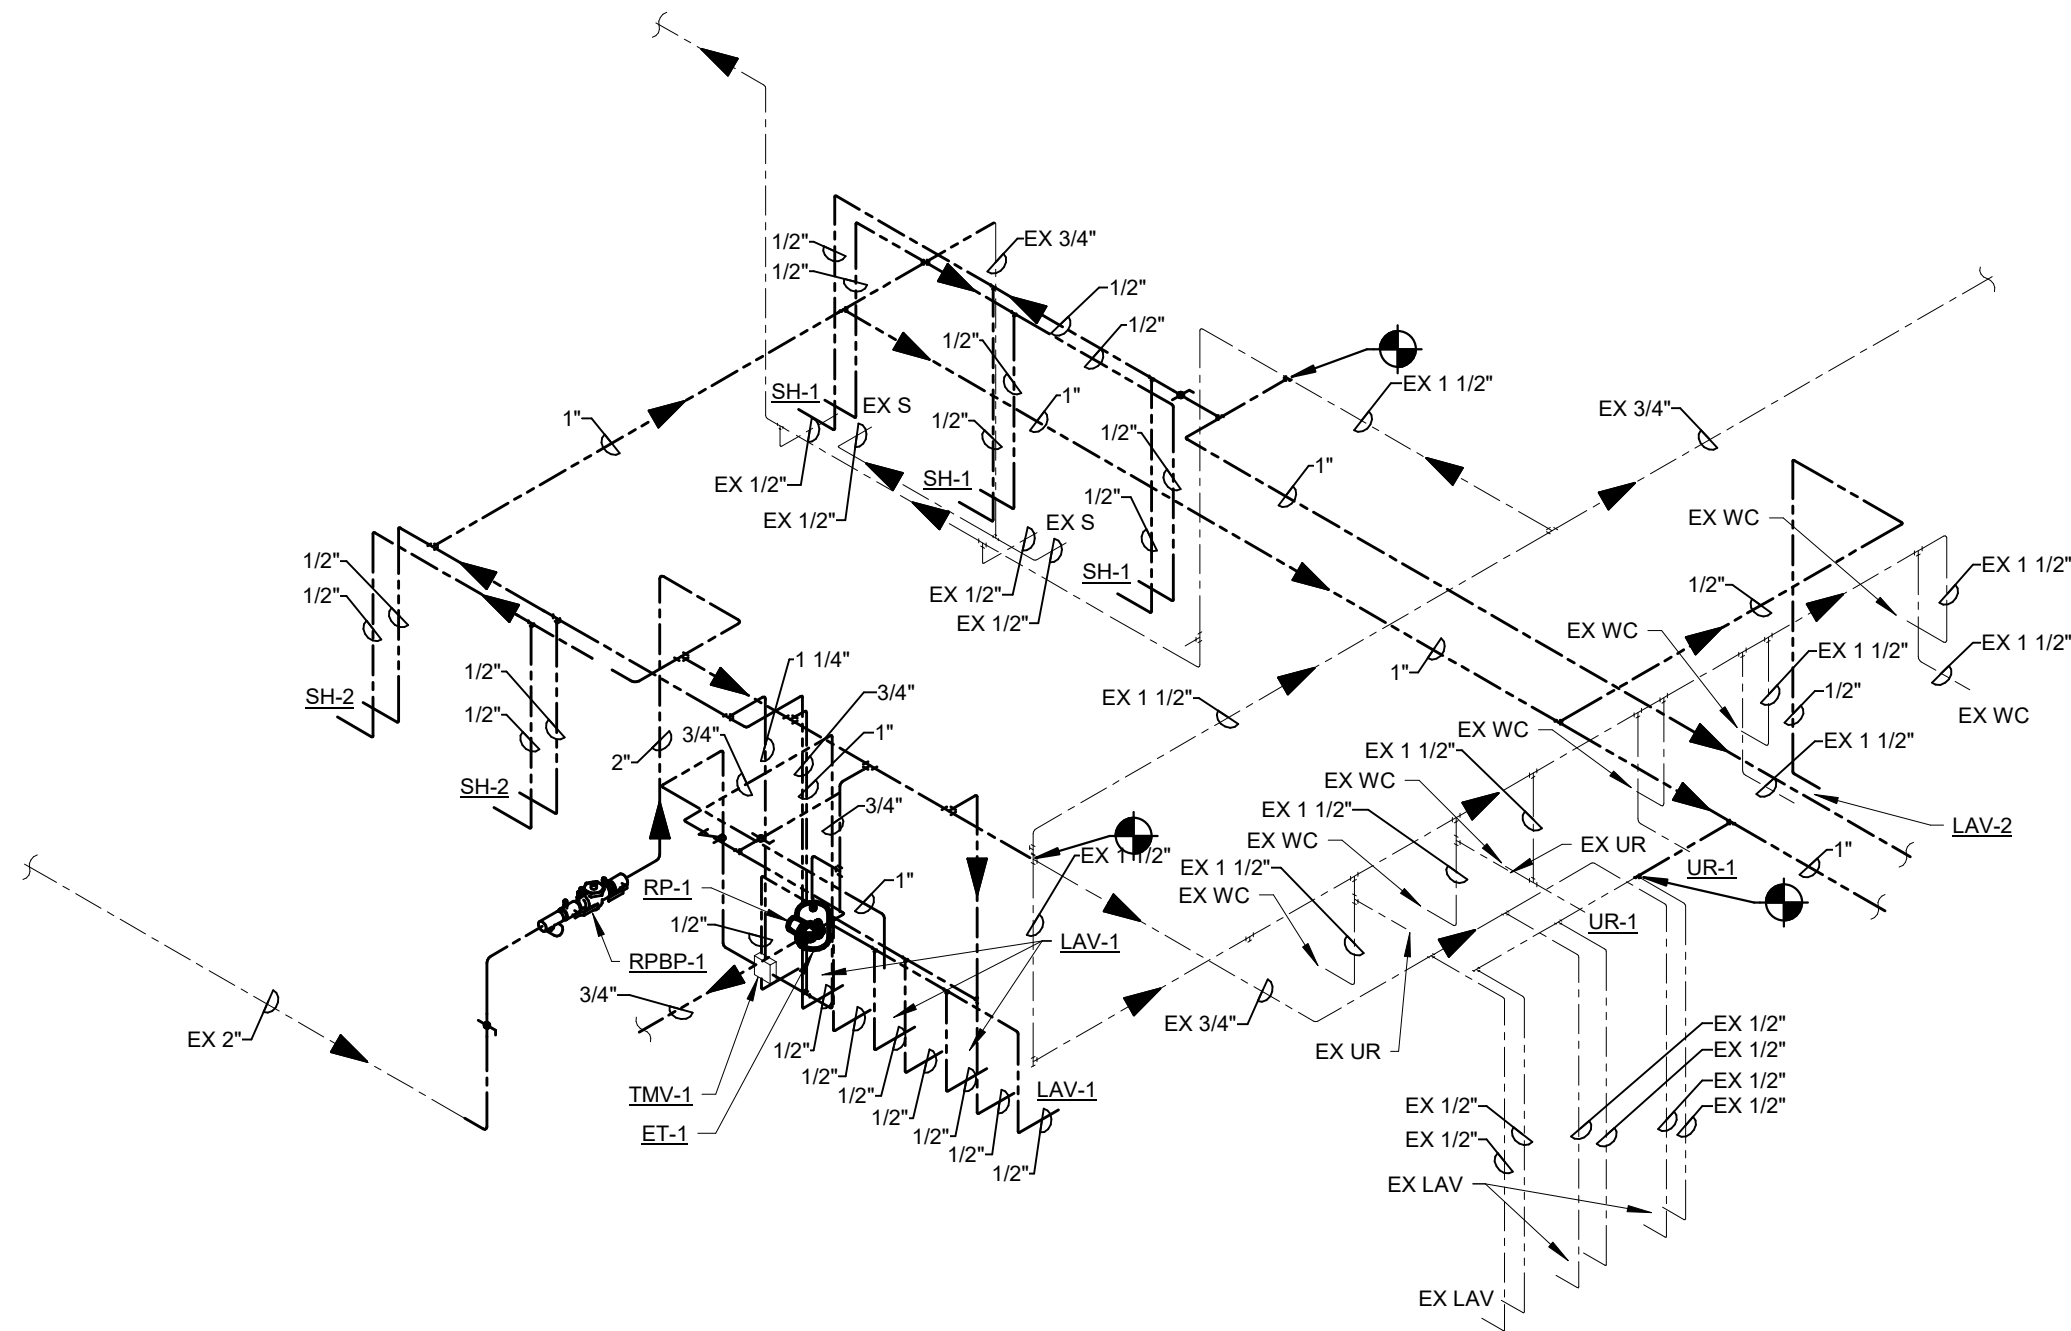


1 PLUMBING DOMESTIC WATER ISOMETRIC PLAN - OPERATIONS RENOVATION
NOT TO SCALE

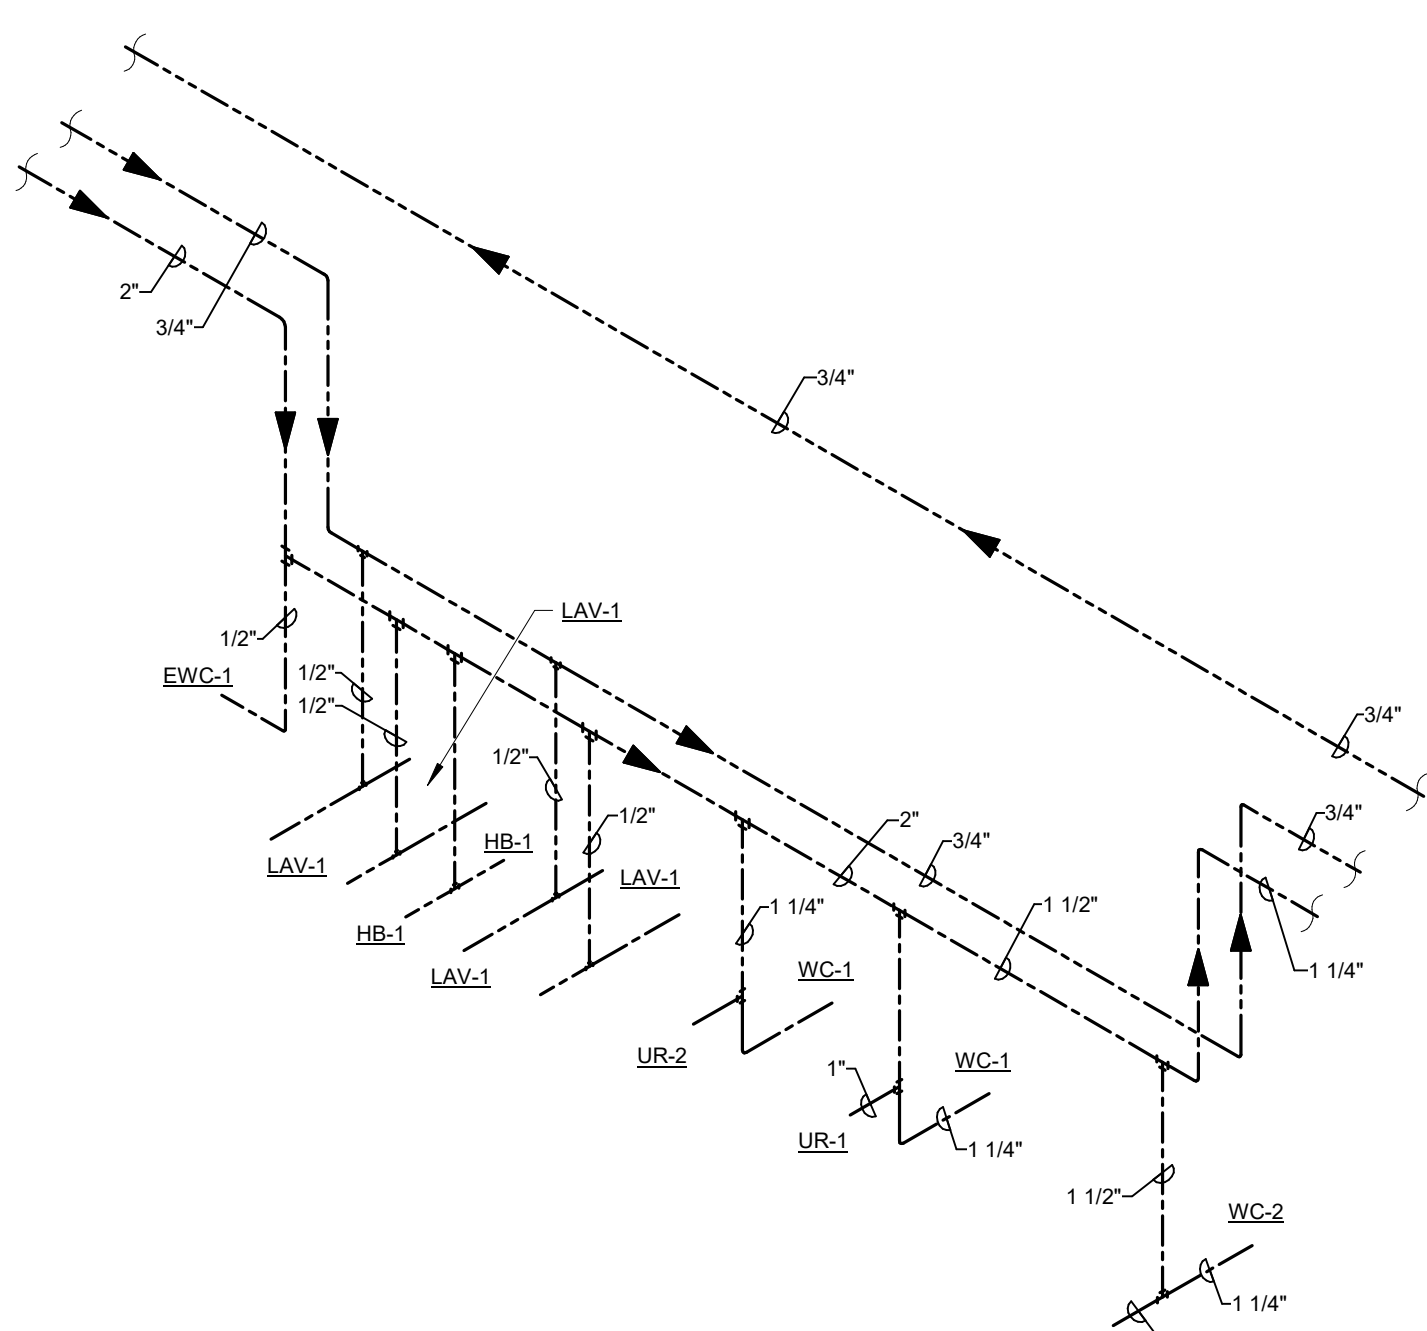


2 PLUMBING DOMESTIC WATER ISOMETRIC PLAN - OFFICE ROOMS 122 & 123
NOT TO SCALE

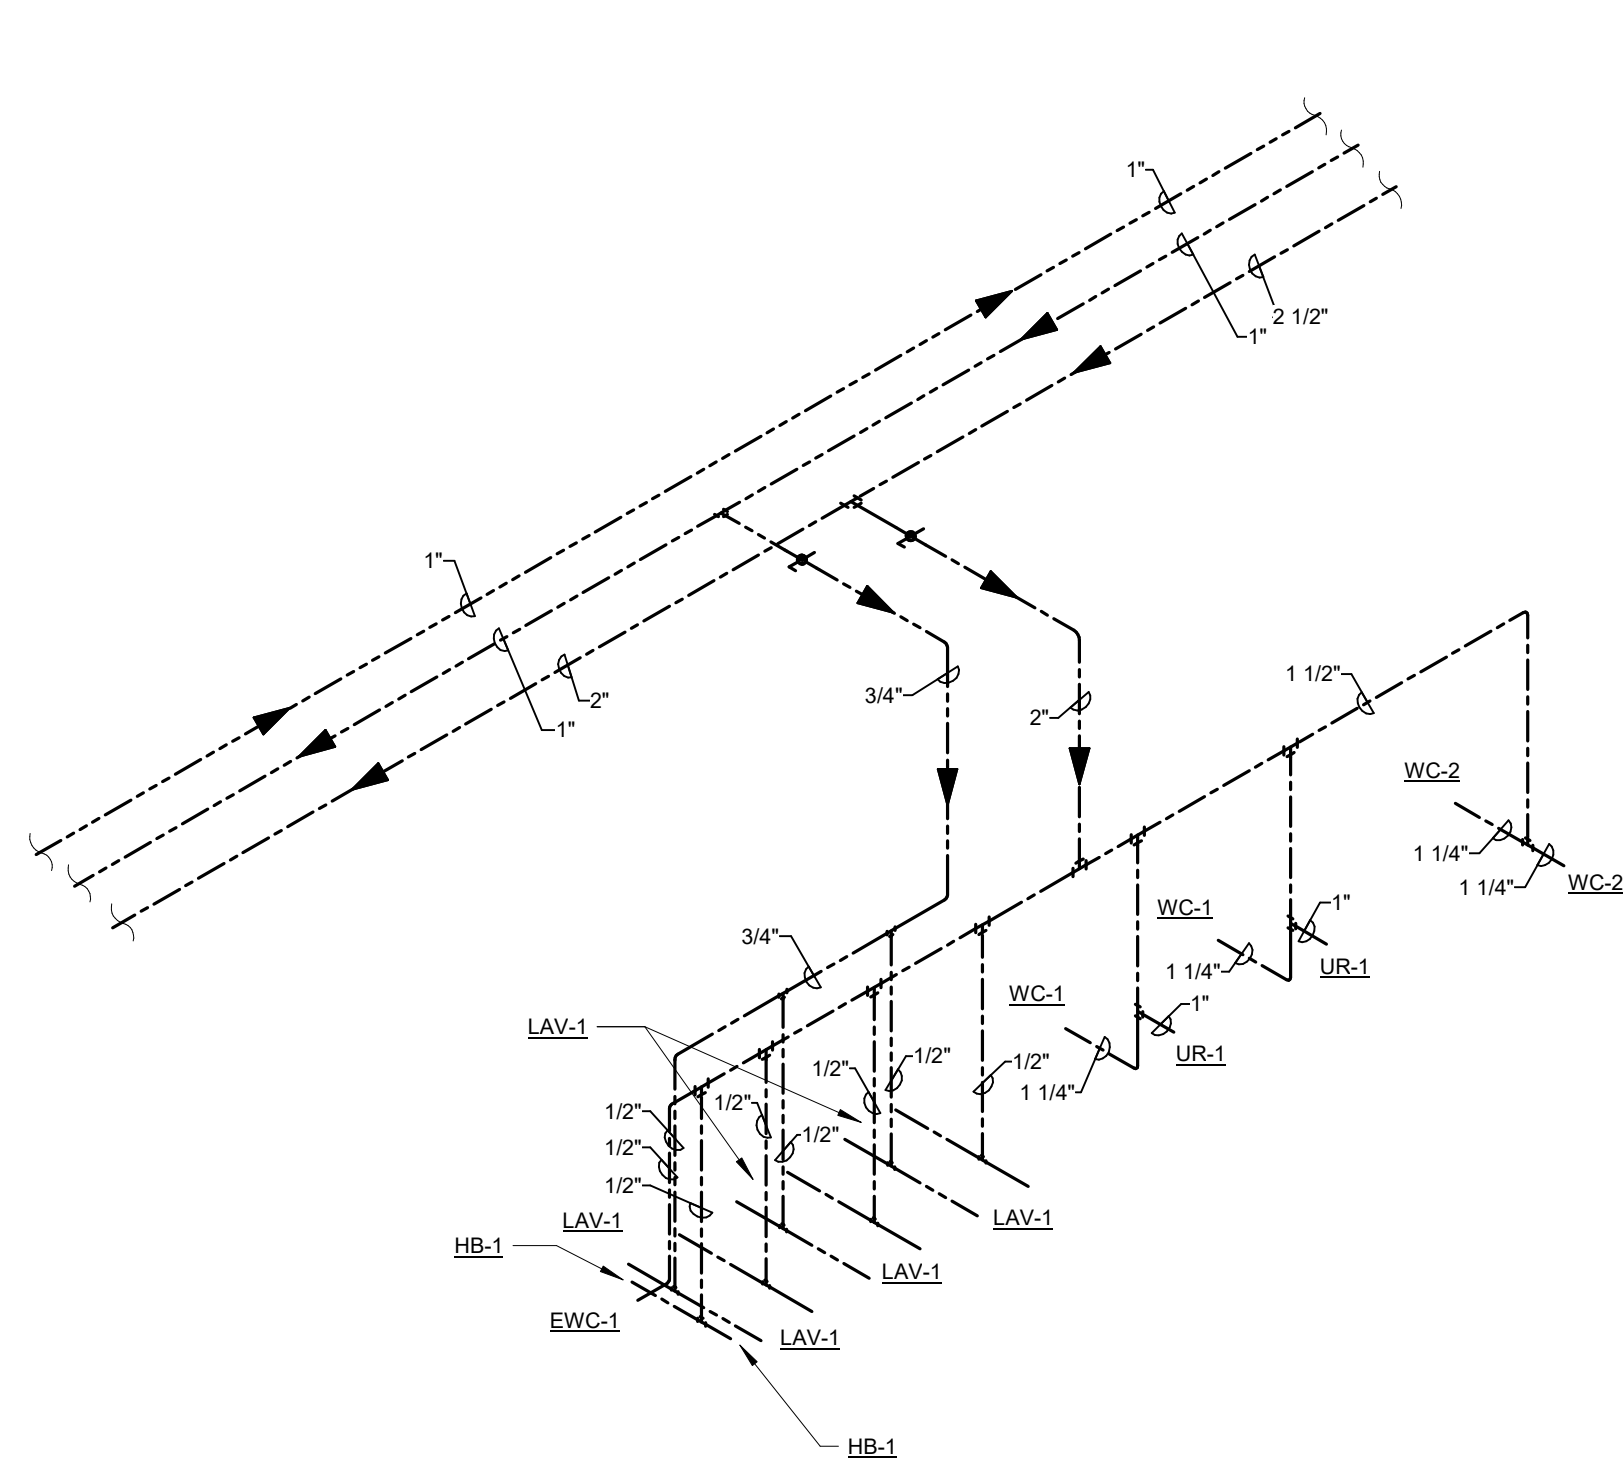


3 PLUMBING DOMESTIC WATER ISOMETRIC PLAN - OFFICE ROOMS 155 & 156
NOT TO SCALE

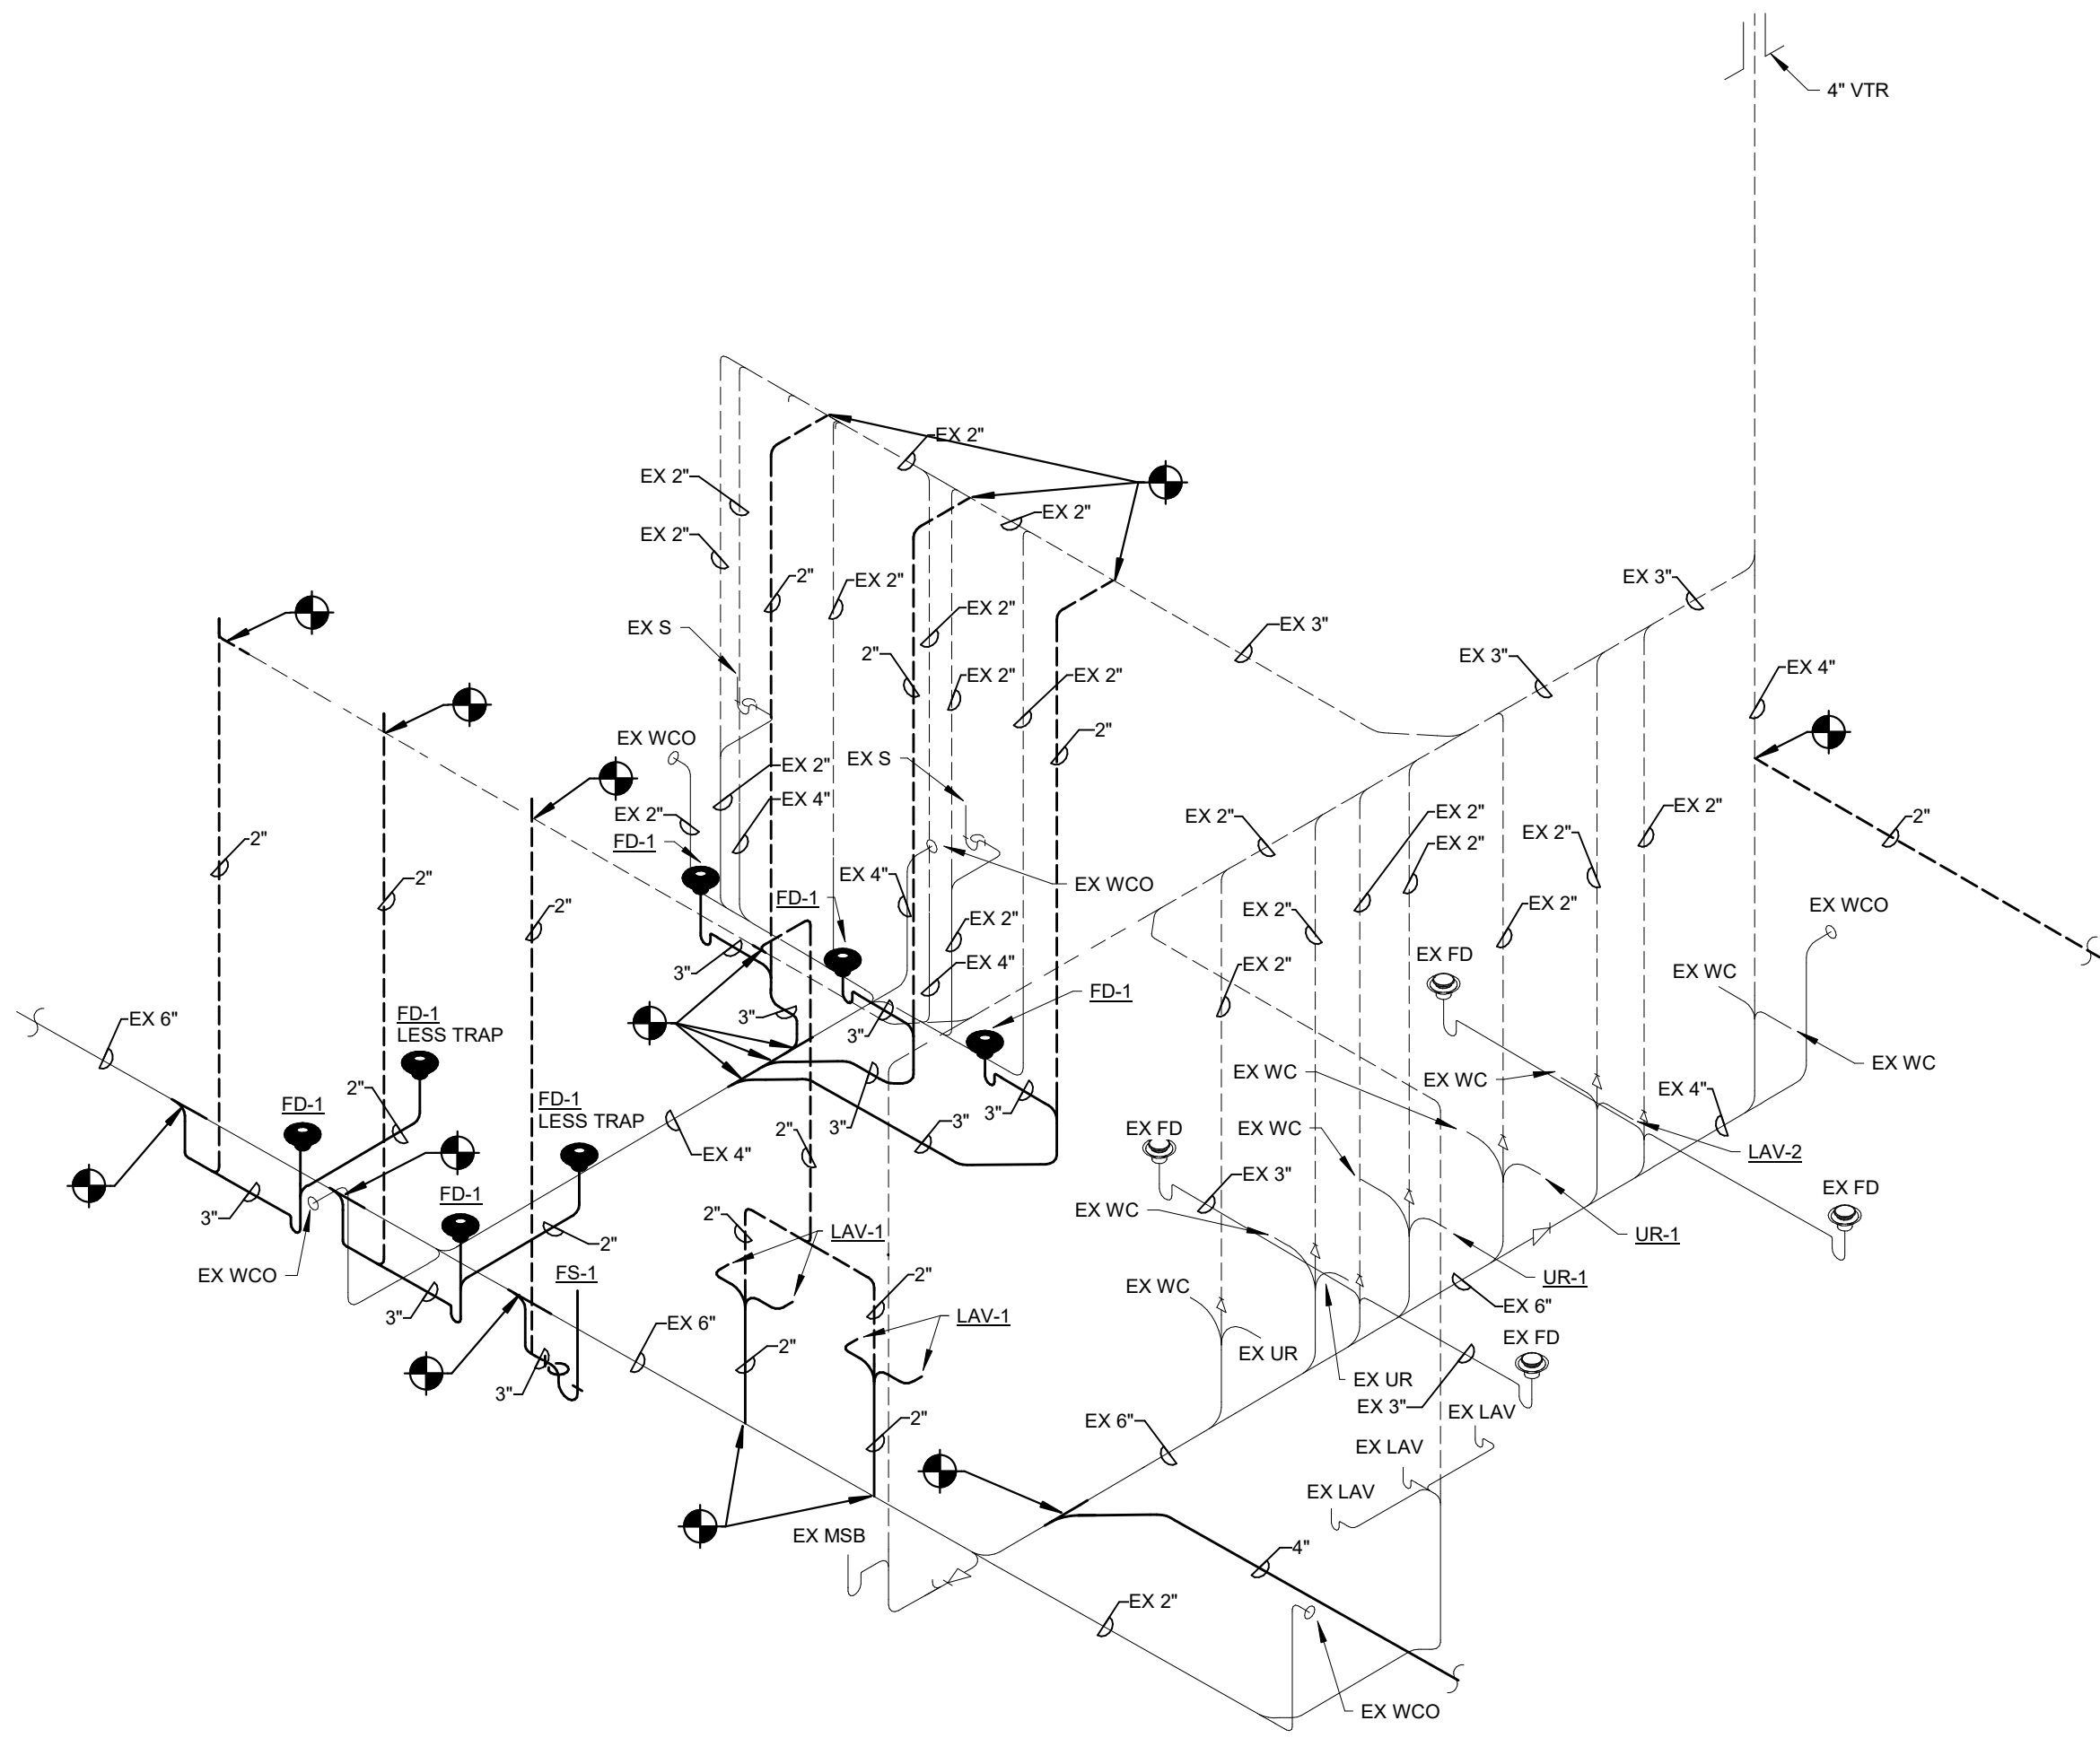

4 PLUMBING WASTE & VENT ISOMETRIC PLAN - OPERATIONS RENOVATION
NOT TO SCALE

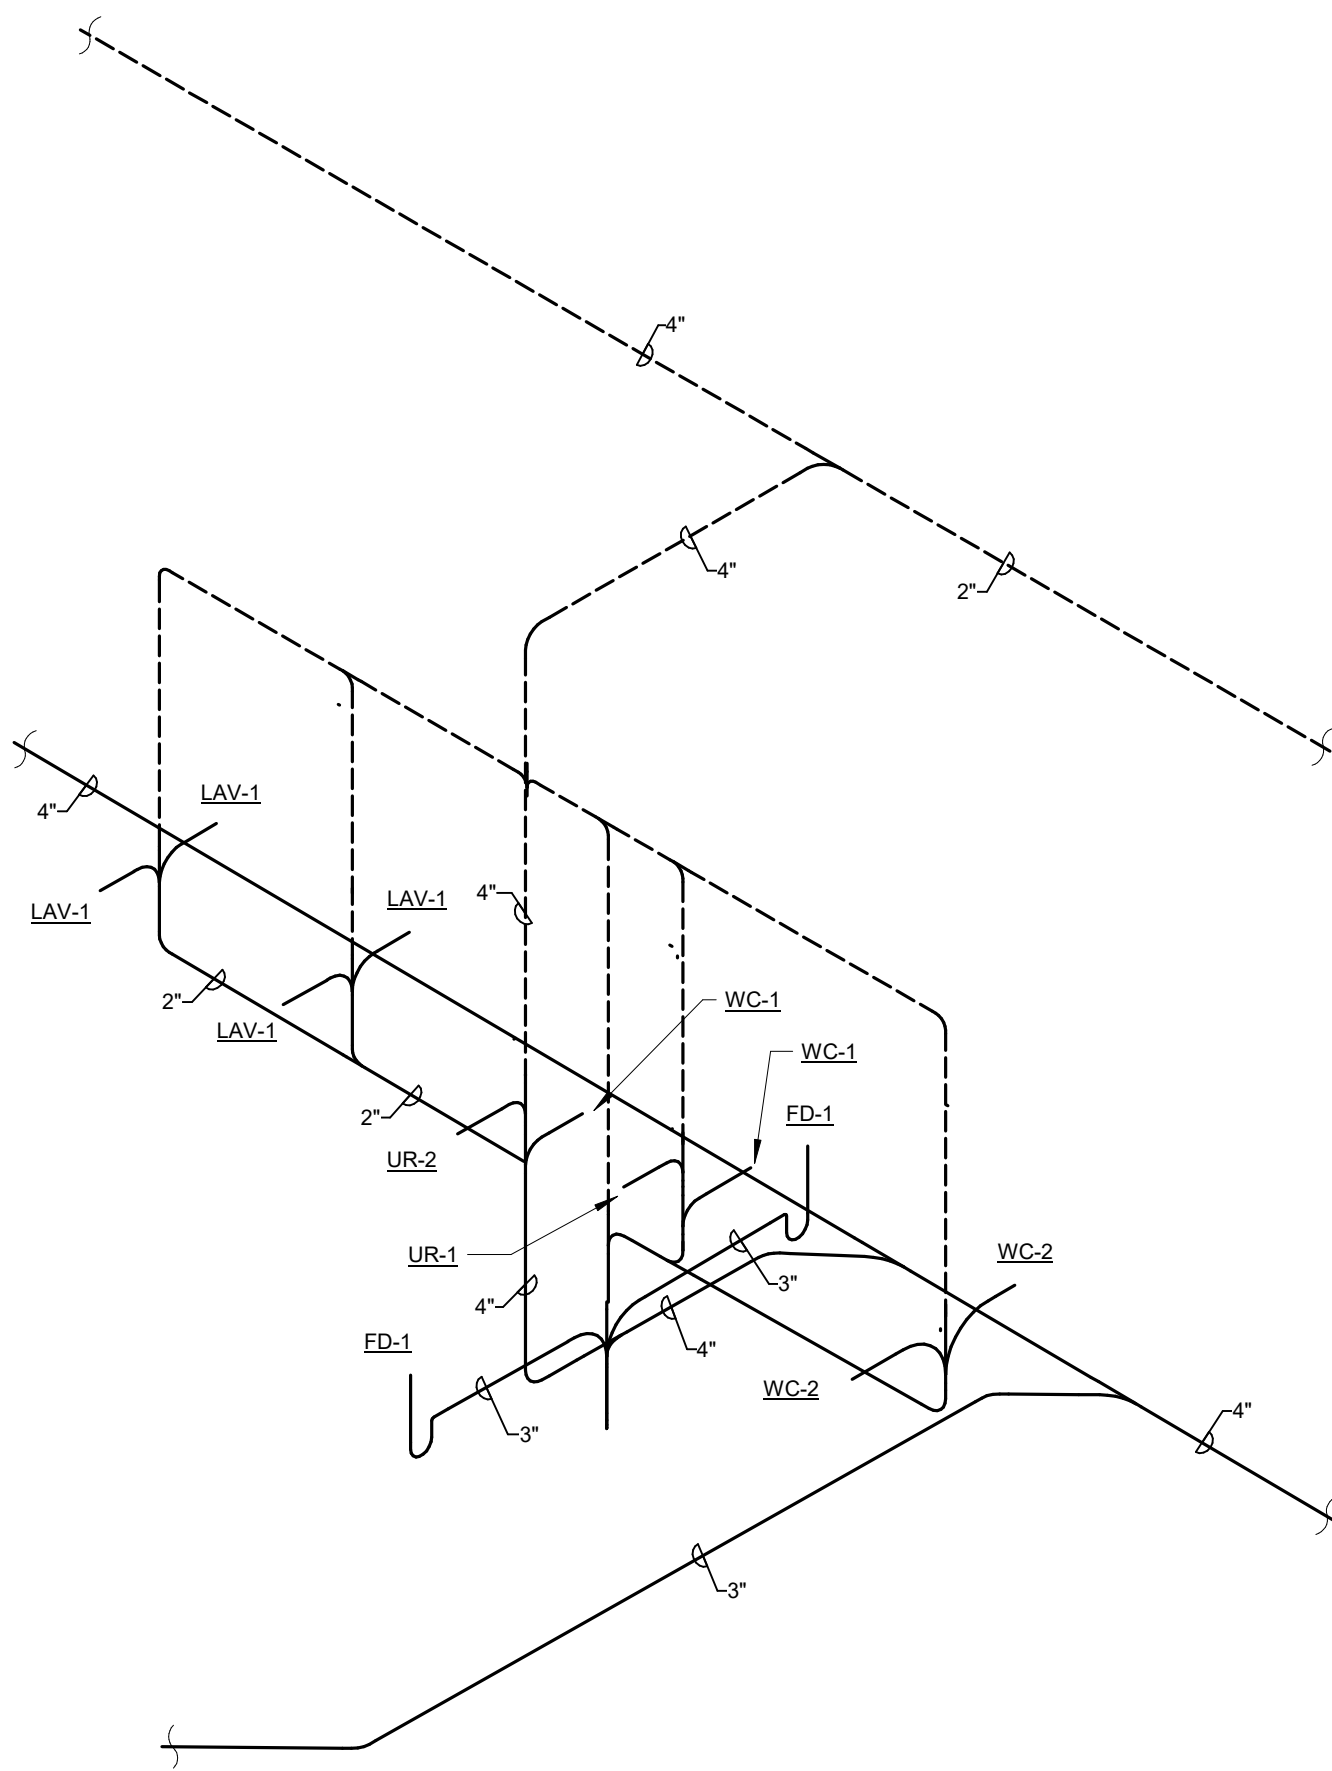

5 PLUMBING WASTE & VENT ISOMETRIC PLAN - OFFICE ROOMS 122 & 123
NOT TO SCALE

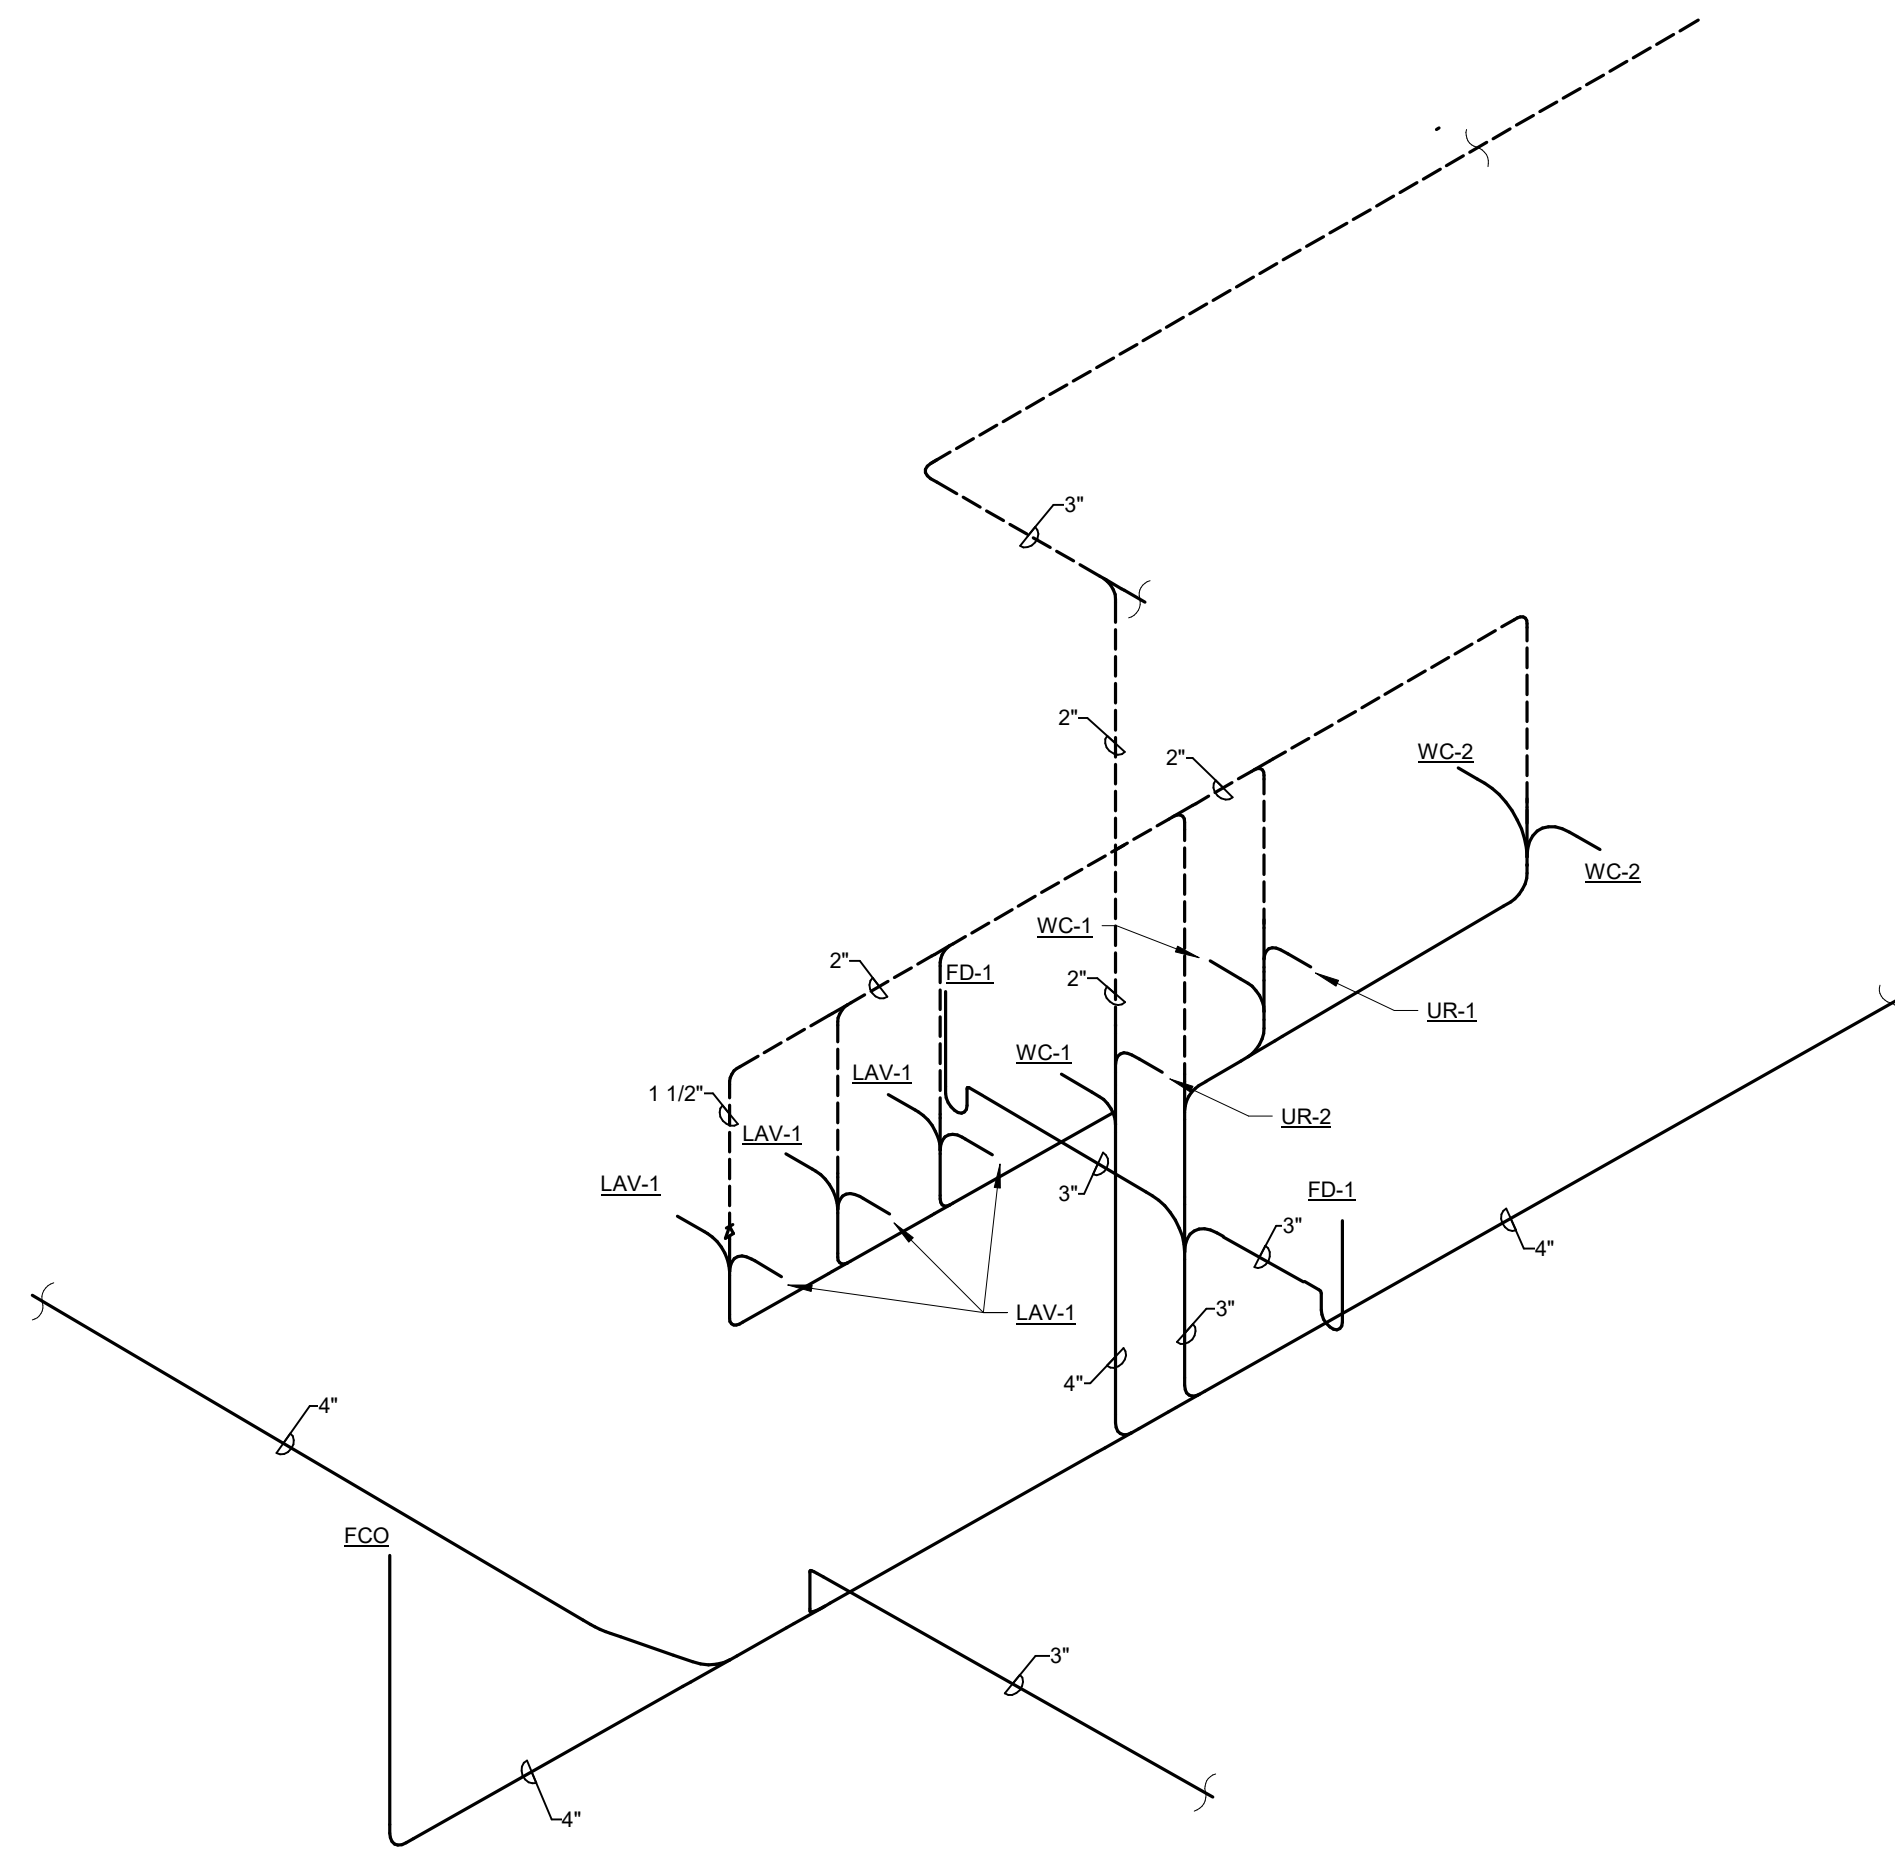

6 PLUMBING WASTE & VENT ISOMETRIC PLAN - OFFICE ROOMS 155 & 156
NOT TO SCALE