


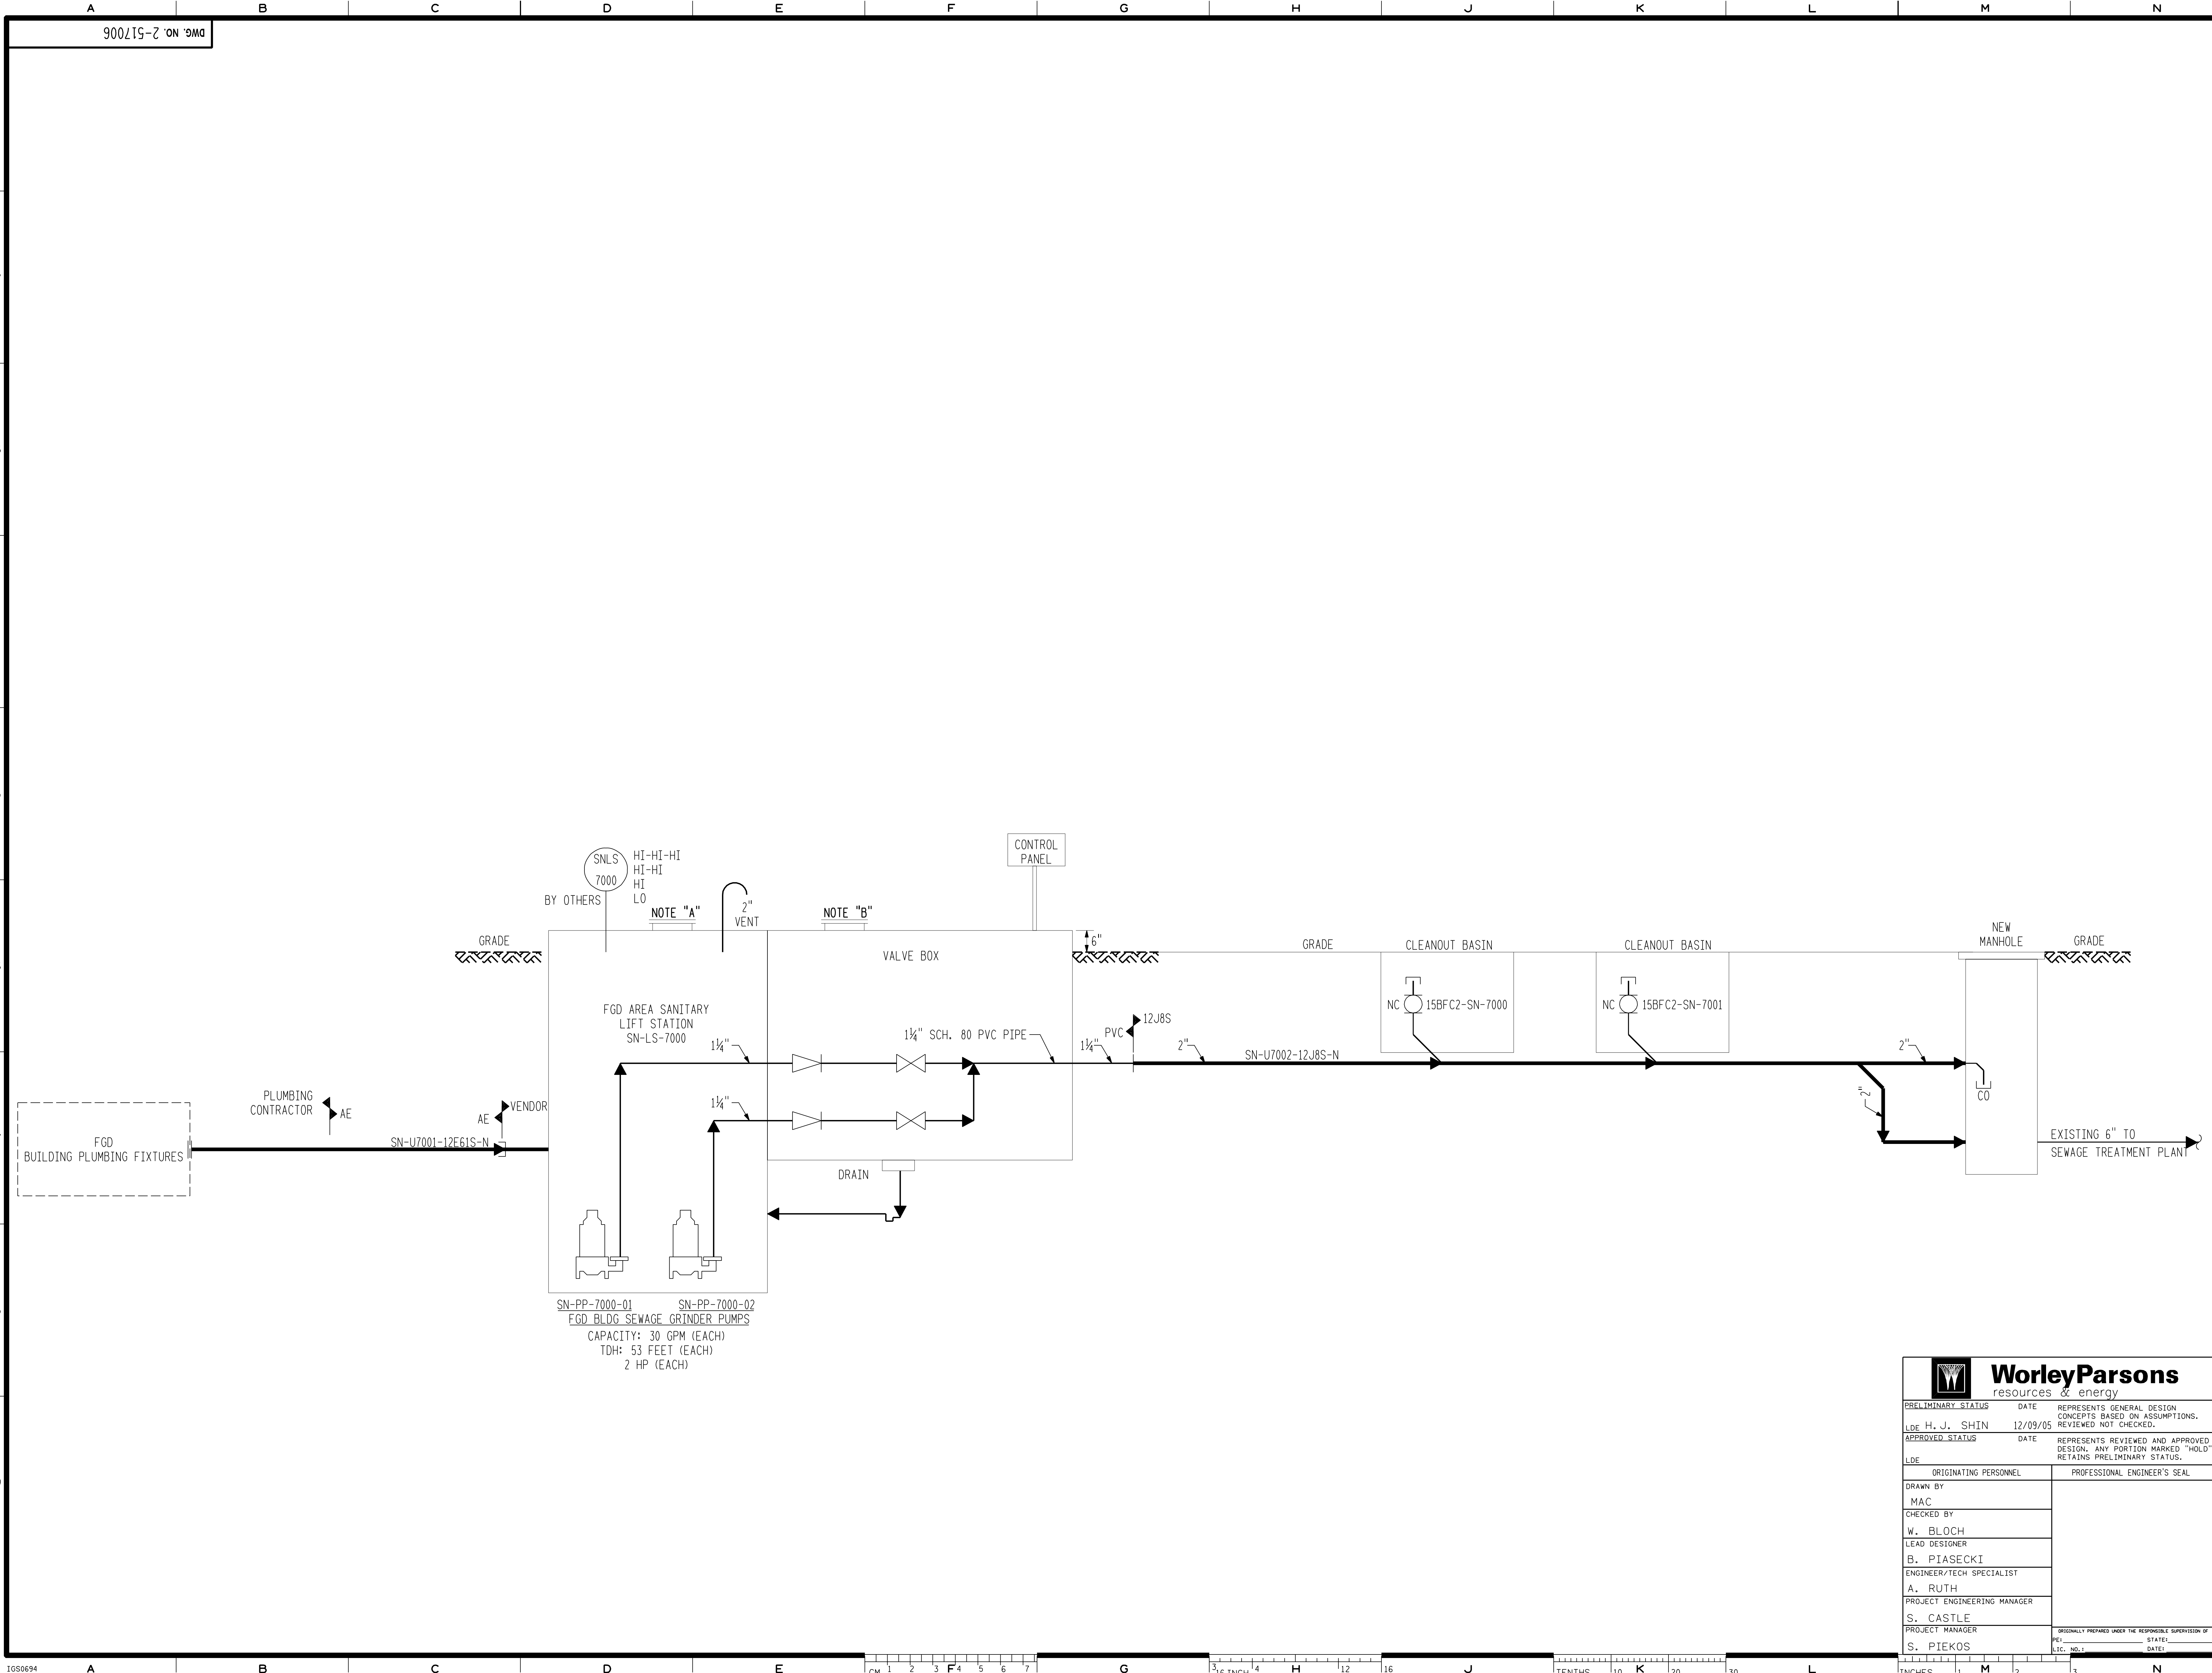

NOTES

FOR GENERAL NOTES, SYMBOLS AND SYSTEM CODES SEE DRAWING 5-517000

ALL TAG NOS. ARE PREFIXED BY PLANT CODE "BS".

ALL TAG NOS. HAVE UNIT TAG NO. "2" UNLESS OTHERWISE NOTED.

NOTE "A" (D6)
PUMP MAINTENANCE ACCESS.

NOTE "B" (E6)
VALVE ACCESS.

ISSUED FOR DRB REVIEW									
B	03/15/06	SMM	WB	BP	ASR	HJS	SC	SP	
REV	DATE	DRAWN	CHECKED	LEAD DESIGNER	ENGINEER/TECH SPEC	LEAD DDC	LEAD DDC	PROJ. MGR.	PROJECT MANAGER

ISSUED FOR REVIEW AND COMMENT									
A	02/02/06	SMM	WB	BP	ASR	HJS	SP	FGN	
REV	DATE	DRAWN	CHECKED	LEAD DESIGNER	ENGINEER/TECH SPEC	LEAD DDC	LEAD DDC	PROJ. MGR.	PROJECT MANAGER
DATE	NO.	DESCRIPTION						APPROD.	

REVISIONS

"THIS DRAWING IS THE PROPERTY OF THE AMERICAN ELECTRIC POWER SERVICE CORP. AND IS LOANED UPON CONDITION THAT IT IS NOT TO BE REPRODUCED OR COPIED, IN WHOLE OR IN PART, OR USED FOR FURNISHING INFORMATION TO ANY PERSON WITHOUT THE WRITTEN CONSENT OF THE AEP SERVICE CORP. OR FOR ANY PURPOSE DETRIMENTAL TO THEIR INTEREST, AND IS TO BE RETURNED UPON REQUEST"

**WorleyParsons**
resources & energy

PRELIMINARY STATUS	DATE	REPRESENTS GENERAL DESIGN CONCEPTS BASED ON ASSUMPTIONS. REVIEWED NOT CHECKED.
LDE H. J. SHIN	12/09/05	
APPROVED STATUS	DATE	REPRESENTS REVIEWED AND APPROVED DESIGN. ANY PORTION MARKED "HOLD" RETAINS PRELIMINARY STATUS.
LDE		
ORIGINATING PERSONNEL	PROFESSIONAL ENGINEER'S SEAL	
DRAWN BY	MAC	
CHECKED BY	W. BLOCH	
LEAD DESIGNER	B. PIASECKI	
ENGINEER/TECH SPECIALIST	A. RUTH	
PROJECT ENGINEERING MANAGER	S. CASTLE	
PROJECT MANAGER	S. PIEKOS	

ORIGINALLY PREPARED UNDER THE RESPONSIBLE SUPERVISION OF	PE	STATE:
LDC NO. 1		DATE:

KENTUCKY POWER COMPANY
BIG SANDY UNIT 2
BIG SANDY KENTUCKY

FLOW DIAGRAM
SANITARY DRAINS
SYSTEMS

DWG. NO. 2-517006-B

SCALE:	MECHANICAL ENGINEERING DIVISION
DR:	
CHR:	
DES:	
SUPPLY:	
DATE:	

DOCUMENT PREPARED BY WORLEYPARSONS	 AMERICAN ELECTRIC POWER	AEP SERVICE CORP. 1 RIVERSIDE PLAZA COLUMBUS, OH 43215
--	--	---