


B-295896-2 ON 9MD

- NOTES:
1. MCS IS A NON-AUTOMATIC MOLDED CASE SWITCH.
 2. TAG NUMBERS AND BUS NUMBERS ON HOLD.

REFERENCES:

2-121000 ELEC FGD PROJECT ONELINE DIAGRAM LEGEND
2-121010 ELECTRICAL COMMON FGD SWGR 43A 480V AUX ONELINE DIAGRAM
2-121011 ELECTRICAL COMMON FGD SWGR 43B 480V AUX ONELINE DIAGRAM
2-968561 ELECTRICAL UNIT 2 125VDC AND 120VAC UPS

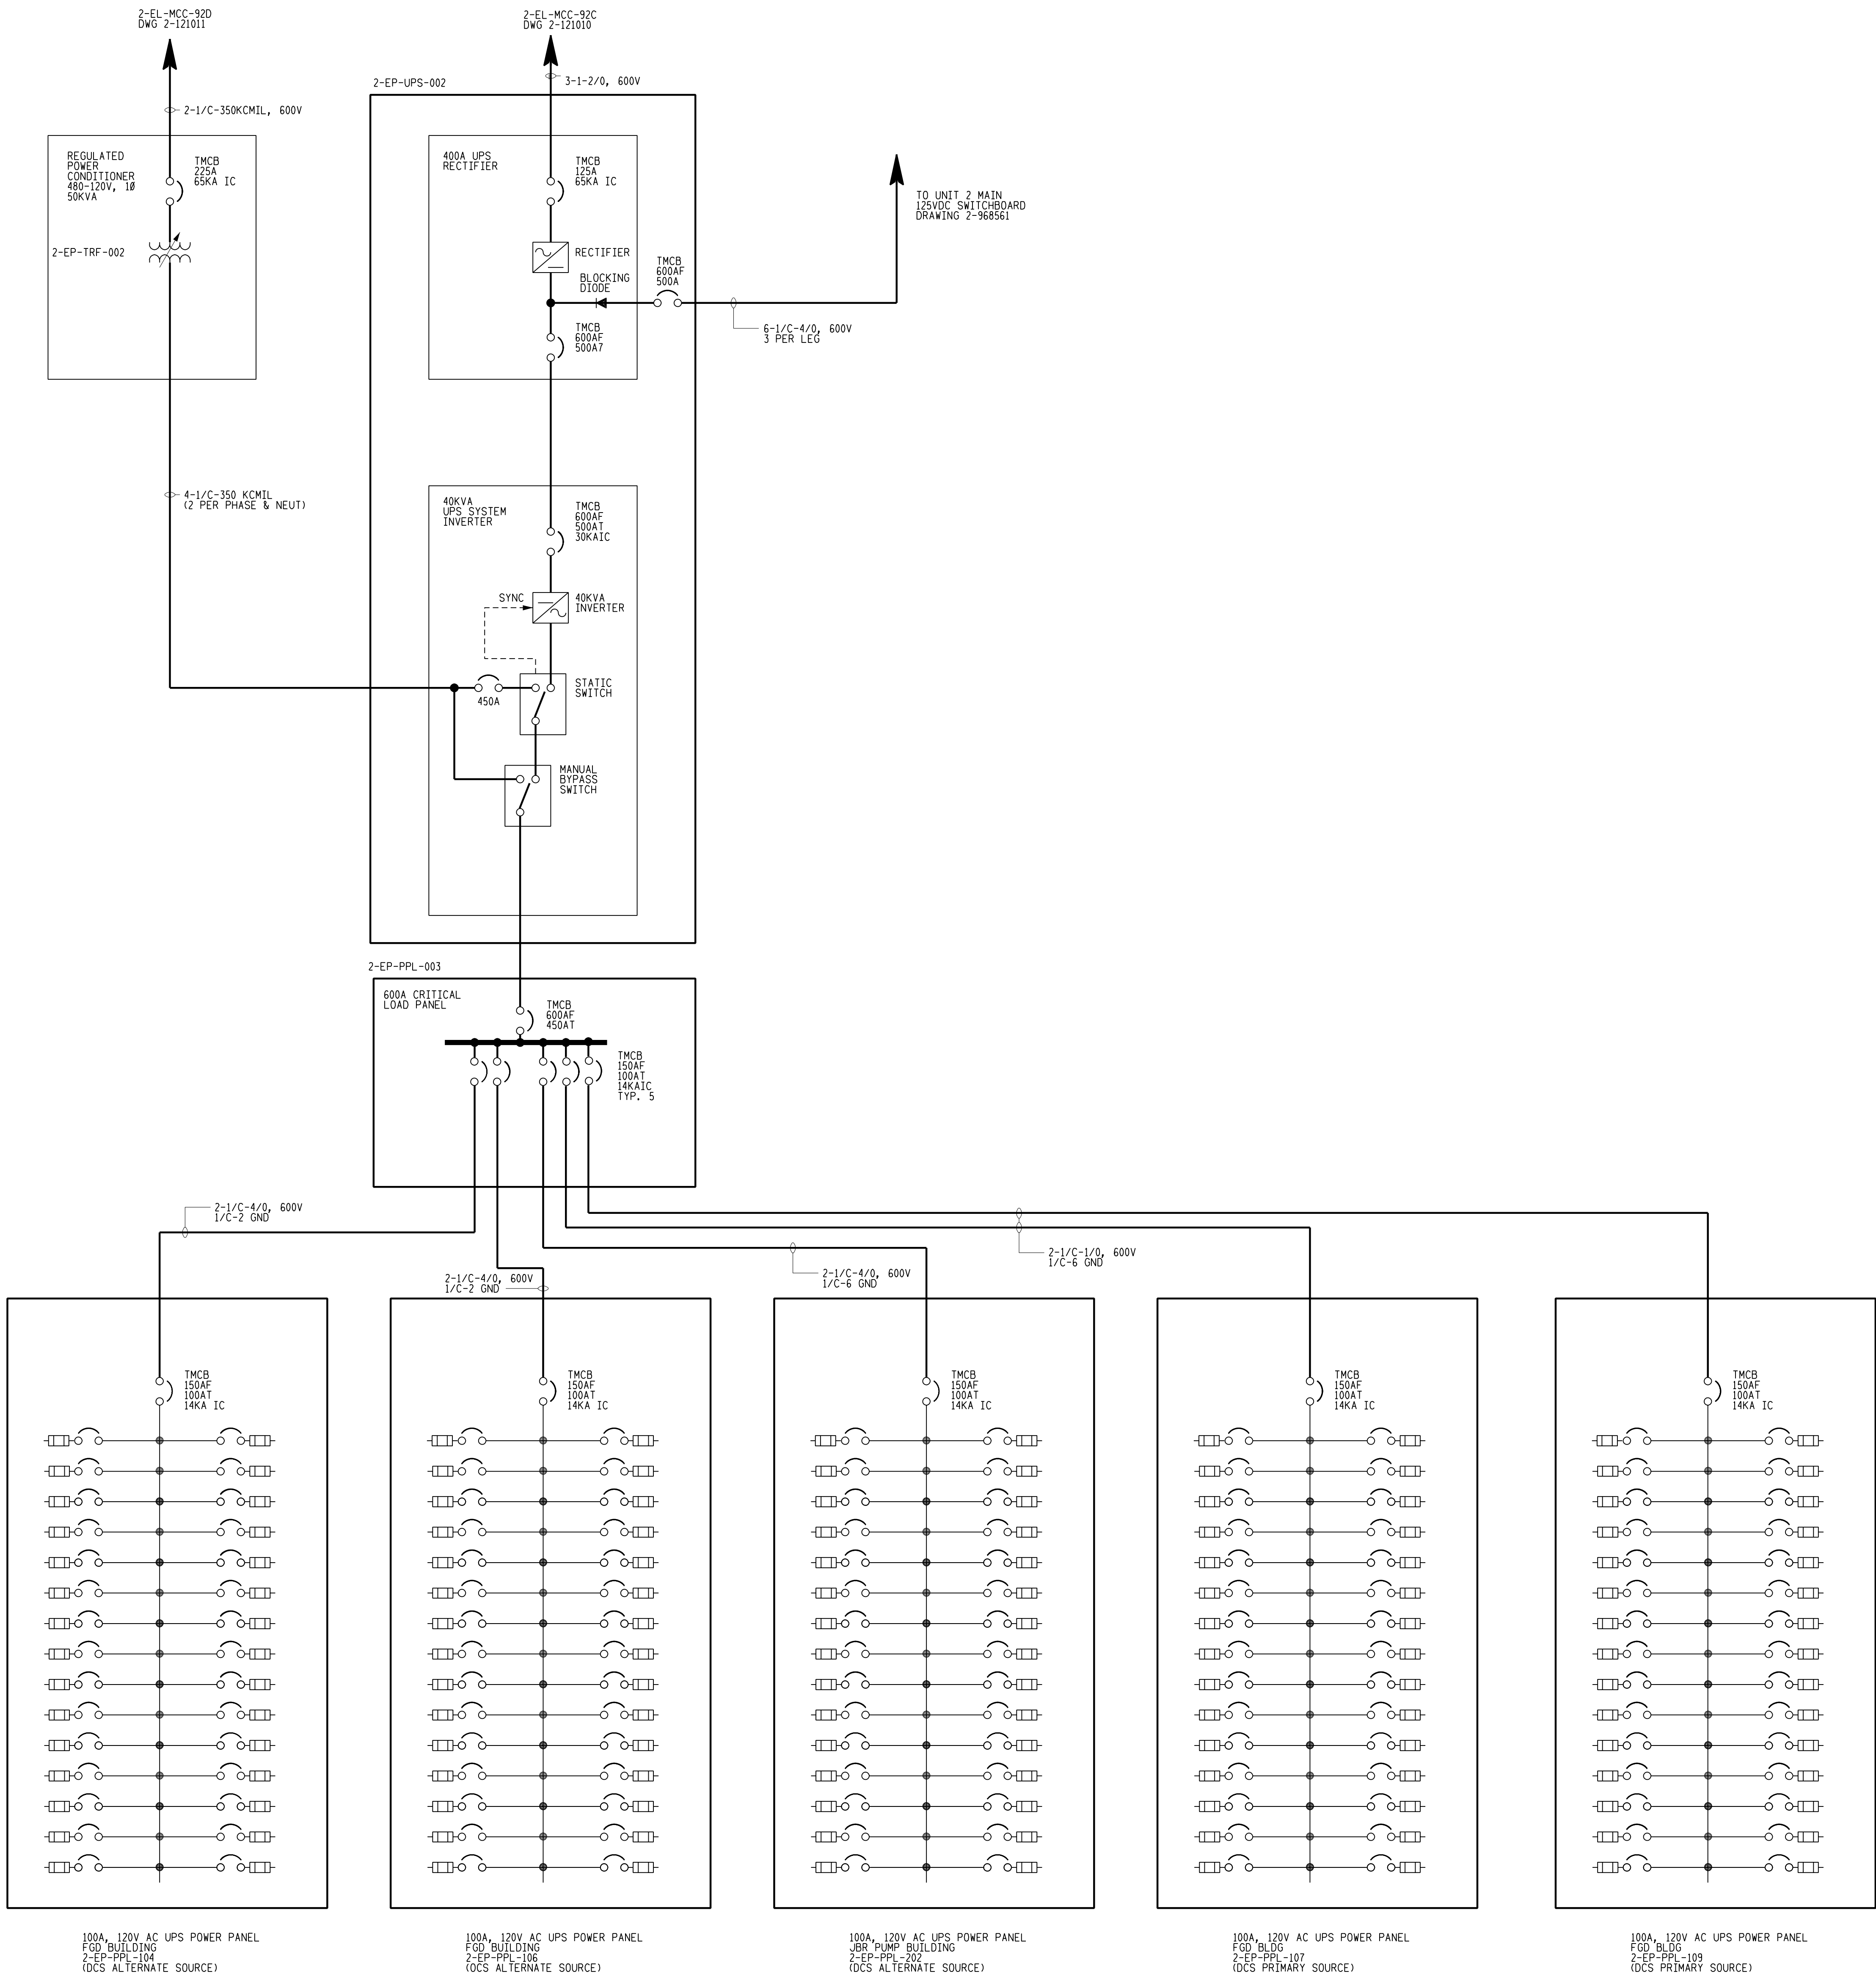

REISSUE - INCORPORATE
LATEST DIRECTION
FROM AEP

B 03/02/06 SSC RDJ SRP YRT SFC SJP

PRELIMINARY - FOR COMMENTS

A 02/14/06 JAF RDJ SRP YRT SFC SJP

REV	DATE	DRAWN	CHECKED	DESIGNED	ENGINEER	TECH SPEC	LEAD DISE	MANAGER	PROJECT

DATE NO. DESCRIPTION APPD.

REVISIONS

"THIS DRAWING IS THE PROPERTY OF THE AMERICAN ELECTRIC POWER SERVICE CORP. AND IS LOANED UPON CONDITION THAT IT IS NOT TO BE REPRODUCED OR COPIED, IN WHOLE OR IN PART, OR USED FOR FURNISHING INFORMATION TO ANY PERSON WITHOUT THE WRITTEN CONSENT OF THE AEP SERVICE CORP. OR FOR ANY PURPOSE DETRIMENTAL TO THEIR INTEREST, AND IS TO BE RETURNED UPON REQUEST"

WorleyParsons resources & energy	
PRELIMINARY STATUS	DATE
LDE YR. TAMAYO	02/14/06
APPROVED STATUS	DATE
LDE	
ORIGINATING PERSONNEL	PROFESSIONAL ENGINEER'S SEAL
DRAWN BY J. FLETCHER	
CHECKED BY	
LEAD DESIGNER R. D. JONES	
ENGINEER/TECH SPECIALIST SR PEDDIREDDI	
PROJECT ENGINEERING MANAGER SF CASTLE	
PROJECT MANAGER SJ PIEKOS	

KENTUCKY POWER COMPANY
BIG SANDY PLANT
BIG SANDY KENTUCKY

ELECTRICAL
AUXILIARY ONE LINE DIAGRAM
UNIT 2 120VAC UPS

DWG. NO. 2-968562-B

ELECTRICAL & CONTROLS ENGINEERING DIV.

SCALE:
ORI:
CHR:
SUPV:
ENGR:
DATE:

DOCUMENT
PREPARED BY
PARSONS ESC

AEP SERVICE CORP
1 RIVERSIDE PLAZA
COLUMBUS, OH 43215